

[illegible][illegible]

PA/MUSIC SYSTEM RELATED LEGEND

SYMBOL	DESCRIPTION	QUANTITY
	SPEAKER DIA - XX MM/ COLOUR WHITE	11
	AMPLIFIER	01
	BASS	02
	70/36 TRANSPARENT SPEAKER CABLE IN 25MM PVC CONDUIT	00

[illegible]

FIRST FLOOR

The floor plan illustrates the layout of the first floor, which includes several functional areas and rooms. The Mezzanine Floor Area (341.86 sq. ft.) is located at the top left, featuring a staircase and a reception desk. The Consulting Room (100.00 sq. ft.) is situated to the right of the Mezzanine, containing a large table and chairs. The BOH Area (210.43 sq. ft.) is located at the bottom left, featuring a kitchenette and storage areas. The Ground Floor FOH Area is the largest section, occupying the bottom right, and includes a reception desk and a large open space. Various equipment locations are marked with red dots and labeled with codes, while furniture and fixtures are shown in their respective locations. The plan also includes a detailed view of the ground floor FOH area, showing the layout of the reception desk and the surrounding space.


GROUND FLOOR

Scale: 1 : 75


LEGEND FOR SERVICES		
	EMERGENCY RECESSED DOWN LIGHT	
	RECESSED DOWN LIGHT -TYPE-01	DL-01
	RECESSED DOWN LIGHT TYPE-03	DL-03
	PERIPHERY CEILING COVE LIGHT	L-01
	L.E.D. LINEAR STRIP LIGHT BEHIND 30MM X 30MM S.S BAR	L-02
	T5 TUBE LIGHT IN BOH	
		
	ADJUSTABLE TRACK LIGHT	TS1

[illegible]

FIRST FLOOR

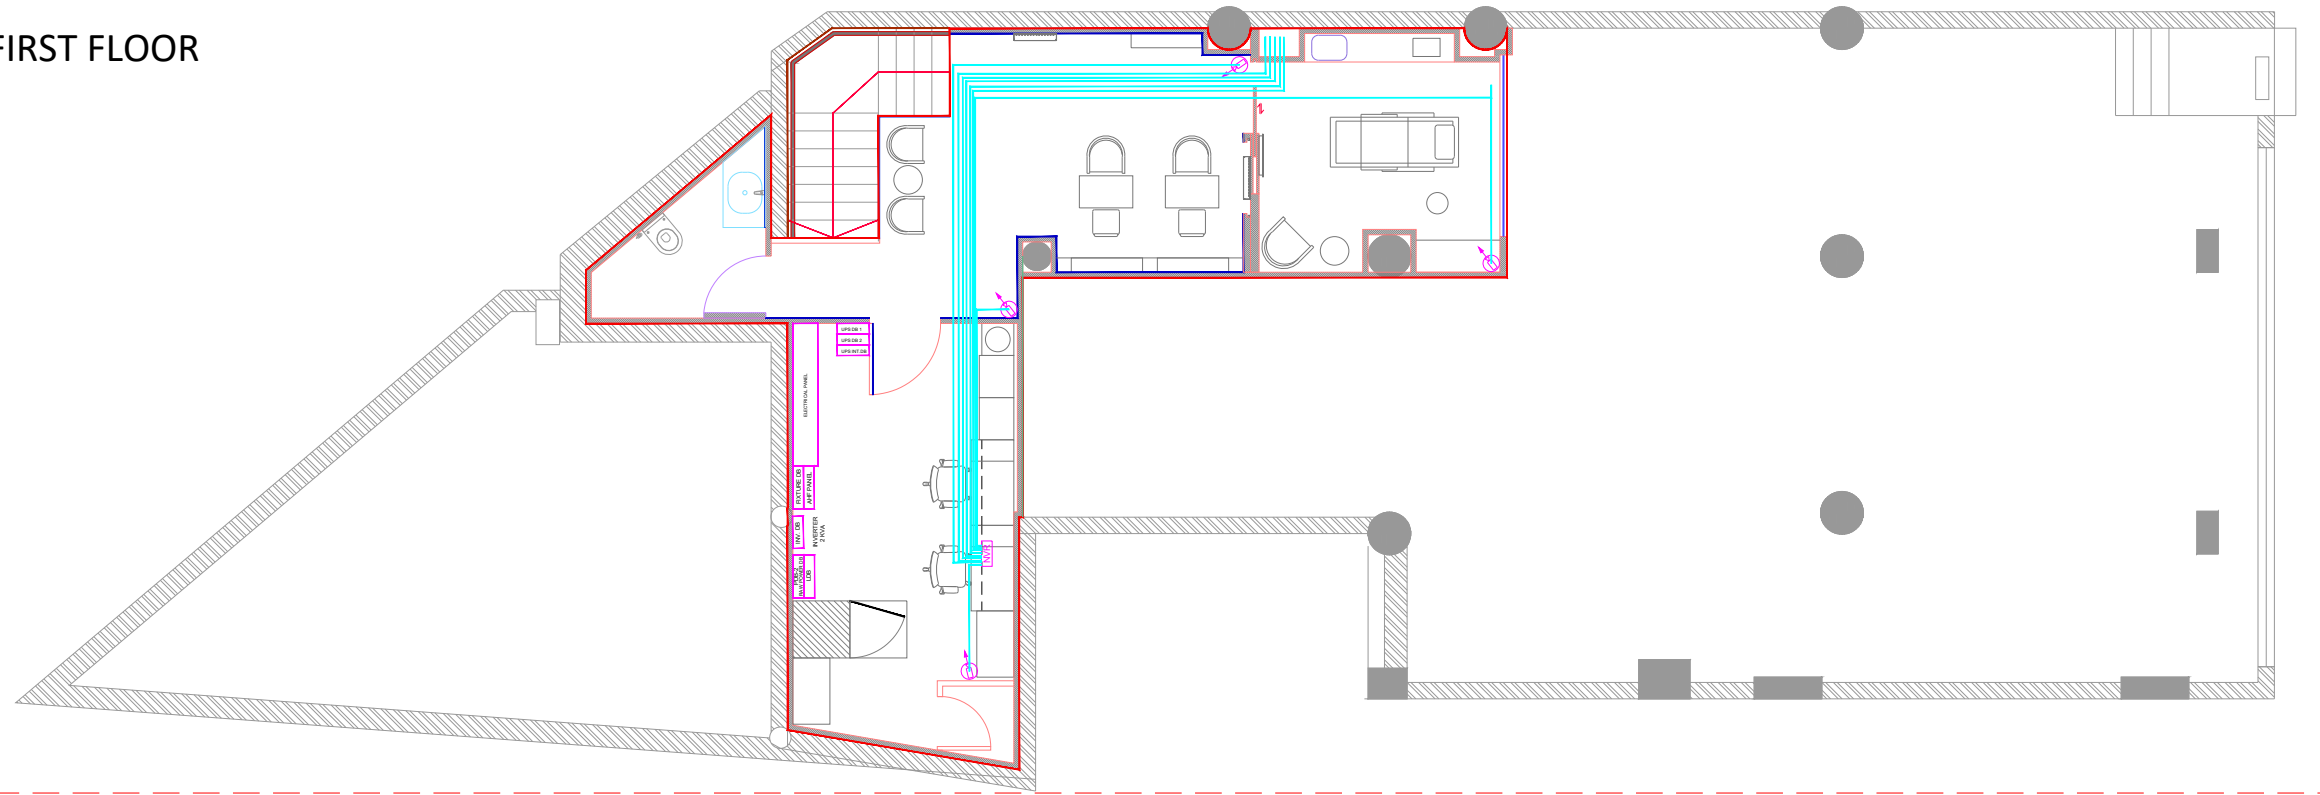

GROUND FLOOR

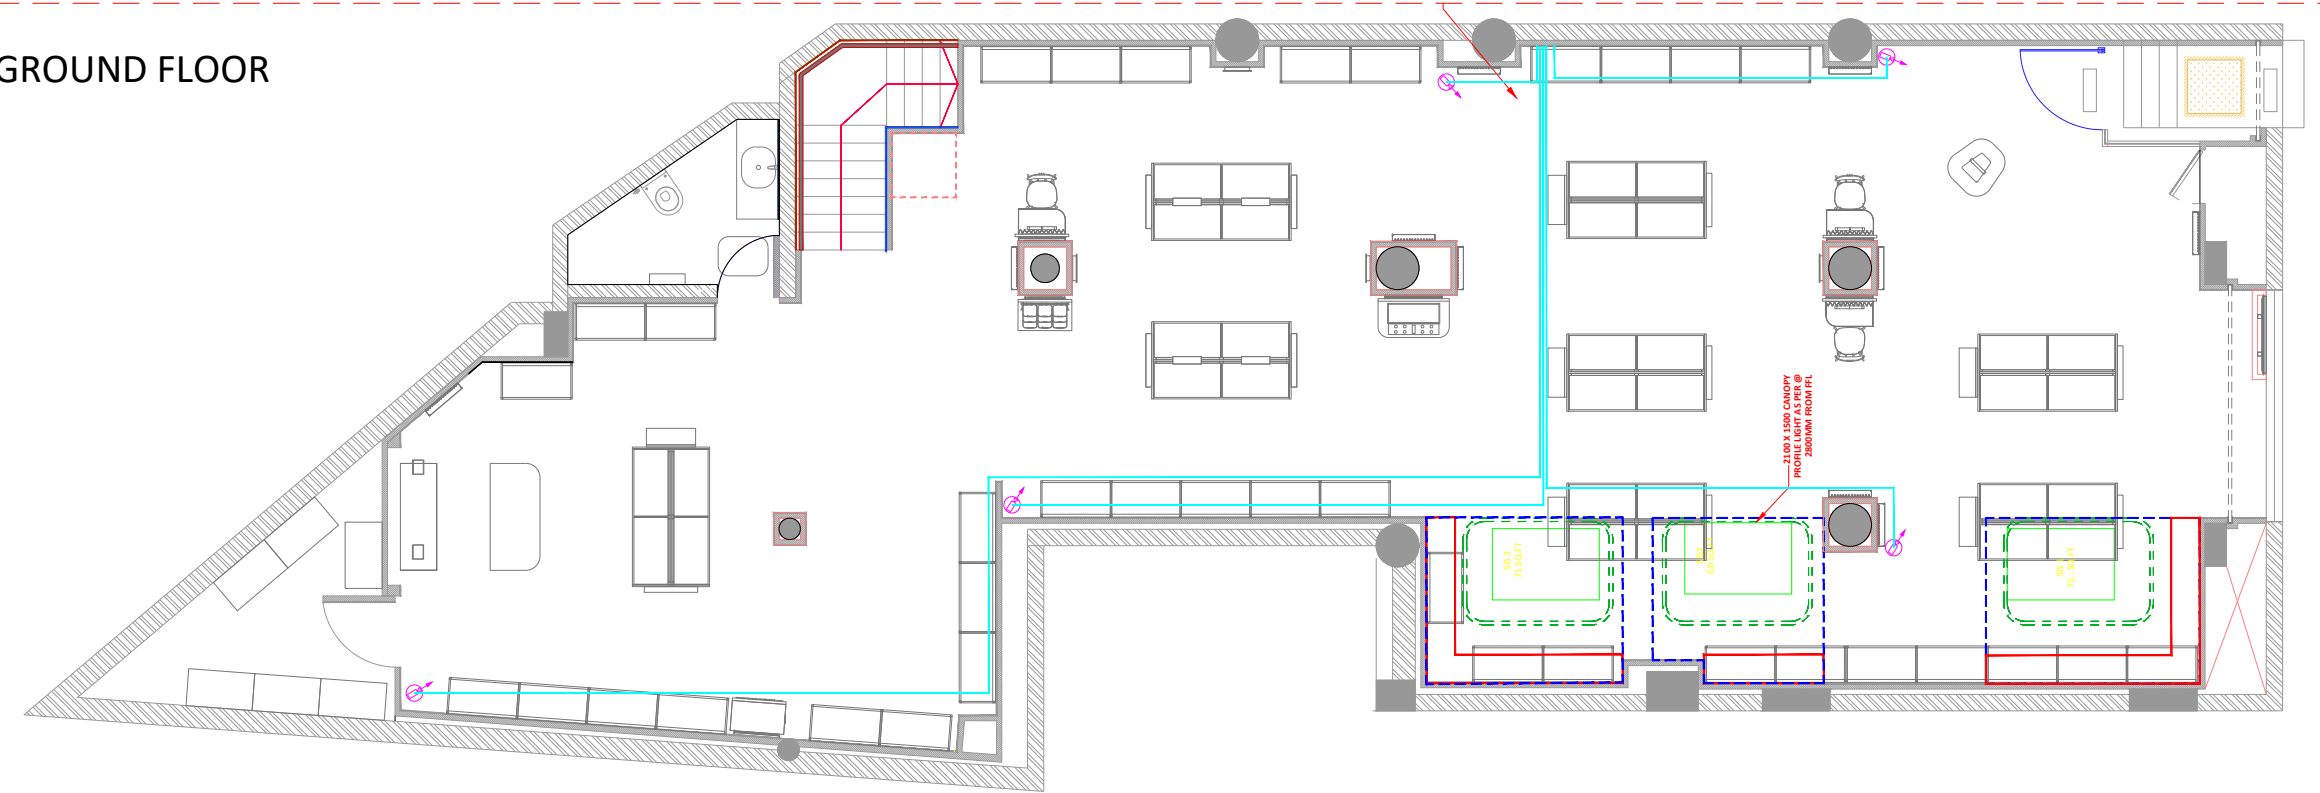

CCTV LAYOUT
Scale: 1 : 75

CCTV SYSTEM RELATED LEGEND

SYMBOL	DESCRIPTION	QUANTITY
	IP FIXED DOME CAMERA COLOUR - WHITE	09
	CCTV FOOTAGE RECIEVER	01
	CCTV CABLING	00

tira

**RELIANCE BEAUTY
@ ANITA DONGRE,
KEMPS CORNER,MUMBAI**



H2O ARCHITECTS.
37/A 3, SMRUTI, RD NO - 24
ION W. MUMBAI - 400022
mail to: pooja@h2oarchitects.in
visit us: www.h2oarchitects.in



Arsh Consulting Services
S/A, Ashar Belleza,
Road No-16, Wagale Estate,
Mumbai (W), Pin-400 604
Mail to : info@arshconsulting.co.in
Visit us : www.arshconsulting.co.in

NOTES:

2. THESE DRAWINGS AND SPECIFICATIONS ARE
3. CONFIDENTIAL AND SHALL REMAIN THE SOLE
4. PROPERTY OF IDO ARCHITECTS, APPOINTED CONSULTANT FOR
5. THE PROJECT BY REFERENCE.
6. THEY SHALL NOT BE REPRODUCED (IN WHOLE OR IN PART),
7. SHARED WITH THIRD PARTIES OR USED IN ANY MANNER ON
8. OTHER PROJECTS OR EXTENSIONS TO THIS PROJECT WITHOUT THE
9. PRIOR WRITTEN CONSENT OF IDO ARCHITECTS.
10. THESE DRAWINGS AND SPECIFICATIONS ARE INTENDED TO
11. EXECUTE THE CONCEPT DESIGN RECEIVED FROM THE BRAND.
12. ALL DIMENSION ARE IN MM. UNLESS OTHERWISE MENTIONED.
13. WRITTEN INTENTION ARE TO BE FOLLOWED. DRAWING NOT TO BE
14. SCALED.
15. CONTRACTOR SHOULD VERIFY THE DRAWINGS IN FIELD BEFORE
16. COMMENCEMENT OF THE WORK AND IN CASE OF ANY
17. DISCREPANCY CONTACT SITE INCHARGE PRIOR TO THE
18. EXECUTION.

STORE AREA
280.67 SQ.MT
3021.10 SQ.FT

SURVEYED DRAWING	
DRAWING FOR INFORMATION	
DRAWINGS FOR APPROVALS	
DRAWINGS FOR TENDER	
GFC DRAWINGS	
ASBUILT DRAWINGS	

DRAWING TITLE

CCTV LAYOUT

SHEET SIZE - A2(594MM X 420MM)

SCALE: 1:75

DRAWING BY JAYESH

CHECKED BY POOJA

DRAWING NO

ID07

REV NO	DATE	REMARKS
R0	19-12-24	

NOTES:

1. THESE DRAWINGS AND SPECIFICATIONS ARE
2. CONFIDENTIAL AND SHALL REMAIN THE SOLE
3. PROPERTY OF H2O ARCHITECTS, APPOINTED CONSULTANT FOR THE PROJECT BY RELIANCE .
4. THEY SHALL NOT BE REPRODUCED (IN WHOLE OR IN PART), SHARED WITH THIRD PARTIES OR USED IN ANY MANNER ON OTHER PROJECTS OR EXTENSIONS TO THIS PROJECT WITHOUT THE PRIOR WRITTEN CONSENT OF H2O ARCHITECTS.
5. THESE DRAWINGS AND SPECIFICATIONS ARE INTENDED TO EXECUTE THE CONCEPT DESIGN RECEIVED FROM THE BRAND.
6. ALL DIMENSIONS ARE IN MM, UNLESS OTHERWISE MENTIONED.
7. WRITTEN DIMENSION ARE TO BE FOLLOWED, DRAWING NOT TO BE SCALED.
8. CONTRACTOR SHOULD VERIFY THE DRAWINGS IN FIELD BEFORE COMMENCEMENT OF THE WORK AND IN CASE OF ANY DISCREPANCY, CONTACT SITE INCHARGE PRIOR TO THE EXECUTION.

STORE AREA
292.88 SQ.MT
2853.83 SQ.FT

SURVEYED DRAWING

DRAWING FOR INFORMATION

DRAWINGS FOR APPROVALS

DRAWINGS FOR TENDER

GFC DRAWINGS

ASBUILT DRAWINGS

DRAWING TITLE

**POWER SOCKET &
DATA/VOICE LAYOUT**

SHEET SIZE - A2(594MM X 420MM)

SCALE: 1:75

DRAWING BY

JAYESH


CHECKED BY

POOJA

DRAWING NO

MEP06

REV NO	DATE	REMARKS
R0	23-05-23	
R1	23-06-23	INTERIOR & MEP LAYOUT REVISED
R2	03-07-23	C&I COMMENT INCORPORATE
R3	01-09-23	REVISED SDR & ML

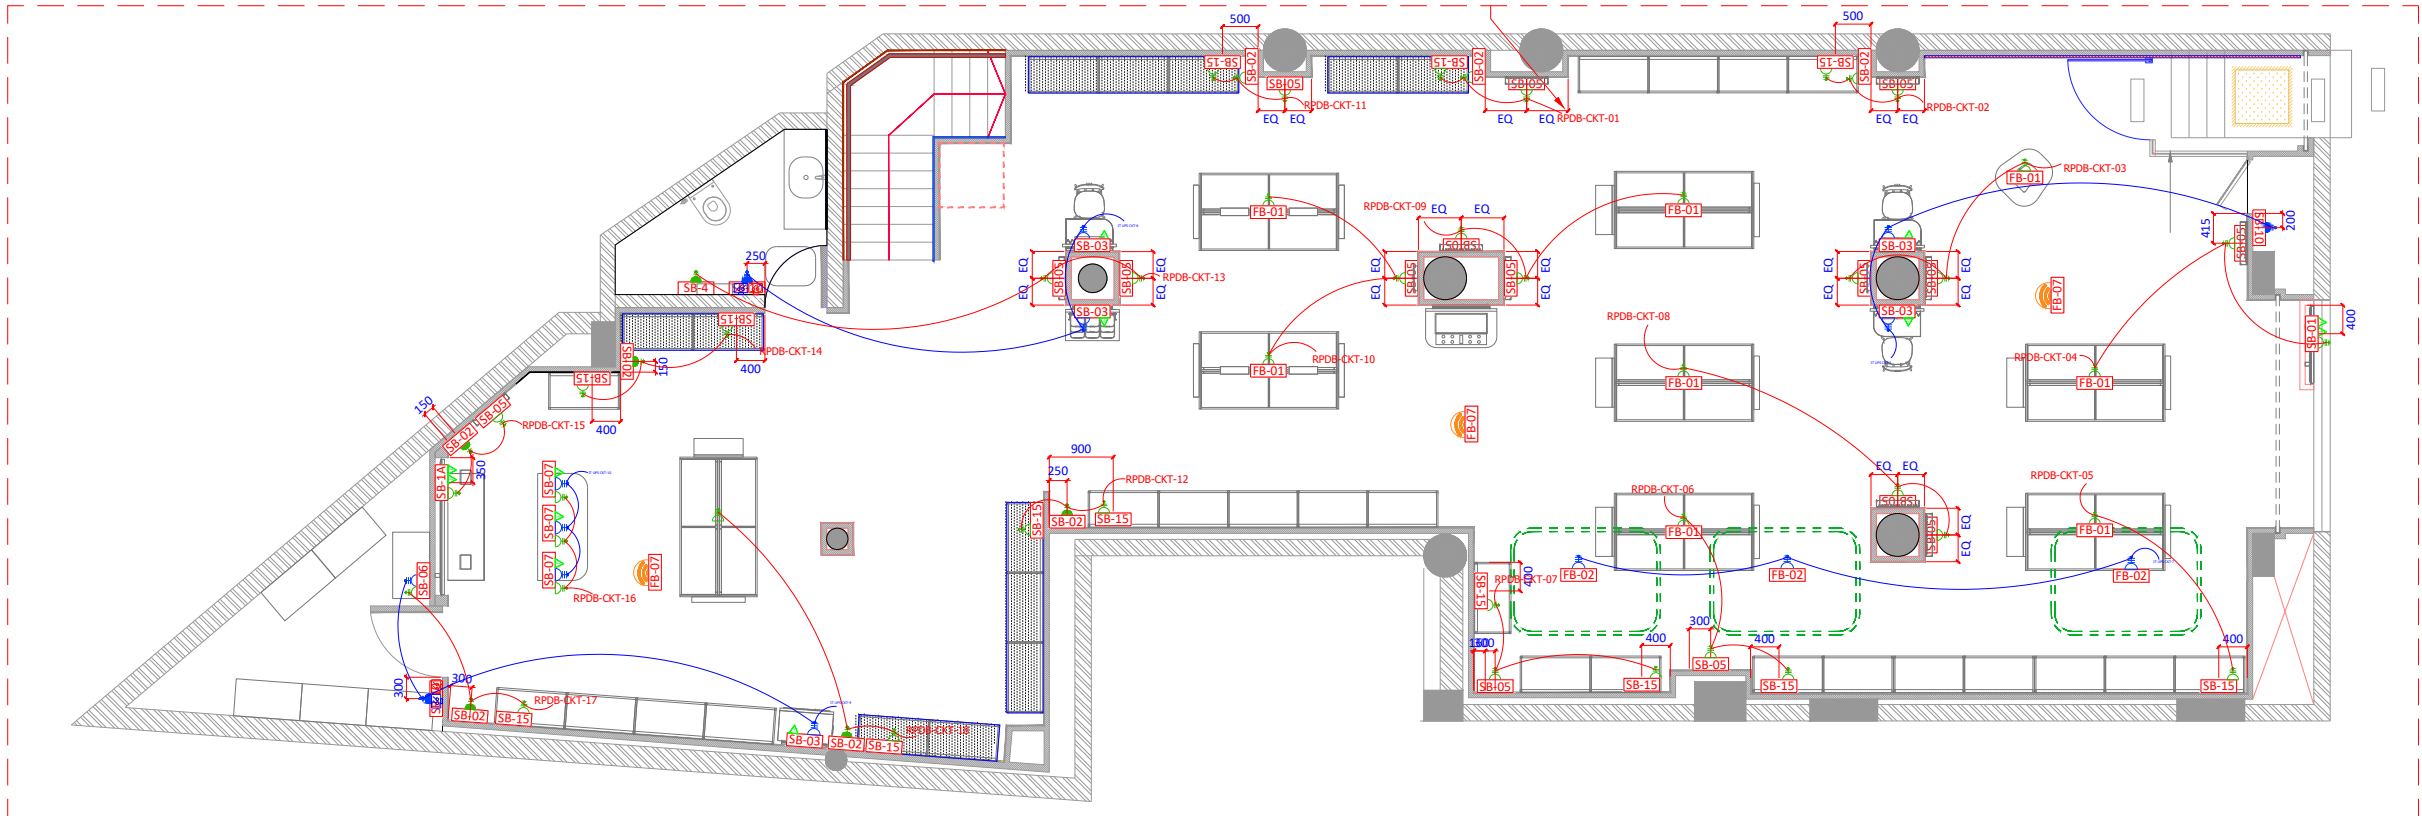

POWER SOCKET & DATA/VOICE LAYOUT

Scale: 1 : 75

SWITCH/SOCKET LEGEND


SWITCH BOARD NO	DESCRIPTION	SWITCH BOARD HT.	SWITCH BOARD NO	DESCRIPTION	SWITCH BOARD HT.
SB-01	• 3NOS 6AMP SOCKET WITH 1 NOS SWITCH ON RAW POWER • 1NOS 6AMP SOCKET WITH 1 NOS SWITCH ON UPS POWER • 1DATA POINT DIRECT FROM OFFICE ROUTER WITH RJ45 PATCH CORD • 1DATA POINT FOR SPARE	900MM FROM FFL	SB-11 SB-12	• 3NOS 6AMP SWITCH SOCKET WITH 1 NOS SWITCH FOR IT RACK • 2NOS 6AMP SWITCH SOCKET WITH 1 NOS SWITCH FOR IT RACK ON RAW POWER	1200MM FROM FFL
SB-1A	• 3NOS 6AMP SOCKET WITH 1 NOS SWITCH ON RAW POWER • 1NOS 6AMP SOCKET WITH 1 NOS SWITCH ON UPS POWER • 1DATA POINT DIRECT FROM OFFICE ROUTER WITH RJ45 PATCH CORD • 1DATA POINT FOR SPARE	1150MM FROM FFL	SB-13	• 2NOS 6AMP SWITCH SOCKET WITH 1 NOS SWITCH ON RAW POWER • 2NOS 6AMP SOCKET ON 1 SWITCH FROM ELDB FOR FIRE PANEL	1050MM FROM FFL
SB-02	• 1NOS 6AMP MULTISTANDARD SWITCH/SOCKET ON RAW POWER FOR UTILITY PURPOSE	150MM FROM FFL	SB-14	• 1NOS 6AMP SOCKET ON UPS POWER FOR BIOMETRIC • 1NOS DATA POINT BIOMETRIC	1100MM FROM FFL
SB-03	• 2NOS 6AMP SOCKET WITH 1 NOS SWITCH ON UPS POWER • 1NOS DATA POINT	150MM FROM FFL	SB-15	• 1NOS 6AMP SOCKET ON RAW POWER FOR WALL BAY UNIT • POINT FOR WALL BAY UNIT LIGHTING	150MM FROM FFL
SB-04	• 1NOS 6AMP MULTISTANDARD SWITCH/SOCKET ON RAW POWER FOR UTILITY PURPOSE	1050MM FROM FFL	SB-16	• 2NOS 6AMP MULTISTANDARD SWITCH/SOCKET ON RAW POWER FOR UTILITY PURPOSE	1050MM FROM FFL
SB-05	• POINT FOR WALL MIRROR/POSTER BOX @ 1200MM FROM FFL ON RAW POWER	1200MM FROM FFL	SB-16A	• 2NOS 6AMP MULTISTANDARD SWITCH/SOCKET ON RAW POWER FOR UTILITY PURPOSE	1050MM FROM FFL
SB-06	• 2NOS 6AMP SOCKET ON RAW POWER • 1NOS 6AMP SOCKET WITH 1 NOS SWITCH ON UPS POWER	950MM FROM FFL	SB-17	• 2NOS 6AMP MULTISTANDARD SWITCH/SOCKET ON RAW POWER FOR UTILITY PURPOSE	300MM FROM FFL
SB-07	• 3NOS 6AMP SWITCH SOCKET WITH 1 NOS SWITCH ON RAW POWER • 2NOS 6AMP SOCKET WITH 1 NOS SWITCH ON UPS POWER FOR IPAD • 1NOS DATA POINT	ON FLOOR FOR CASH COUNTER	SB-17A	• 2NOS 6AMP MULTISTANDARD SWITCH/SOCKET ON RAW POWER FOR UTILITY PURPOSE	300MM FROM FFL
SB-08	• 2NOS 6AMP SOCKET ON RAW POWER • 1NOS 6AMP SOCKET WITH 1 NOS SWITCH ON UPS POWER • 1NOS DATA POINT • 1NOS VOICE POINT	500MM FROM FFL			
SB-09	• 1NOS 6AMP MULTISTANDARD SWITCH/SOCKET ON UPS POWER • 1NOS SWITCH FOR SB-08 SOCKET	950MM FROM FFL			
SB-10	• 1NOS 6AMP MULTISTANDARD SWITCH/SOCKET ON RAW POWER FOR UTILITY PURPOSE	1050MM FROM FFL			

FLOOR BOX LEGEND

FLOOR BOX	DESCRIPTION	AREA
FB-01	• 2NOS 6AMP SOCKET WITH 1 NOS SWITCH ON RAW POWER • POINT FOR GONDOLA LIGHTING	BEAUTY/GENERIC GONDOLA
FB-02	• POINT FOR GONDOLA LIGHTING	QUEUE BARRIER
FB-03	• 2NOS 5/15 AMP SOCKET ON ONE SWITCH WITH RAW POWER • 2NOS DATA POINT	WIFI POINT ABOVE CEILING

TEXT COLOR CODE

TEXT COLOR	DATA POINT
TEXT COLOR	UPS POWER SUPPLY
TEXT COLOR	RAW POWER SUPPLY
TEXT COLOR	GONDOLA LIGHTING POINT
TEXT COLOR	VOICE POINT

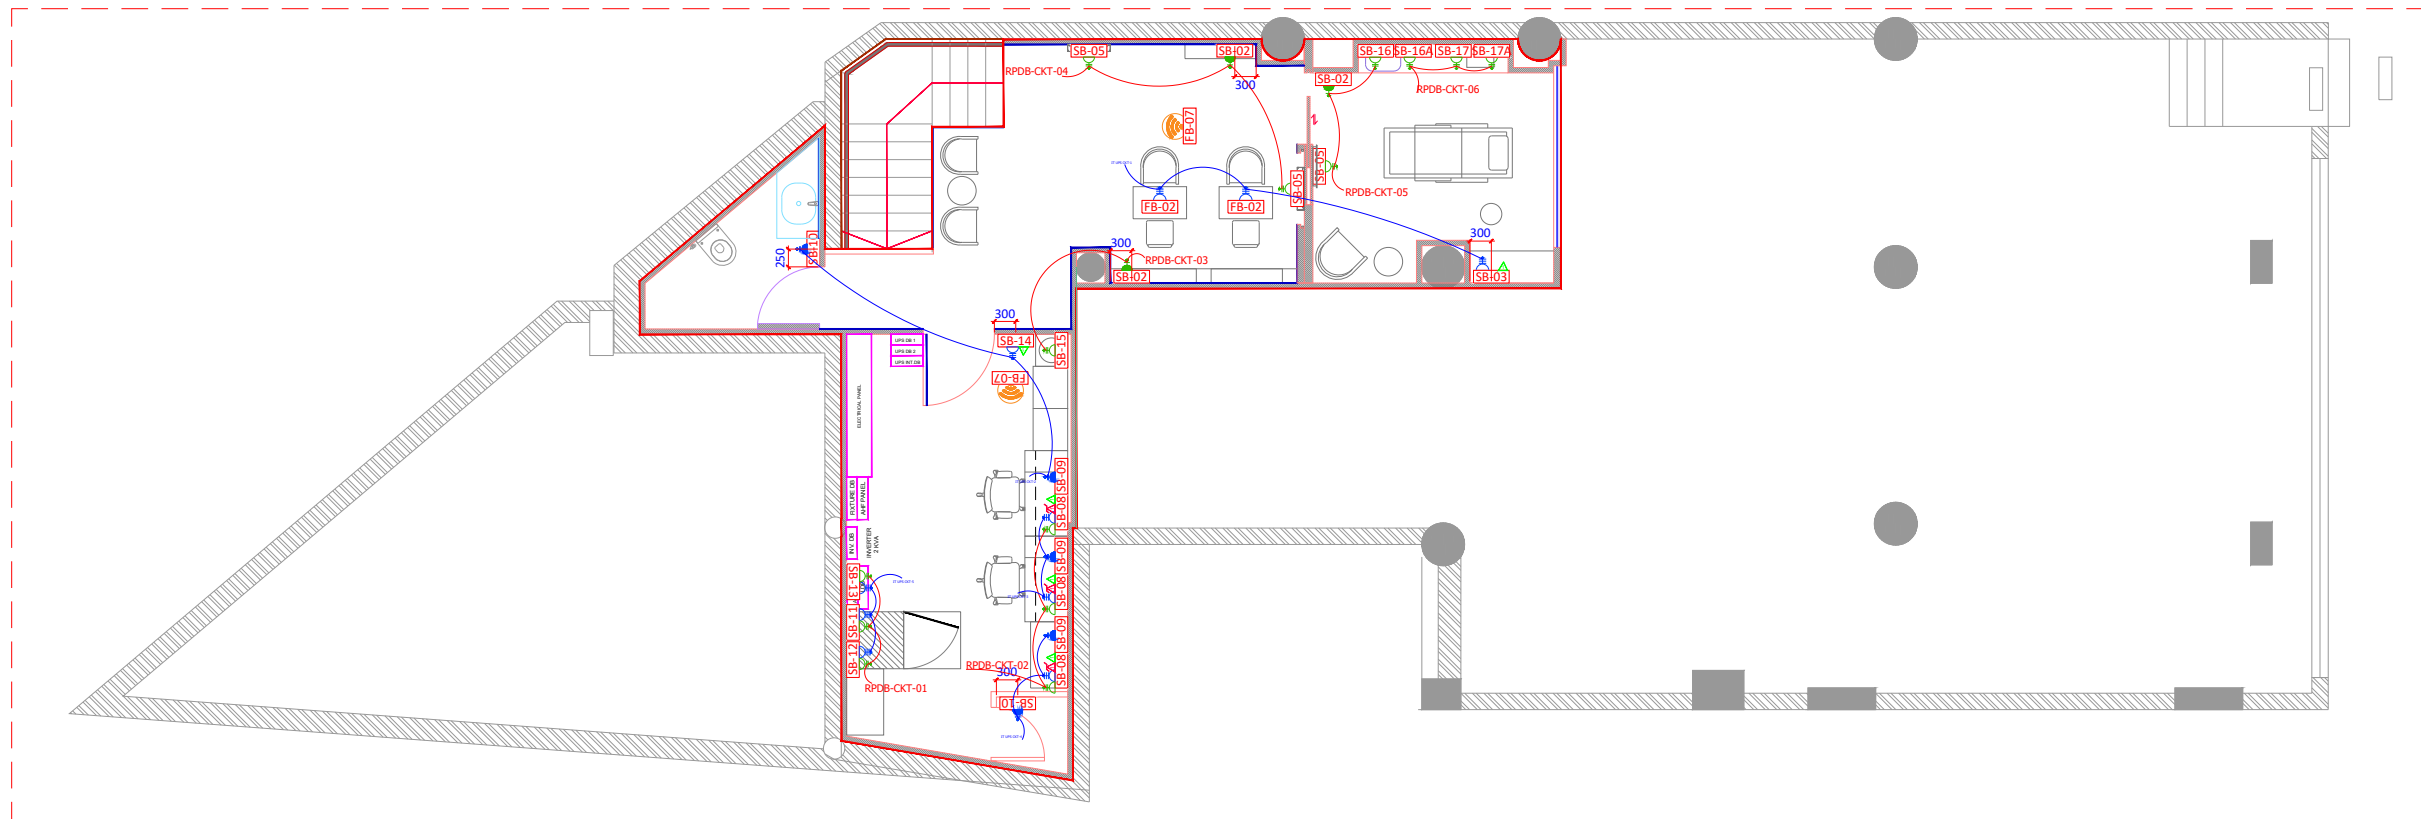

POWER SOCKET & DATA/VOICE LAYOUT
Scale: 1 : 75

SWITCH/SOCKET LEGEND						FLOOR BOX LEGEND		
SWITCH BOARD NO	DESCRIPTION	SWITCH BOARD HT.	SWITCH BOARD NO	DESCRIPTION	SWITCH BOARD HT.	FLOOR BOX	DESCRIPTION	AREA
SB-01	• 3NOS 6AMP SOCKET WITH 1 NOS SWITCH ON RAW POWER • 1NOS 6AMP SOCKET WITH 1 NOS SWITCH ON UPS POWER • 1DATA POINT DIRECT FROM OFFICE ROUTER WITH RJ45 PATCH CORD • 1DATA POINT FOR SPARE	900MM FROM FFL	SB-11 SB-12	• 3NOS 6AMP SWITCH SOCKET WITH 1 NOS SWITCH FOR IT RACK • 2NOS 6AMP SWITCH SOCKET WITH 1 NOS SWITCH FOR IT RACK • 2NOS 6AMP SWITCH SOCKET WITH 1 NOS SWITCH FOR IT RACK ON RAW POWER	1200MM FROM FFL	FB-01	• 2NOS 6AMP SOCKET WITH 1 NOS SWITCH ON RAW POWER • POINT FOR GONDOLA LIGHTING	BEAUTY/GENERIC GONDOLA
SB-1A	• 3NOS 6AMP SOCKET WITH 1 NOS SWITCH ON RAW POWER • 1NOS 6AMP SOCKET WITH 1 NOS SWITCH ON UPS POWER • 1DATA POINT DIRECT FROM OFFICE ROUTER WITH RJ45 PATCH CORD • 1DATA POINT FOR SPARE	1150MM FROM FFL		SB-13	• 2NOS 6AMP SWITCH SOCKET WITH 1 NOS SWITCH ON RAW POWER • 2NOS 6AMP SOCKET ON 1 SWITCH FROM ELDB FOR FIRE PANEL	1050MM FROM FFL	FB-02	• POINT FOR GONDOLA LIGHTING
SB-02	• 1NOS 6AMP MULTISTANDARD SWITCH/SOCKET ON RAW POWER FOR UTILITY PURPOSE	150MM FROM FFL	SB-14	• 1NOS 6AMP SOCKET ON UPS POWER FOR BIOMETRIC • 1NOS DATA POINT BIOMETRIC	1100MM FROM FFL	FB-03	• 2NOS 5/15 AMP SOCKET ON ONE SWITCH WITH RAW POWER • 2NOS DATA POINT	WIFI POINT ABOVE CEILING
SB-03	• 2NOS 6AMP SOCKET WITH 1 NOS SWITCH ON UPS POWER • 1NOS DATA POINT	150MM FROM FFL	SB-15	• 1NOS 6AMP SOCKET ON RAW POWER FOR WALL BAY UNIT • POINT FOR WALL BAY UNIT LIGHTING	150MM FROM FFL			
SB-04	• 1NOS 6AMP MULTISTANDARD SWITCH/SOCKET ON RAW POWER FOR UTILITY PURPOSE	1050MM FROM FFL	SB-16	• 2NOS 6AMP MULTISTANDARD SWITCH/SOCKET ON RAW POWER FOR UTILITY PURPOSE	1050MM FROM FFL			
SB-05	• POINT FOR WALL MIRROR/POSTER BOX @ 1200MM FROM FFL ON RAW POWER	1200MM FROM FFL	SB-16A	• 2NOS 6AMP MULTISTANDARD SWITCH/SOCKET ON RAW POWER FOR UTILITY PURPOSE	1050MM FROM FFL			
SB-06	• 2NOS 6AMP SOCKET ON RAW POWER • 1NOS 6AMP SOCKET WITH 1 NOS SWITCH ON UPS POWER	950MM FROM FFL	SB-17	• 2NOS 6AMP MULTISTANDARD SWITCH/SOCKET ON RAW POWER FOR UTILITY PURPOSE	300MM FROM FFL			
SB-07	• 3NOS 6AMP SWITCH SOCKET WITH 1 NOS SWITCH ON RAW POWER • 2NOS 6AMP SOCKET WITH 1 NOS SWITCH ON UPS POWER FOR IPAD • 1NOS DATA POINT	ON FLOOR FOR CASH COUNTER	SB-17A	• 2NOS 6AMP MULTISTANDARD SWITCH/SOCKET ON RAW POWER FOR UTILITY PURPOSE	300MM FROM FFL	TEXT COLOR CODE		
SB-08	• 2NOS 6AMP SOCKET ON RAW POWER • 1NOS 6AMP SOCKET WITH 1 NOS SWITCH ON UPS POWER • 1NOS DATA POINT • 1NOS VOICE POINT	500MM FROM FFL				TEXT COLOR	DATA POINT	
	SB-09	• 1NOS 6AMP MULTISTANDARD SWITCH/SOCKET ON UPS POWER • 1NOS SWITCH FOR SB-08 SOCKET				950MM FROM FFL	TEXT COLOR	UPS POWER SUPPLY
							TEXT COLOR	RAW POWER SUPPLY
SB-10	• 1NOS 6AMP MULTISTANDARD SWITCH/SOCKET ON RAW POWER FOR UTILITY PURPOSE	1050MM FROM FFL	TEXT COLOR	GONDOLA LIGHTING POINT				
						TEXT COLOR	VOICE POINT	

NOTES:
1. THESE DRAWINGS AND SPECIFICATIONS ARE
2. CONFIDENTIAL AND SHALL REMAIN THE SOLE
3. PROPERTY OF H2O ARCHITECTS, APPOINTED CONSULTANT FOR
THE PROJECT BY RELIANCE.
4. THEY SHALL NOT BE REPRODUCED (IN WHOLE OR IN PART),
SHARED WITH THIRD PARTIES OR USED IN ANY MANNER ON
OTHER PROJECTS OR EXTENSIONS TO THIS PROJECT WITHOUT THE
PRIOR WRITTEN CONSENT OF H2O ARCHITECTS.
5. THESE DRAWINGS AND SPECIFICATIONS ARE INTENDED TO
EXECUTE THE CONCEPT DESIGN RECEIVED FROM THE BRAND.
6. ALL DIMENSION ARE IN MM. UNLESS OTHERWISE MENTIONED.
7. WRITTEN DIMENSION ARE TO BE FOLLOWED. DRAWING NOT TO BE
SCALED.
8. CONTRACTOR SHOULD VERIFY THE DRAWINGS IN FIELD BEFORE
COMMENCEMENT OF THE WORK AND IN CASE OF ANY
DISCREPANCY CONTACT SITE INCHARGE PRIOR TO THE
EXECUTION.

STORE AREA
292.88 SQ.MT
2853.83 SQ.FT

SURVEYED DRAWING	
DRAWING FOR INFORMATION	
DRAWINGS FOR APPROVALS	
DRAWINGS FOR TENDER	
GFC DRAWINGS	✓
ASBUILT DRAWINGS	

DRAWING TITLE
POWER SOCKET &
DATA/VOICE LAYOUT

SHEET SIZE - A2(594MM X 420MM)

SCALE: 1:75


DRAWING BY
JAYESH

CHECKED BY
POOJA

DRAWING NO

MEP06

REV NO	DATE	REMARKS
R0	23-05-23	
R1	23-06-23	INTERIOR & MEP LAYOUT REVISED
R2	03-07-23	C&I COMMENT INCORPORATE
R3	01-09-23	REVISED SDR & ML

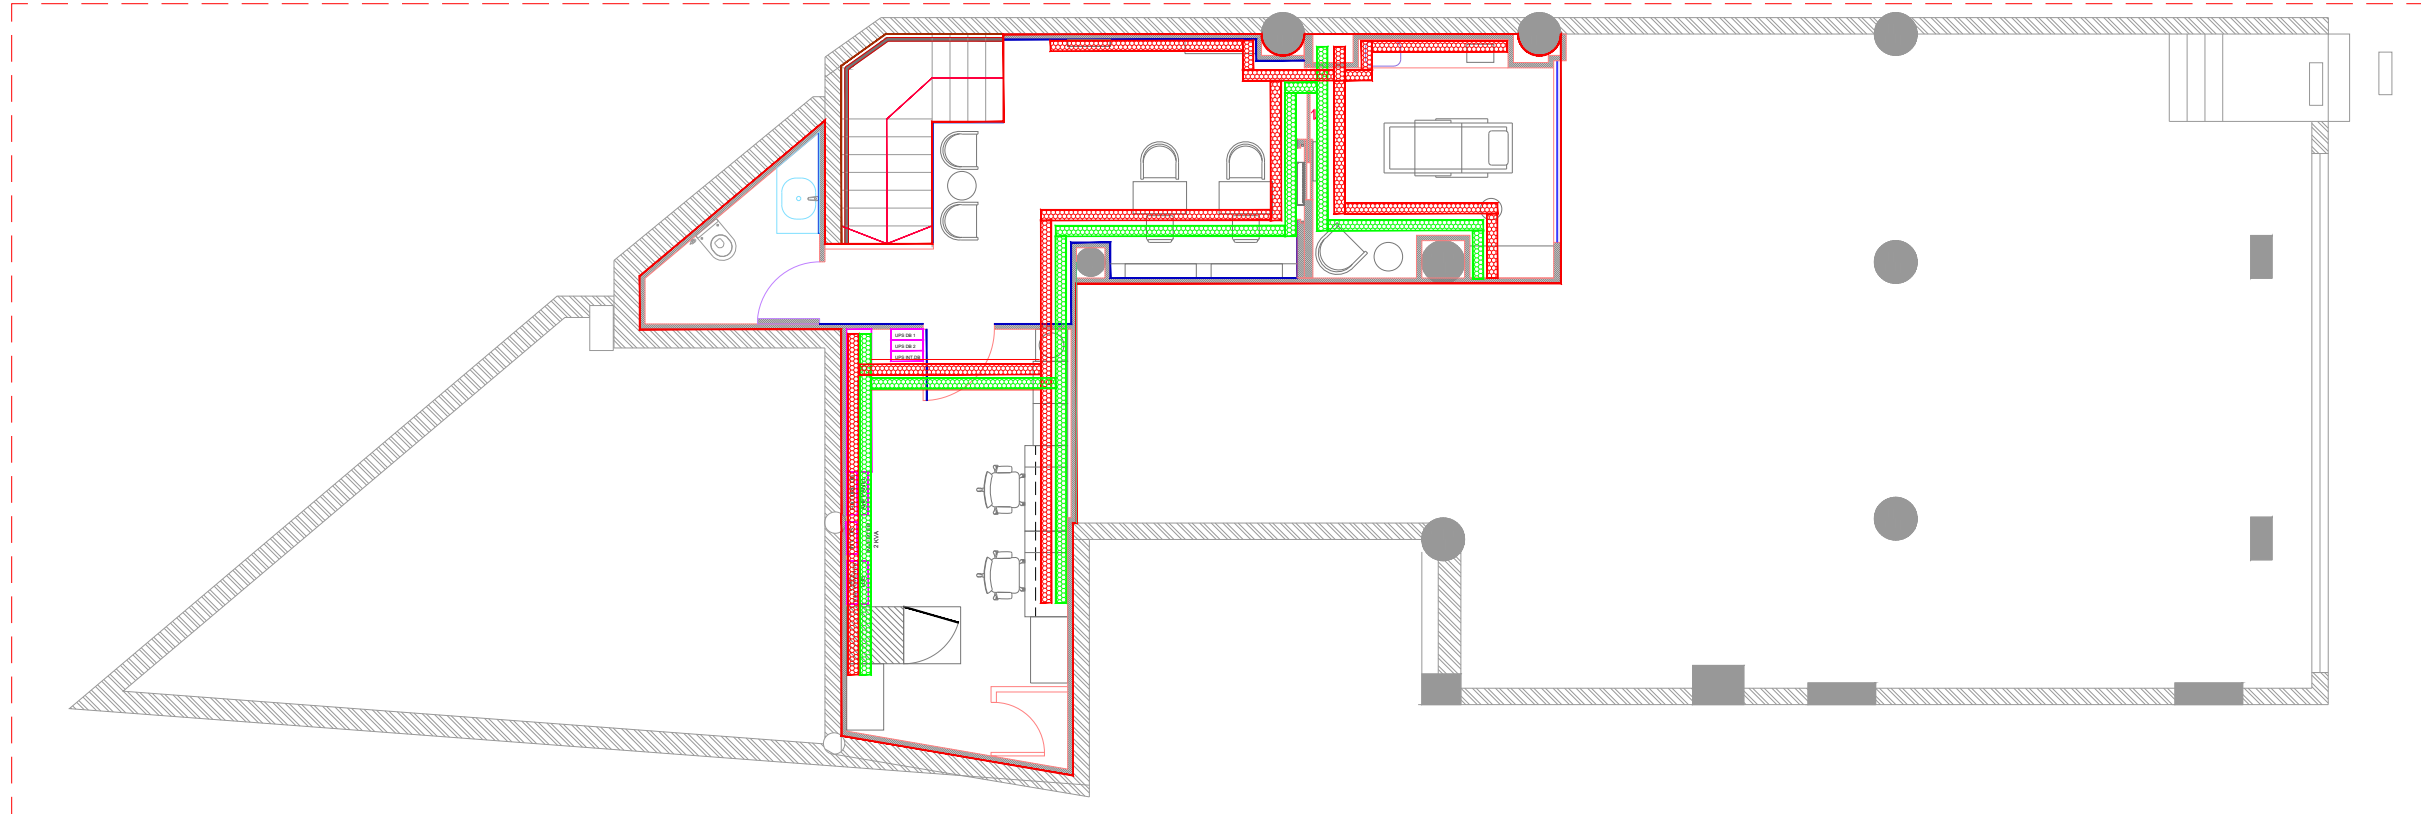

POWER SOCKET & DATA/VOICE LAYOUT
Scale: 1 : 75

SWITCH/SOCKET LEGEND						FLOOR BOX LEGEND		
SWITCH BOARD NO	DESCRIPTION	SWITCH BOARD HT.	SWITCH BOARD NO	DESCRIPTION	SWITCH BOARD HT.	FLOOR BOX	DESCRIPTION	AREA
SB-01	• 3NOS 6AMP SOCKET WITH 1 NOS SWITCH ON RAW POWER • 1NOS 6AMP SOCKET WITH 1 NOS SWITCH ON UPS POWER • 1DATA POINT DIRECT FROM OFFICE ROUTER WITH RJ45 PATCH CORD • 1DATA POINT FOR SPARE	900MM FROM FFL	SB-11 SB-12	• 3NOS 6AMP SWITCH SOCKET WITH 1 NOS SWITCH FOR IT RACK • 2NOS 6AMP SWITCH SOCKET WITH 1 NOS SWITCH FOR IT RACK • 2NOS 6AMP SWITCH SOCKET WITH 1 NOS SWITCH FOR IT RACK ON RAW POWER	1200MM FROM FFL	FB-01	• 2NOS 6AMP SOCKET WITH 1 NOS SWITCH ON RAW POWER • POINT FOR GONDOLA LIGHTING	BEAUTY/GENERIC GONDOLA
SB-1A	• 3NOS 6AMP SOCKET WITH 1 NOS SWITCH ON RAW POWER • 1NOS 6AMP SOCKET WITH 1 NOS SWITCH ON UPS POWER • 1DATA POINT DIRECT FROM OFFICE ROUTER WITH RJ45 PATCH CORD • 1DATA POINT FOR SPARE	1150MM FROM FFL		SB-13	• 2NOS 6AMP SWITCH SOCKET WITH 1 NOS SWITCH ON RAW POWER • 2NOS 6AMP SOCKET ON 1 SWITCH FROM ELDB FOR FIRE PANEL	1050MM FROM FFL	FB-02	• POINT FOR GONDOLA LIGHTING
SB-02	• 1NOS 6AMP MULTISTANDARD SWITCH/SOCKET ON RAW POWER FOR UTILITY PURPOSE	150MM FROM FFL	SB-14	• 1NOS 6AMP SOCKET ON UPS POWER FOR BIOMETRIC • 1NOS DATA POINT BIOMETRIC	1100MM FROM FFL	FB-03	• 2NOS 5/15 AMP SOCKET ON ONE SWITCH WITH RAW POWER • 2NOS DATA POINT	WIFI POINT ABOVE CEILING
SB-03	• 2NOS 6AMP SOCKET WITH 1 NOS SWITCH ON UPS POWER • 1NOS DATA POINT	150MM FROM FFL	SB-15	• 1NOS 6AMP SOCKET ON RAW POWER FOR WALL BAY UNIT • POINT FOR WALL BAY UNIT LIGHTING	150MM FROM FFL			
SB-04	• 1NOS 6AMP MULTISTANDARD SWITCH/SOCKET ON RAW POWER FOR UTILITY PURPOSE	1050MM FROM FFL	SB-16	• 2NOS 6AMP MULTISTANDARD SWITCH/SOCKET ON RAW POWER FOR UTILITY PURPOSE	1050MM FROM FFL			
SB-05	• POINT FOR WALL MIRROR/POSTER BOX @ 1200MM FROM FFL ON RAW POWER	1200MM FROM FFL	SB-16A	• 2NOS 6AMP MULTISTANDARD SWITCH/SOCKET ON RAW POWER FOR UTILITY PURPOSE	1050MM FROM FFL			
SB-06	• 2NOS 6AMP SOCKET ON RAW POWER • 1NOS 6AMP SOCKET WITH 1 NOS SWITCH ON UPS POWER	950MM FROM FFL	SB-17	• 2NOS 6AMP MULTISTANDARD SWITCH/SOCKET ON RAW POWER FOR UTILITY PURPOSE	300MM FROM FFL			
SB-07	• 3NOS 6AMP SWITCH SOCKET WITH 1 NOS SWITCH ON RAW POWER • 2NOS 6AMP SOCKET WITH 1 NOS SWITCH ON UPS POWER FOR IPAD • 1NOS DATA POINT	ON FLOOR FOR CASH COUNTER	SB-17A	• 2NOS 6AMP MULTISTANDARD SWITCH/SOCKET ON RAW POWER FOR UTILITY PURPOSE	300MM FROM FFL			
SB-08	• 2NOS 6AMP SOCKET ON RAW POWER • 1NOS 6AMP SOCKET WITH 1 NOS SWITCH ON UPS POWER • 1NOS DATA POINT • 1NOS VOICE POINT	500MM FROM FFL						
SB-09	• 1NOS 6AMP MULTISTANDARD SWITCH/SOCKET ON UPS POWER • 1NOS SWITCH FOR SB-08 SOCKET	950MM FROM FFL						
SB-10	• 1NOS 6AMP MULTISTANDARD SWITCH/SOCKET ON RAW POWER FOR UTILITY PURPOSE	1050MM FROM FFL						

TEXT COLOR CODE	
TEXT COLOR	DATA POINT
TEXT COLOR	UPS POWER SUPPLY
TEXT COLOR	RAW POWER SUPPLY
TEXT COLOR	GONDOLA LIGHTING POINT
TEXT COLOR	VOICE POINT

- NOTES:
- THESE DRAWINGS AND SPECIFICATIONS ARE
 - CONFIDENTIAL AND SHALL REMAIN THE SOLE
 - PROPERTY OF H2O ARCHITECTS, APPOINTED CONSULTANT FOR THE PROJECT BY RELIANCE.
 - THEY SHALL NOT BE REPRODUCED (IN WHOLE OR IN PART), SHARED WITH THIRD PARTIES OR USED IN ANY MANNER ON OTHER PROJECTS OR EXTENSIONS TO THIS PROJECT WITHOUT THE PRIOR WRITTEN CONSENT OF H2O ARCHITECTS.
 - THESE DRAWINGS AND SPECIFICATIONS ARE INTENDED TO EXECUTE THE CONCEPT DESIGN RECEIVED FROM THE BRAND.
 - ALL DIMENSION ARE IN MM. UNLESS OTHERWISE MENTIONED.
 - WRITTEN DIMENSION ARE TO BE FOLLOWED. DRAWING NOT TO BE SCALED.
 - CONTRACTOR SHOULD VERIFY THE DRAWINGS IN FIELD BEFORE COMMENCEMENT OF THE WORK AND IN CASE OF ANY DISCREPANCY CONTACT SITE INCHARGE PRIOR TO THE EXECUTION.

STORE AREA
292.88 SQ.MT
2853.83 SQ.FT

SURVEYED DRAWING	
DRAWING FOR INFORMATION	
DRAWINGS FOR APPROVALS	
DRAWINGS FOR TENDER	
GFC DRAWINGS	✓
ASBUILT DRAWINGS	

DRAWING TITLE
**POWER SOCKET &
DATA/VOICE LAYOUT**

SHEET SIZE - A2(594MM X 420MM)


SCALE: 1:75

DRAWING BY
JAYESH

CHECKED BY
POOJA

DRAWING NO
MEP06

REV NO	DATE	REMARKS
R0	23-05-23	
R1	23-06-23	INTERIOR & MEP LAYOUT REVISED
R2	03-07-23	C&I COMMENT INCORPORATE
R3	01-09-23	REVISED SDR & ML

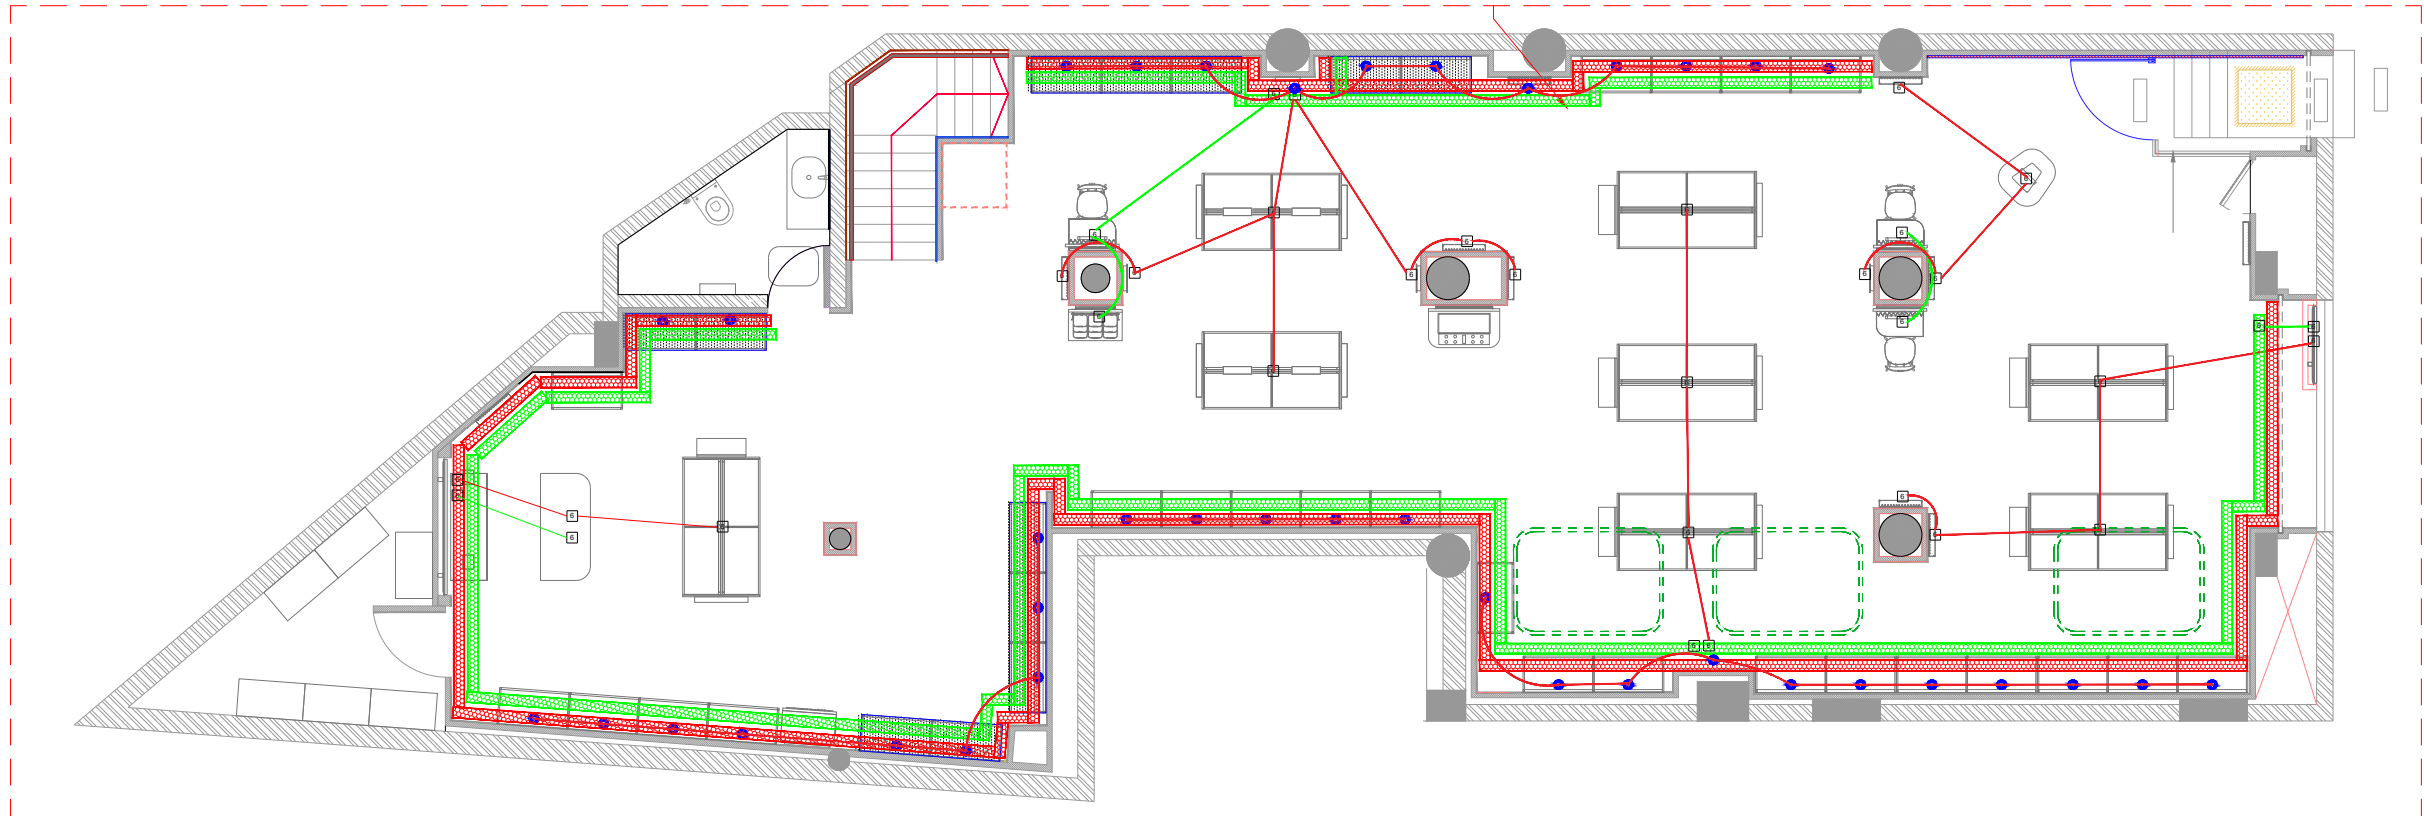

POWER SOCKET & DATA/VOICE LAYOUT
Scale: 1 : 75

SWITCH/SOCKET LEGEND				
SWITCH BOARD NO	DESCRIPTION	SWITCH BOARD HT.	SWITCH BOARD NO	DESCRIPTION
SB-01	• 3NOS 6AMP SOCKET WITH 1 NOS SWITCH ON RAW POWER • 1NOS 6AMP SOCKET WITH 1 NOS SWITCH ON UPS POWER • 1DATA POINT DIRECT FROM OFFICE ROUTER WITH RJ45 PATCH CORD • 1DATA POINT FOR SPARE	900MM FROM FFL	SB-11	• 3NOS 6AMP SWITCH SOCKET WITH 1 NOS SWITCH FOR IT RACK • 2NOS 6AMP SWITCH SOCKET WITH 1 NOS SWITCH FOR IT RACK ON RAW POWER
			SB-12	
SB-1A	• 3NOS 6AMP SOCKET WITH 1 NOS SWITCH ON RAW POWER • 1NOS 6AMP SOCKET WITH 1 NOS SWITCH ON UPS POWER • 1DATA POINT DIRECT FROM OFFICE ROUTER WITH RJ45 PATCH CORD • 1DATA POINT FOR SPARE	1150MM FROM FFL	SB-13	• 2NOS 6AMP SWITCH SOCKET WITH 1 NOS SWITCH ON RAW POWER • 2NOS 6AMP SOCKET ON 1 SWITCH FROM ELDB FOR FIRE PANEL
SB-02	• 1NOS 6AMP MULTISTANDARD SWITCH/SOCKET ON RAW POWER FOR UTILITY PURPOSE	150MM FROM FFL	SB-14	• 1NOS 6AMP SOCKET ON UPS POWER FOR BIOMETRIC • 1NOS DATA POINT BIOMETRIC
SB-03	• 2NOS 6AMP SOCKET WITH 1 NOS SWITCH ON UPS POWER • 1NOS DATA POINT	150MM FROM FFL	SB-15	• 1NOS 6AMP SOCKET ON RAW POWER FOR WALL BAY UNIT • POINT FOR WALL BAY UNIT LIGHTING
SB-04	• 1NOS 6AMP MULTISTANDARD SWITCH/SOCKET ON RAW POWER FOR UTILITY PURPOSE	1050MM FROM FFL	SB-16	• 2NOS 6AMP MULTISTANDARD SWITCH/SOCKET ON RAW POWER FOR UTILITY PURPOSE
SB-05	• POINT FOR WALL MIRROR/POSTER BOX @ 1200MM FROM FFL ON RAW POWER	1200MM FROM FFL	SB-16A	• 2NOS 6AMP MULTISTANDARD SWITCH/SOCKET ON RAW POWER FOR UTILITY PURPOSE
SB-06	• 2NOS 6AMP SOCKET ON RAW POWER • 1NOS 6AMP SOCKET WITH 1 NOS SWITCH ON UPS POWER	950MM FROM FFL	SB-17	• 2NOS 6AMP MULTISTANDARD SWITCH/SOCKET ON RAW POWER FOR UTILITY PURPOSE
			SB-17A	• 2NOS 6AMP MULTISTANDARD SWITCH/SOCKET ON RAW POWER FOR UTILITY PURPOSE
SB-07	• 3NOS 6AMP SWITCH SOCKET WITH 1 NOS SWITCH ON RAW POWER • 2NOS 6AMP SOCKET WITH 1 NOS SWITCH ON UPS POWER FOR IPAD • 1NOS DATA POINT	ON FLOOR FOR CASH COUNTER		
SB-08	• 2NOS 6AMP SOCKET ON RAW POWER • 1NOS 6AMP SOCKET WITH 1 NOS SWITCH ON UPS POWER • 1NOS DATA POINT • 1NOS VOICE POINT	500MM FROM FFL		
SB-09	• 1NOS 6AMP MULTISTANDARD SWITCH/SOCKET ON UPS POWER • 1NOS SWITCH FOR SB-08 SOCKET	950MM FROM FFL		
SB-10	• 1NOS 6AMP MULTISTANDARD SWITCH/SOCKET ON RAW POWER FOR UTILITY PURPOSE	1050MM FROM FFL		

FLOOR BOX LEGEND		
FLOOR BOX	DESCRIPTION	AREA
FB-01	• 2NOS 6AMP SOCKET WITH 1 NOS SWITCH ON RAW POWER • POINT FOR GONDOLA LIGHTING	BEAUTY/GENERIC GONDOLA
FB-02	• POINT FOR GONDOLA LIGHTING	QUEUE BARRIER
FB-03	• 2NOS 5/15 AMP SOCKET ON ONE SWITCH WITH RAW POWER • 2NOS DATA POINT	WIFI POINT ABOVE CEILING

TEXT COLOR CODE	
TEXT COLOR	DATA POINT
TEXT COLOR	UPS POWER SUPPLY
TEXT COLOR	RAW POWER SUPPLY
TEXT COLOR	GONDOLA LIGHTING POINT
TEXT COLOR	VOICE POINT

- NOTES:
- THESE DRAWINGS AND SPECIFICATIONS ARE
 - CONFIDENTIAL AND SHALL REMAIN THE SOLE
 - PROPERTY OF H2O ARCHITECTS, APPOINTED CONSULTANT FOR THE PROJECT BY RELIANCE.
 - THEY SHALL NOT BE REPRODUCED (IN WHOLE OR IN PART), SHARED WITH THIRD PARTIES OR USED IN ANY MANNER ON OTHER PROJECTS OR EXTENSIONS TO THIS PROJECT WITHOUT THE PRIOR WRITTEN CONSENT OF H2O ARCHITECTS.
 - THESE DRAWINGS AND SPECIFICATIONS ARE INTENDED TO EXECUTE THE CONCEPT DESIGN RECEIVED FROM THE BRAND.
 - ALL DIMENSION ARE IN MM. UNLESS OTHERWISE MENTIONED.
 - WRITTEN DIMENSION ARE TO BE FOLLOWED. DRAWING NOT TO BE SCALED.
 - CONTRACTOR SHOULD VERIFY THE DRAWINGS IN FIELD BEFORE COMMENCEMENT OF THE WORK AND IN CASE OF ANY DISCREPANCY CONTACT SITE INCHARGE PRIOR TO THE EXECUTION.

STORE AREA
292.88 SQ.MT
2853.83 SQ.FT

SURVEYED DRAWING	
DRAWING FOR INFORMATION	
DRAWINGS FOR APPROVALS	
DRAWINGS FOR TENDER	
GFC DRAWINGS	✓
ASBUILT DRAWINGS	

DRAWING TITLE
**POWER SOCKET &
DATA/VOICE LAYOUT**

SHEET SIZE - A2(594MM X 420MM)

SCALE: 1:75

DRAWING BY
JAYESH

CHECKED BY
POOJA

DRAWING NO

MEP06

REV NO	DATE	REMARKS
R0	23-05-23	
R1	23-06-23	INTERIOR & MEP LAYOUT REVISED
R2	03-07-23	C&I COMMENT INCORPORATE
R3	01-09-23	REVISED SDR & ML

FIRST FLOOR

The floor plan shows a complex layout with various rooms and corridors. The layout is defined by red and blue lines, with various rooms and corridors labeled. The plan also shows a large open area on the right side, possibly a parking lot or a large hall. The overall shape is irregular, with a large triangular section on the left and a long, narrow section on the right.

GROUND FLOOR

2100 X 1500 CANDY
PROFILE LIGHT AS PER @
2800MM FROM RFL

SS 1
75.50 FT

SS 2
60.50 FT

SS 3
75.50 FT

Scale: 1 : 75

SYMBOL	DESCRIPTION	QUANTITY
	SMOKE DETECTORS AT FALSE CEILING LEVEL.	14
	SMOKE DETECTOR ABOVE FALSE CEILING WITH RI AT FALSE CEILING LVL.	06
	HOOTER WITH FLASHER	02
	MANUAL CALL POINT	02
	FAS CIRCUIT 2.5 SQ MM CABLE XXXXXX	00

REV NO	DATE	REMARKS
R0	19-12-24	