


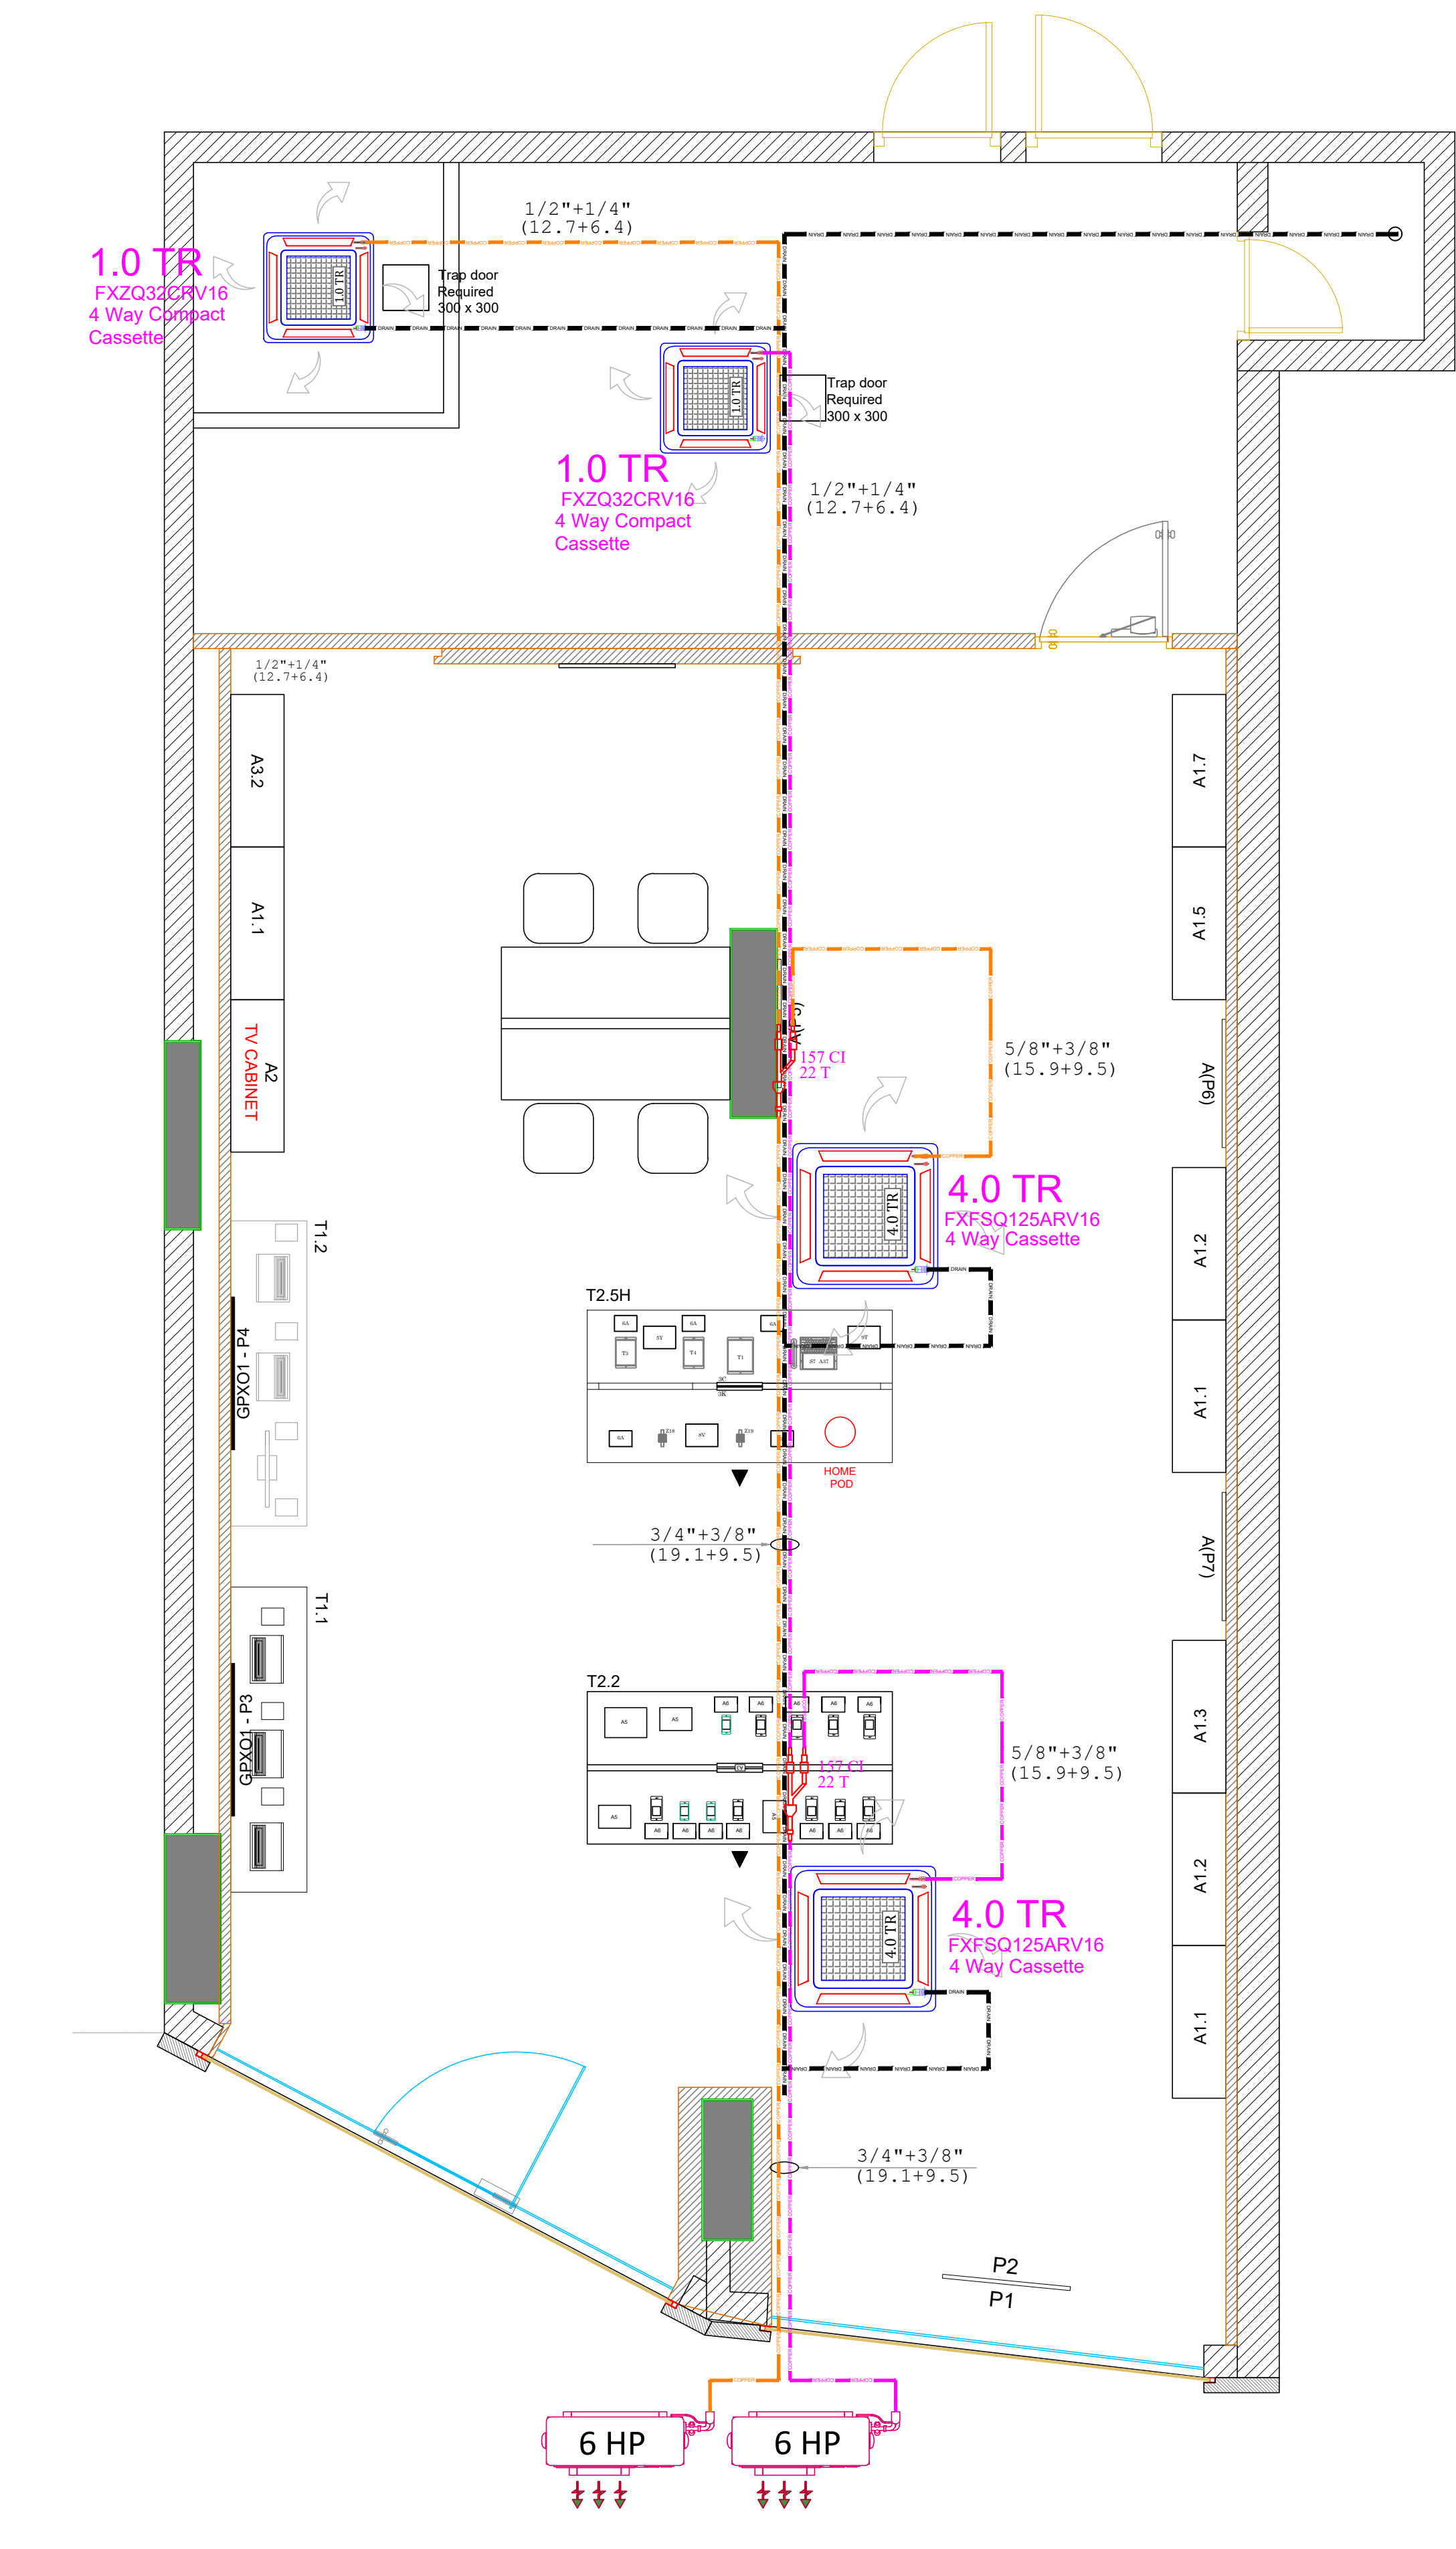

REVISIONS		
REV.	DATE	DESCRIPTION
R0	16.04.2026	Issued For Approval
R1	29.04.2026	As Built Dwg

CLIENT NAME :-
I Planet Store
SITE ADDRESS :-
Irla, Ville Parle



AEON Airconditioning Solutions.
Complete Airconditioning Solutions.
Office No. 108 & 109, Devashree Garden
Commercial Complex, R.W. Sawant Marg, Above
Sheetal Dairy, Rutu Park, Thane - 4000601,
Maharashtra.
E- asim.shaikh@aeonacsolutions.com
Phone - 9322334106 / 9322334108

TITLE:			
HVAC Layout I-Planet Vile Parle			
DRAWN	ZIYAN.M		
CHECKED			
SCALE	NTS		
DATE	29-04-2026		
PAPER SIZE	A3	DRAWING NO.	01