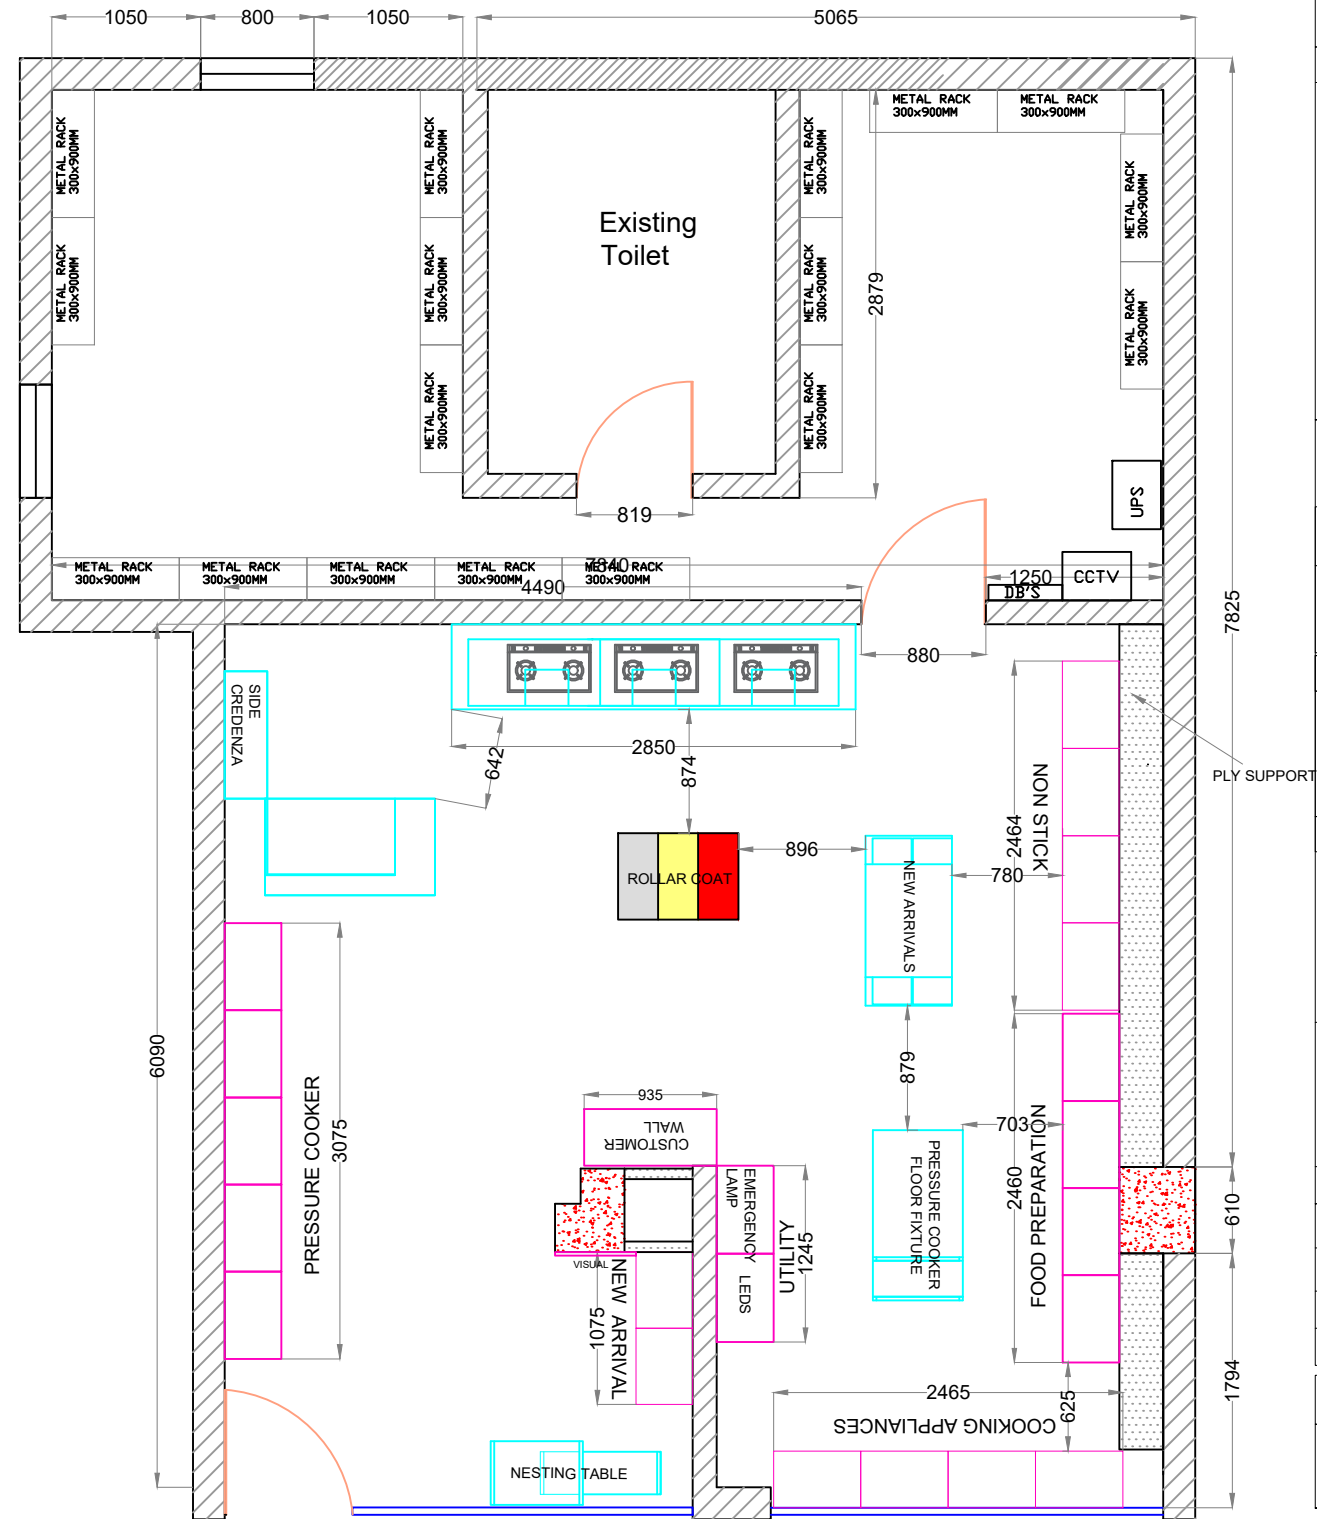


GENERAL NOTES :

1. ALL DIMENSIONS ARE MILLIMETER, UNLESS MENTIONED OTHERWISE.
2. ALL DIMENSIONS TO BE CHECKED AND VERIFIED ON SITE BY CONTRACTORS PRIOR TO COMMENCEMENT OF WORK.
3. ANY DISCREPANCIES TO BE CLARIFIED IMMEDIATELY, AND CHANGES REQUIRED SHALL BE CONFIRMED FROM THE ARCHITECT.
4. WRITTEN DIMENSIONS SHOULD BE FOLLOWED.
5. THIS DRAWING SHALL BE READ IN CONJUNCTION WITH OTHER PERTINENT.

PIGEON

PROJECT :

STORE NAME : MEM NAGAR
STORE CODE :

DWG TITLE :

FURNITURE LAYOUT

NOTES:

AREA STATEMENT

RETAIL AREA : 442 SQFT
BOH & Toilet AREA : 303 SQFT
TOTAL AREA : 745 SQFT

TOTAL HIGHT : 3110 MM

FFL TO BEAM HIGHT : 2700 MM

FALSE CEILING HIGHT @ FFL

DRAWN BY : POOJASHREE PS

CHECKED BY : Mr: PRASHANTH

APPROVED BY : Mr:MAYANK

SCALE: NTS


DATE: 20.01.2025

DWG NUMBER	REVISION
P1	R1


A-1.1

FURNITURE LAYOUT

SCALE: NTS

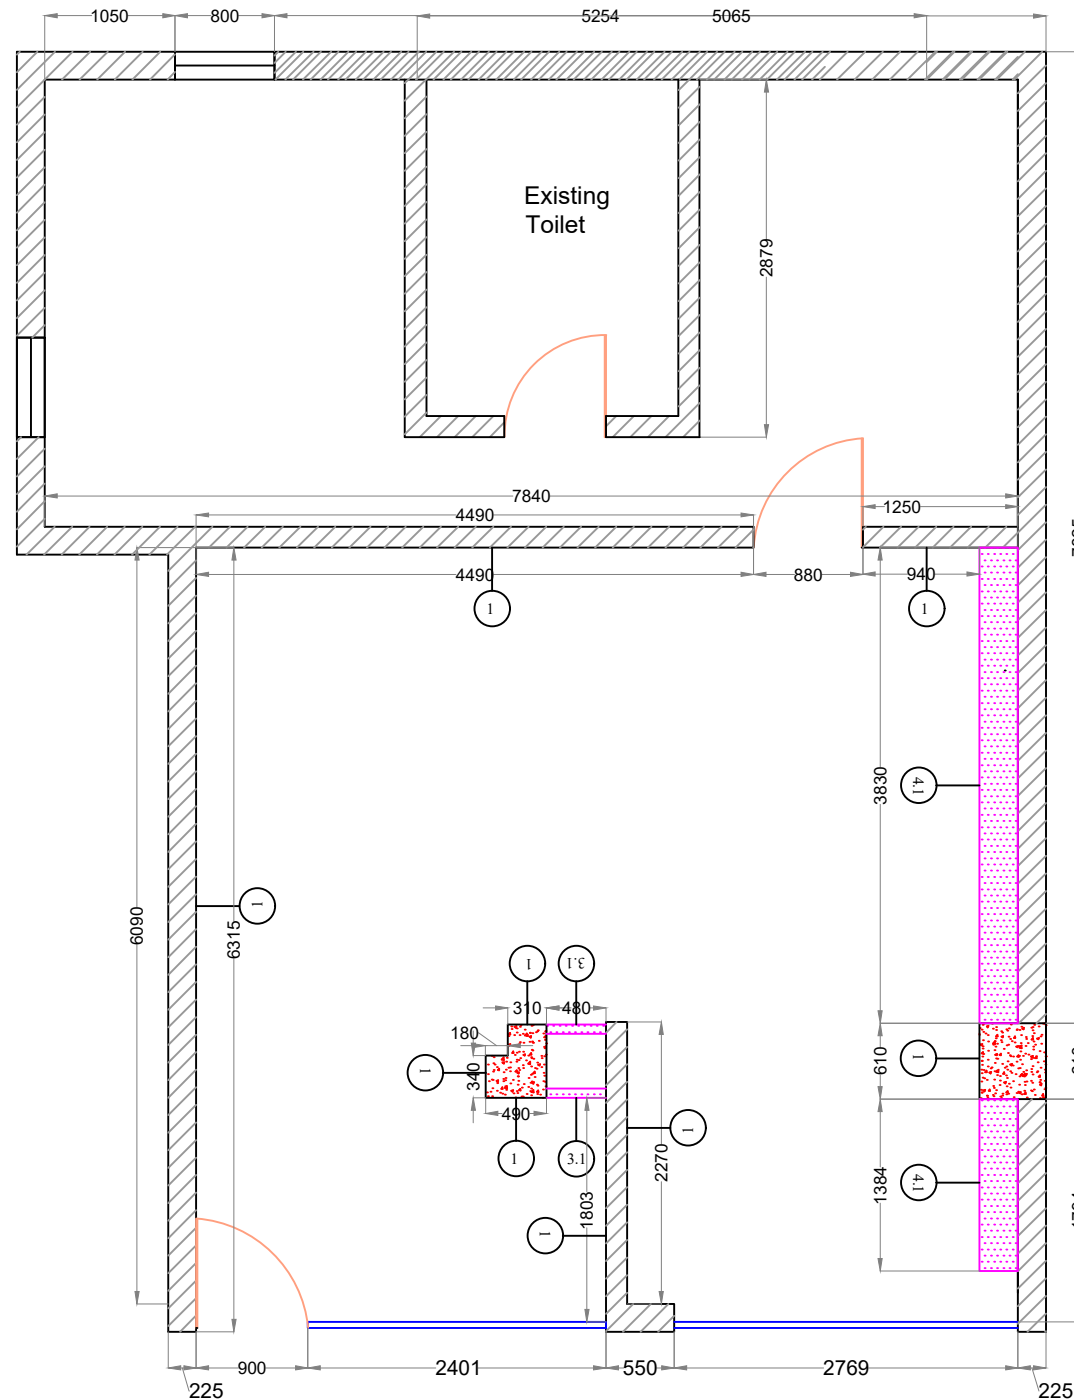

A-1.1 PARTITION LAYOUT
SCALE: NTS

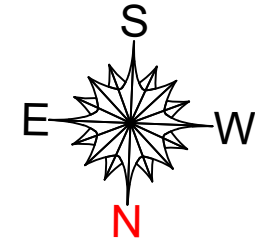

GENERAL NOTES :

1. ALL DIMENSIONS ARE MILLIMETER, UNLESS MENTIONED OTHERWISE.
2. ALL DIMENSIONS TO BE CHECKED AND VERIFIED ON SITE BY CONTRACTORS PRIOR TO COMMENCEMENT OF WORK.
3. ANY DISCREPANCIES TO BE CLARIFIED IMMEDIATELY, AND CHANGES REQUIRED SHALL BE CONFIRMED FROM THE ARCHITECT.
4. WRITTEN DIMENSIONS SHOULD BE FOLLOWED.
5. THIS DRAWING SHALL BE READ IN CONJUNCTION WITH OTHER PERTINENT.

PIGEON

PROJECT :

STORE NAME : MEM NAGAR
STORE CODE :

DWG TITLE :

PARTITION LAYOUT

NOTES:

AREA STATEMENT

RETAIL AREA : 442 SQFT
BOH & Toilet AREA : 303 SQFT
TOTAL AREA : 745 SQFT

TOTAL HIGHT : 3110 MM

FFL TO BEAM HIGHT : 2700 MM

FALSE CEILING HIGHT @ FFL

DRAWN BY : POOJASHREE PS


CHECKED BY : Mr. PRASHANTH

APPROVED BY : Mr.MAYANK


SCALE: NTS

DATE: 20.01.2025

DWG NUMBER	REVISION
P2	R1
1 WALL PUTTY TO LEVEL THE EXISTING WALL AND RECIEVE PAINT	1
2 1.5" X 2" G.I FRAMEWORK + GYP 12MM THK TO RECEIVE PAINT	2
3 1.5" X 2" G.I FRAMEWORK + FULL PLY 12MM THK + GYP 12MM THK TO RECEIVE PAINT	3
3.1 1.5" X 2" G.I FRAMEWORK +12MM THK THICK PLY PATTI+ GYP 12MM THK TO RECEIVE PAINT	3.1
4 STOREFRONT SIGNAGE BAND W APPROVED ALUDECOR SH1201 (GLOSSY PURE WHITE)	4
4.1 1.5" X 2" G.I FRAMEWORK + PLY 12MM THK, 200MMHT PLY SUPPORT FOR FIXTURE TO RECEIVE PAINT	4.1

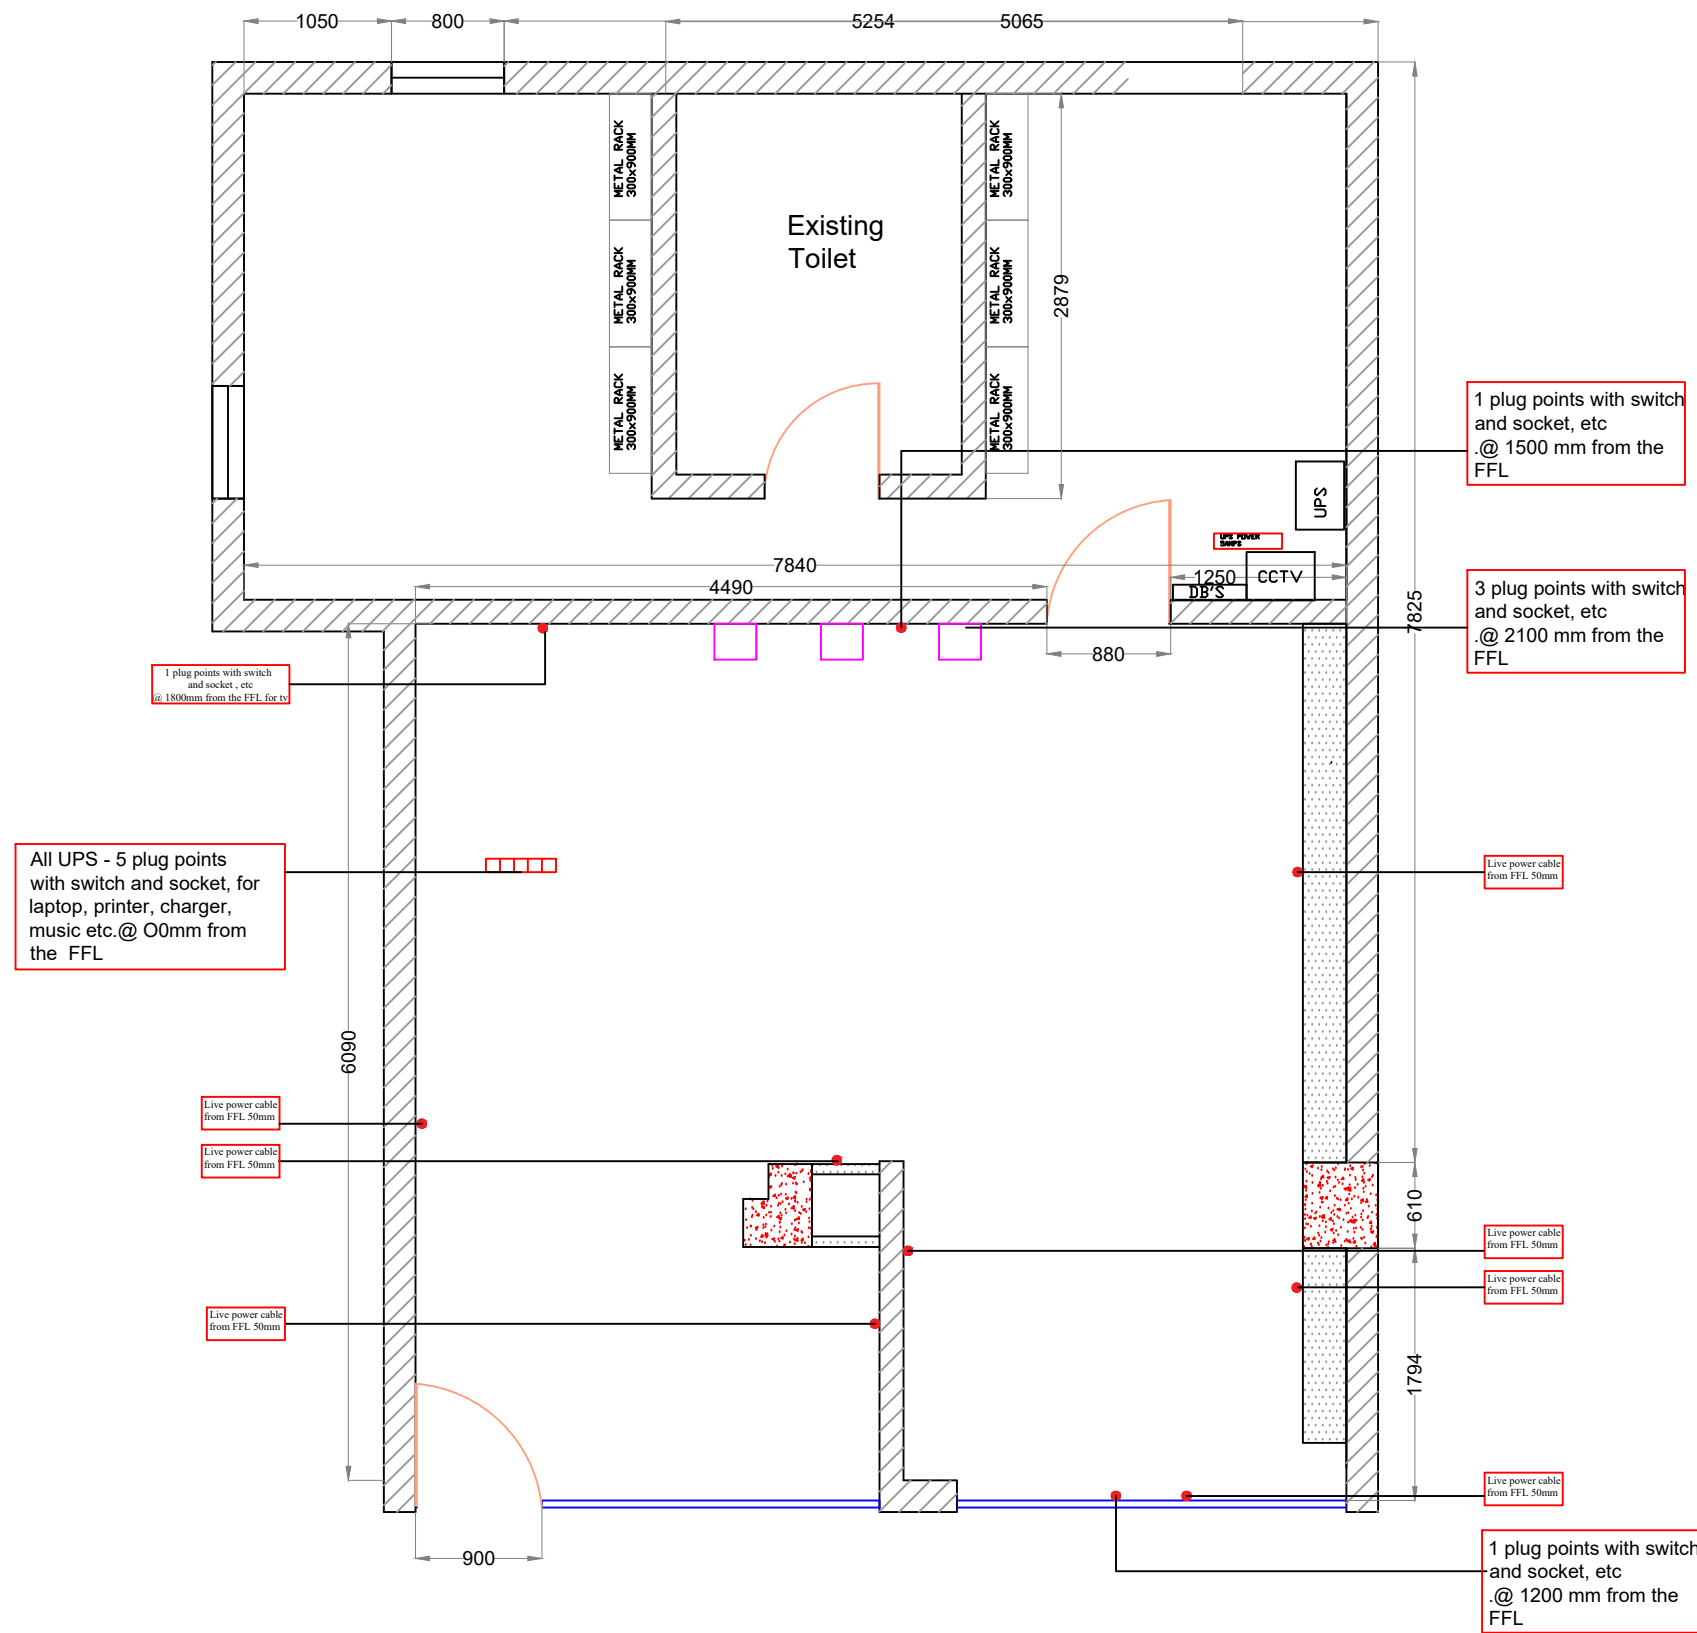

POWER LAYOUT
A-1.1
SCALE: NTS

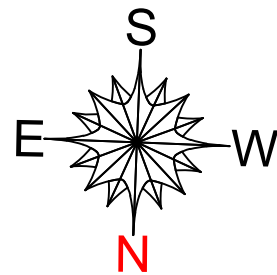

GENERAL NOTES :

1. ALL DIMENSIONS ARE MILLIMETER, UNLESS MENTIONED OTHERWISE.
2. ALL DIMENSIONS TO BE CHECKED AND VERIFIED ON SITE BY CONTRACTORS PRIOR TO COMMENCEMENT OF WORK.
3. ANY DISCREPANCIES TO BE CLARIFIED IMMEDIATELY, AND CHANGES REQUIRED SHALL BE CONFIRMED FROM THE ARCHITECT.
4. WRITTEN DIMENSIONS SHOULD BE FOLLOWED.
5. THIS DRAWING SHALL BE READ IN CONJUNCTION WITH OTHER PERTINENT.

PIGEON

PROJECT :

STORE NAME : MEM NAGAR
STORE CODE :

DWG TITLE :

POWER LAYOUT

NOTES:

AREA STATEMENT

RETAIL AREA : 442 SQFT
BOH & Toilet AREA : 303 SQFT
TOTAL AREA : 745 SQFT

TOTAL HIGHT : 3110 MM

FFL TO BEAM HIGHT : 2700 MM

FALSE CEILING HIGHT @ FFL

DRAWN BY : POOJASHREE PS

CHECKED BY : Mr. PRASHANTH

APPROVED BY : Mr.MAYANK

SCALE: NTS


DATE: 20.01.2025

DWG NUMBER

P3


REVISION

R1

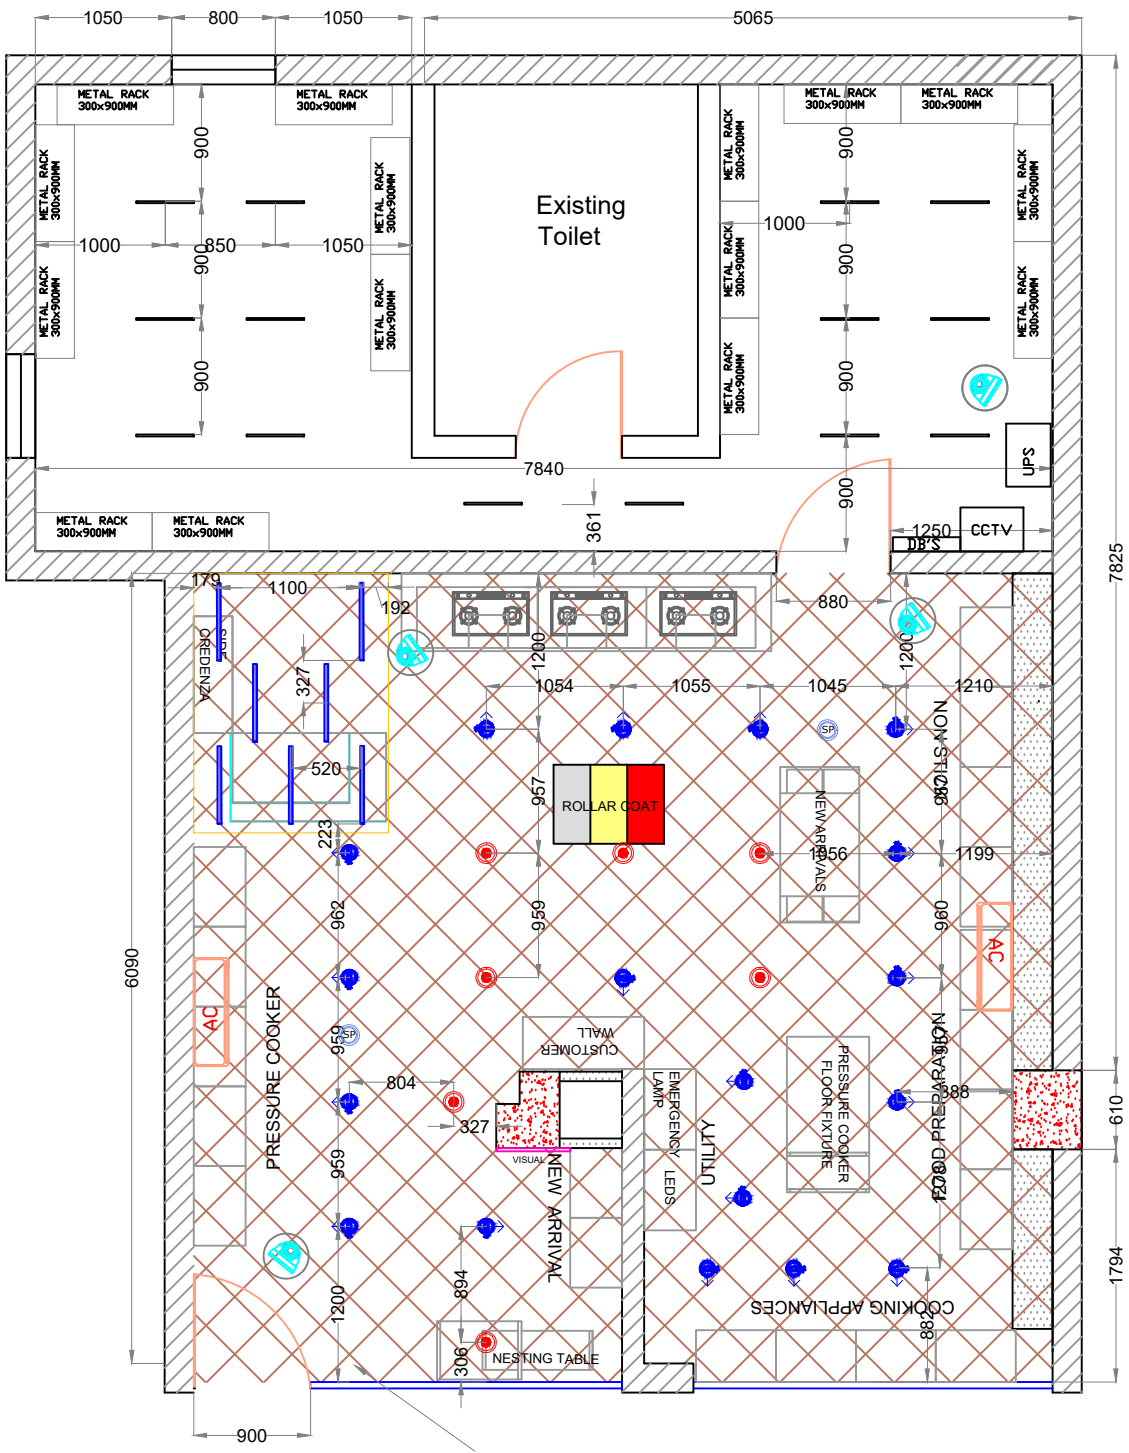

A-1.1 RCP LAYOUT
SCALE: NTS

LIGHTING LEGEND			
SR NO	SYMBOL	DESCRIPTION	QTY
1		LED DOWNLIGHT RECESSED DENVER 24W 60DEG 4000K	07
2		LED DOWNLIGHT RECESSED DENVER 36W 24DEG 4000K	00
3		LED WALLWASHER - DOLPHIN 24W 40DEG 4000K	19
4		LED WALLWASHER - DOLPHIN 36W 40DEG 4000K	00
5		LED LINEAR PROFILE - LIGHTLINE 18W 2' 4000K	07
6		LED LINEAR PROFILE - LIGHTLINE 10W 1' 4000K	00
7		18W LED Tube	17
8		SPEAKER	02
9		CAMERA	04

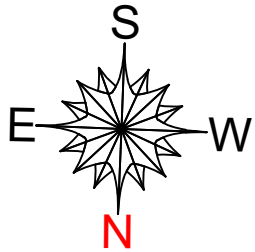

GENERAL NOTES :

1. ALL DIMENSIONS ARE MILLIMETER, UNLESS MENTIONED OTHERWISE.
2. ALL DIMENSIONS TO BE CHECKED AND VERIFIED ON SITE BY CONTRACTORS PRIOR TO COMMENCEMENT OF WORK.
3. ANY DISCREPANCIES TO BE CLARIFIED IMMEDIATELY, AND CHANGES REQUIRED SHALL BE CONFIRMED FROM THE ARCHITECT.
4. WRITTEN DIMENSIONS SHOULD BE FOLLOWED.
5. THIS DRAWING SHALL BE READ IN CONJUNCTION WITH OTHER PERTINENT.

PIGEON

PROJECT :

STORE NAME : MEM NAGAR
STORE CODE :

DWG TITLE :

RCP LAYOUT

NOTES:

AREA STATEMENT
RETAIL AREA : 442 SQFT
BOH & Toilet AREA : 303 SQFT
TOTAL AREA : 745 SQFT

TOTAL HIGHT : 3110 MM

FFL TO BEAM HIGHT : 2700 MM

FALSE CEILING HIGHT @ FFL

DRAWN BY : POOJASHREE PS

CHECKED BY : Mr: PRASHANTH

APPROVED BY : Mr:MAYANK

SCALE: NTS


DATE: 20.01.2025

DWG NUMBER

P5

REVISION

R1

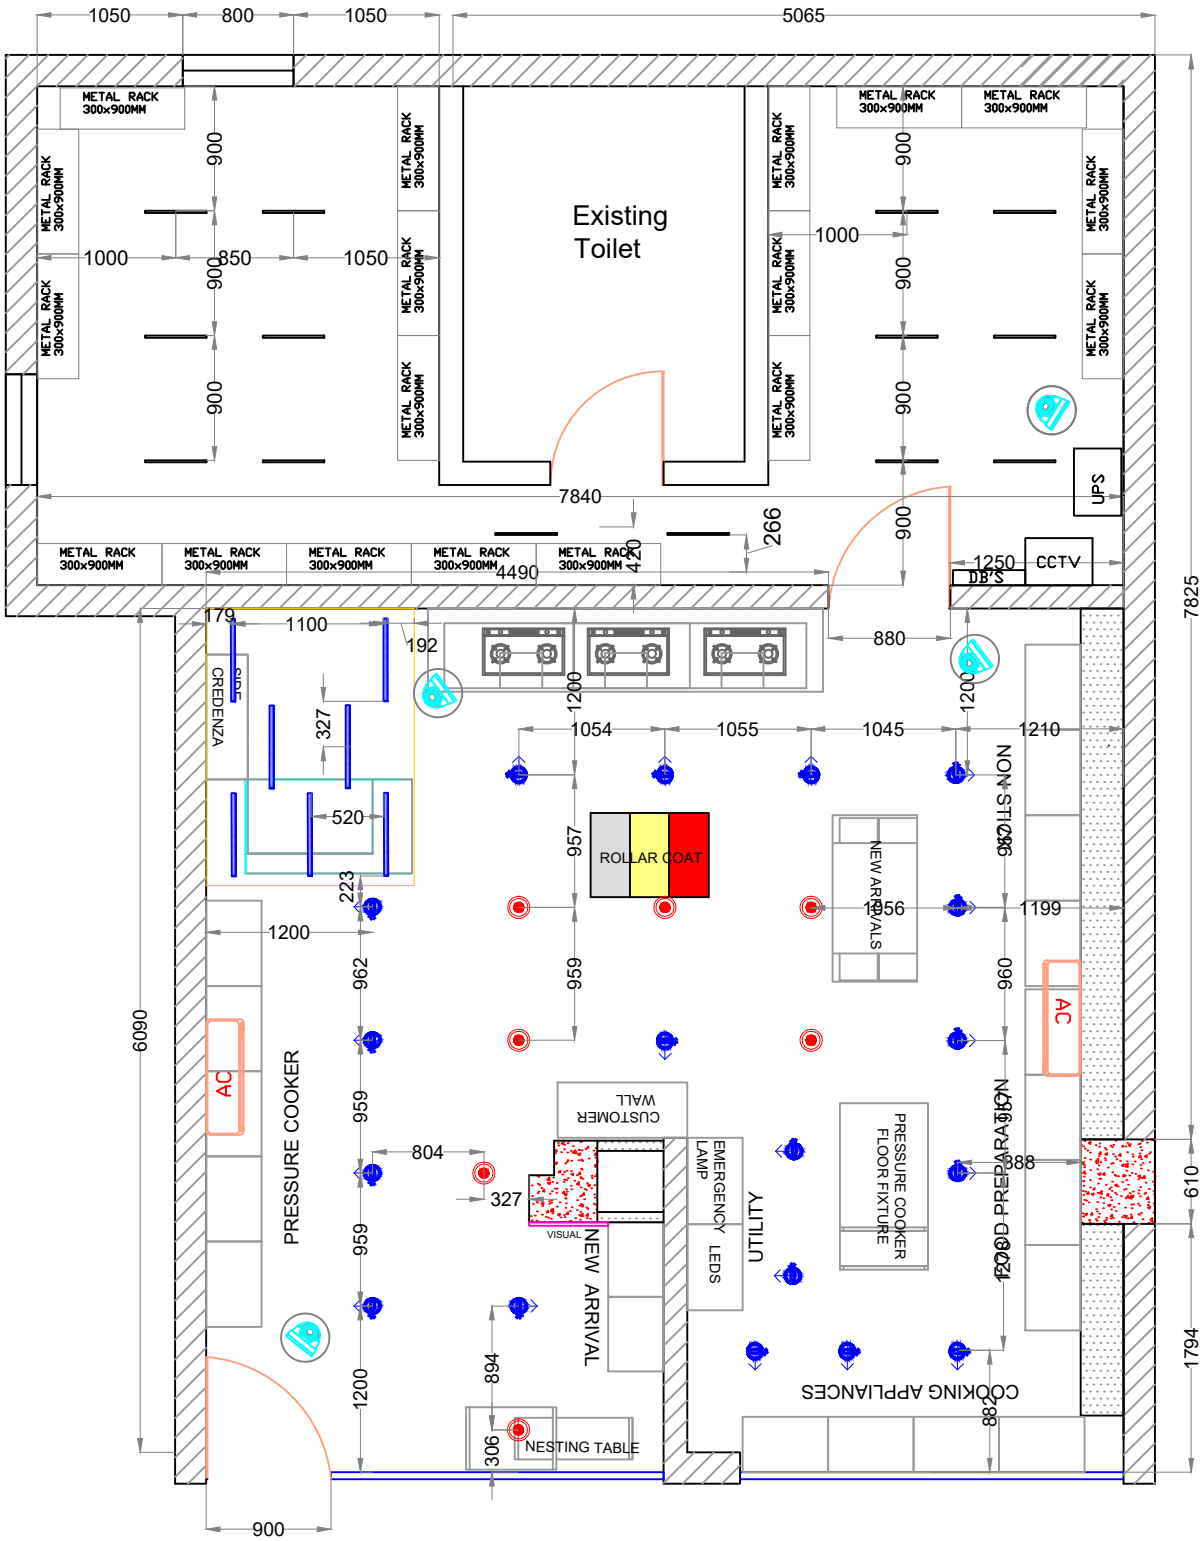


A-1.1 LIGHTING LAYOUT

SCALE: NTS

LIGHTING LEGEND

SR NO	SYMBOL	DESCRIPTION	QTY
1		LED DOWNLIGHT RECESSED DENVER 24W 60DEG 4000K	07
2		LED DOWNLIGHT RECESSED DENVER 36W 24DEG 4000K	00
3		LED WALLWASHER - DOLPHIN 24W 40DEG 4000K	19
4		LED WALLWASHER - DOLPHIN 36W 40DEG 4000K	00
5		LED LINEAR PROFILE - LIGHTLINE 18W 2' 4000K	07
6		LED LINEAR PROFILE - LIGHTLINE 10W 1' 4000K	00
7		18W LED Tube	13

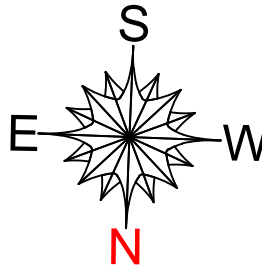

GENERAL NOTES :

- ALL DIMENSIONS ARE MILLIMETER, UNLESS MENTIONED OTHERWISE.
- ALL DIMENSIONS TO BE CHECKED AND VERIFIED ON SITE BY CONTRACTORS PRIOR TO COMMENCEMENT OF WORK.
- ANY DISCREPANCIES TO BE CLARIFIED IMMEDIATELY, AND CHANGES REQUIRED SHALL BE CONFIRMED FROM THE ARCHITECT.
- WRITTEN DIMENSIONS SHOULD BE FOLLOWED.
- THIS DRAWING SHALL BE READ IN CONJUNCTION WITH OTHER PERTINENT.

PIGEON

PROJECT :

STORE NAME : MEM NAGAR
STORE CODE :

DWG TITLE :

LIGHTING LAYOUT

NOTES:

AREA STATEMENT

RETAIL AREA : 442 SQFT
BOH & Toilet AREA : 303 SQFT
TOTAL AREA : 745 SQFT

TOTAL HIGHT : 3110 MM

FFL TO BEAM HIGHT : 2700 MM

FALSE CEILING HIGHT @ FFL

DRAWN BY : POOJASHREE PS

CHECKED BY : Mr: PRASHANTH

APPROVED BY : Mr:MAYANK

SCALE: NTS



DATE: 20.01.2025

DWG NUMBER

P4

REVISION

R1

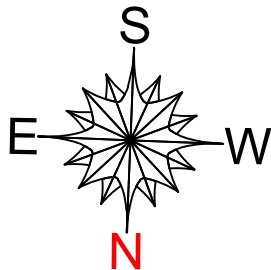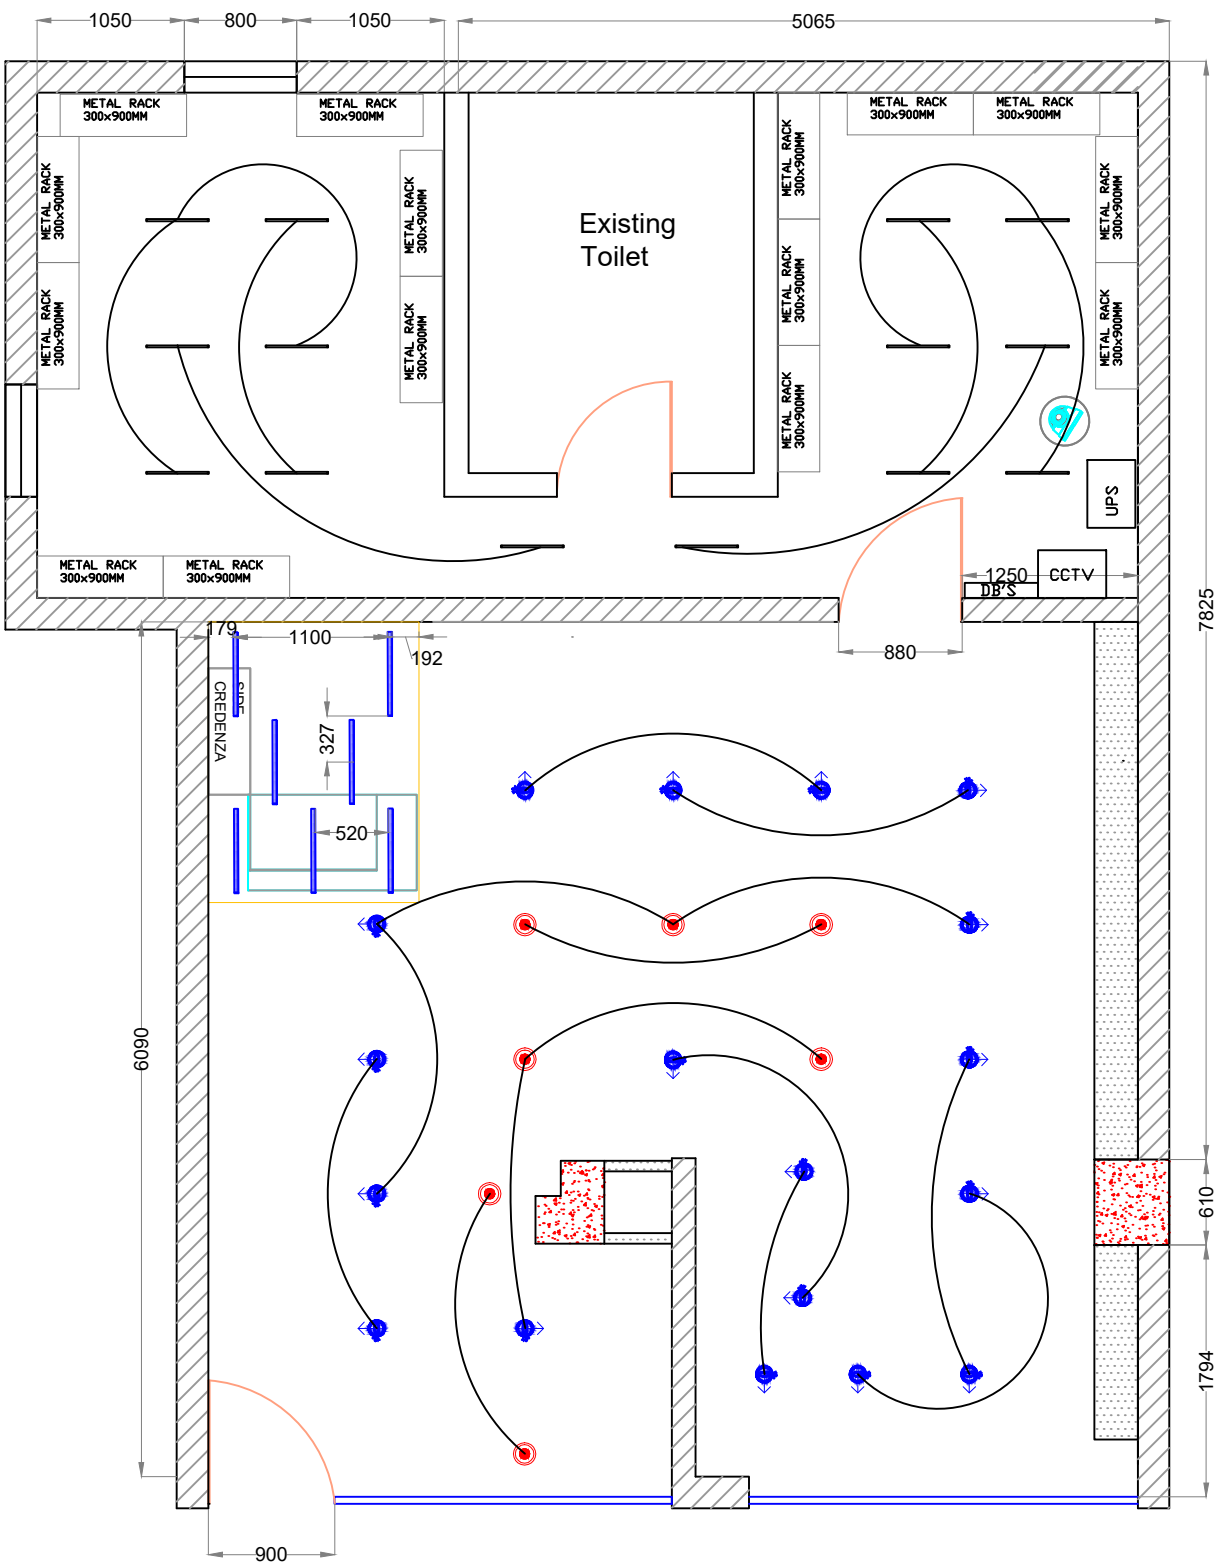

GENERAL NOTES :

1. ALL DIMENSIONS ARE MILLIMETER, UNLESS MENTIONED OTHERWISE.
2. ALL DIMENSIONS TO BE CHECKED AND VERIFIED ON SITE BY CONTRACTORS PRIOR TO COMMENCEMENT OF WORK.
3. ANY DISCREPANCIES TO BE CLARIFIED IMMEDIATELY, AND CHANGES REQUIRED SHALL BE CONFIRMED FROM THE ARCHITECT.
4. WRITTEN DIMENSIONS SHOULD BE FOLLOWED.
5. THIS DRAWING SHALL BE READ IN CONJUNCTION WITH OTHER PERTINENT.

PIGEON

PROJECT :

STORE NAME : MEM NAGAR
STORE CODE :

DWG TITLE :

LOOPING LAYOUT

NOTES:

AREA STATEMENT
RETAIL AREA : 442 SQFT
BOH & Toilet AREA : 303 SQFT
TOTAL AREA : 745 SQFT

TOTAL HIGHT : 3110 MM

FFL TO BEAM HIGHT : 2700 MM

FALSE CEILING HIGHT @ FFL

DRAWN BY : POOJASHREE PS

CHECKED BY : Mr. PRASHANTH

APPROVED BY : Mr.MAYANK

SCALE: NTS

DATE: 20.01.2025

DWG NUMBER

REVISION

P6

R1

LIGHTING LEGEND

SR NO	SYMBOL	DESCRIPTION	QTY
1	●	LED DOWNLIGHT RECESSED DENVER 24W 60DEG 4000K	07
2	●	LED DOWNLIGHT RECESSED DENVER 36W 24DEG 4000K	00
3	●	LED WALLWASHER - DOLPHIN 24W 40DEG 4000K	19
4	●	LED WALLWASHER - DOLPHIN 36W 40DEG 4000K	00
5	—	LED LINEAR PROFILE - LIGHTLINE 18W 2' 4000K	07
6	—	LED LINEAR PROFILE - LIGHTLINE 10W 1' 4000K	00
7	—	18W LED Tube	17
8	●	SPEAKER	02
9	●	CAMERA	04

A-1.1

LOOPING LAYOUT

SCALE: NTS