



LEGENDS-HVAC

	UPVC TOILET EX. DUCT
	UPVC FRESH AIR DUCT
	REFRIGERANT PIPE
	AC DRAIN PIPE
	CASSETTE UNIT
	DX OUTDOOR UNIT
	DIFFUSER
	HI-WALL UNIT
	CABLE TRAY FOR PIPES
	VOLUME CONTROL DAMPER
	TOILET EXHAUST FAN
	FRESH AIR FAN

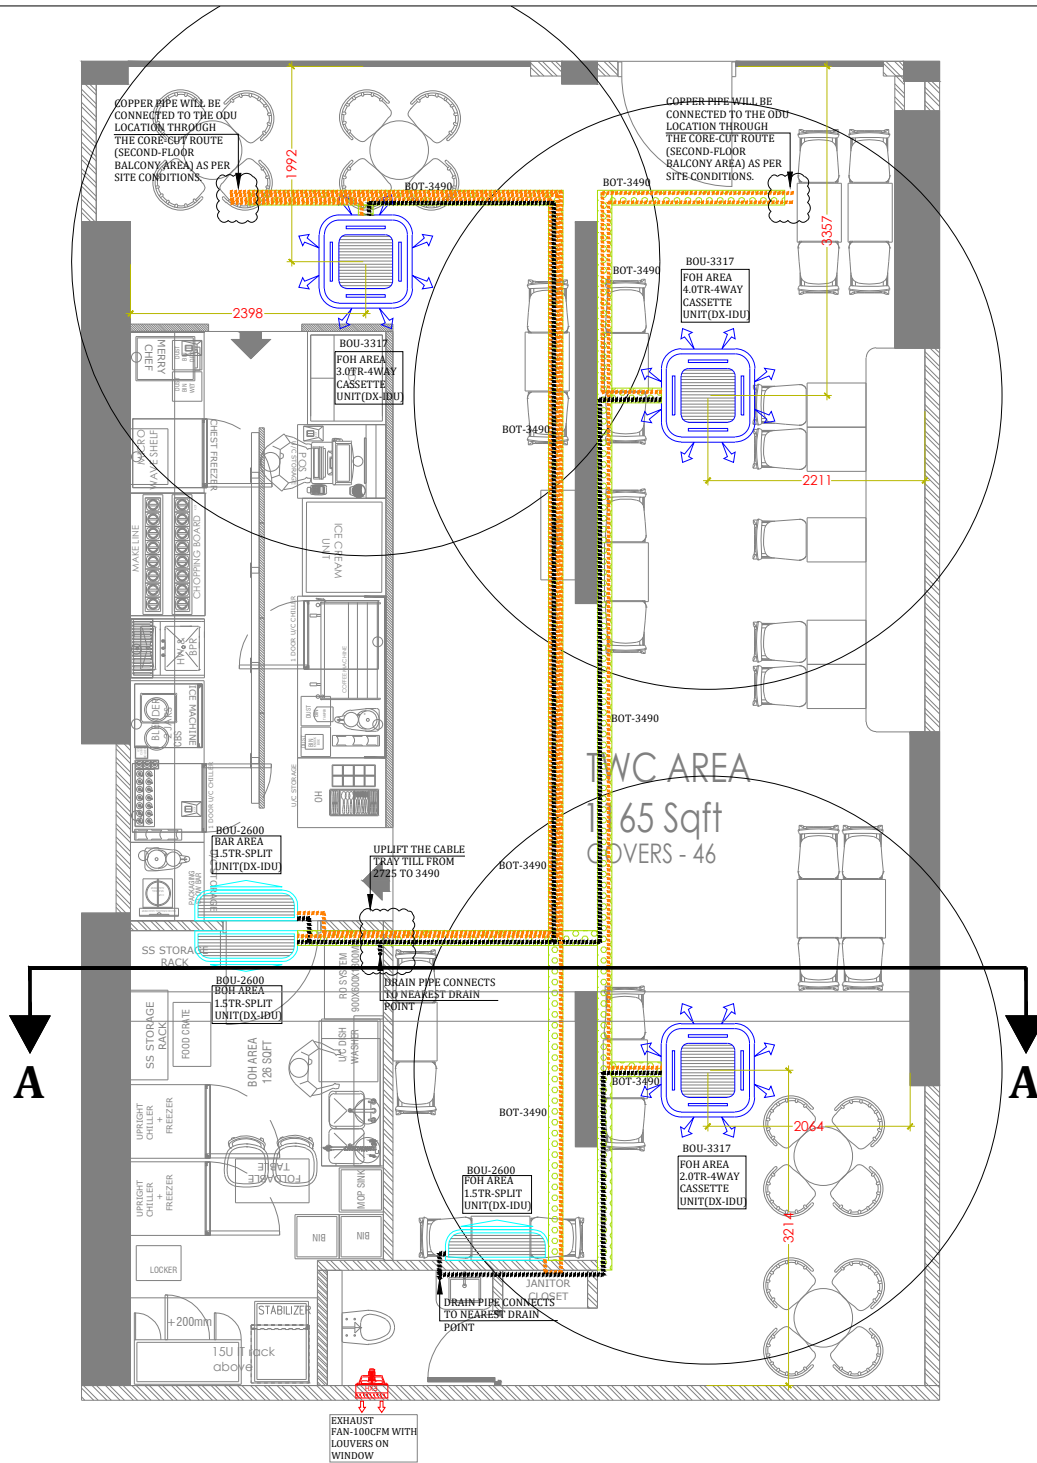

SECTION - A

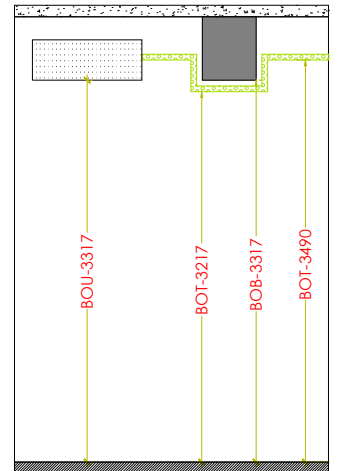

UNIT SCHEDULE

SR. NO.	TYPE	UNIT	TR/CFM	QTY
1.	DX	HI-WALL IDU	1.5	03
2.	DX	4 WAY CASSETTE IDU	2.0	01
3.	DX	4 WAY CASSETTE IDU	3.0	01
4.	DX	4 WAY CASSETTE IDU	4.0	01
5.	FAN	EXHAUST FAN	100	01

NOTE:

- THE UNIT BOTTOM SHOULD MATCH THE BEAM BOTTOM.
- THE COPPER PIPE WILL BE BENT AND ROUTED BELOW BEAM, AFTER THAT MAINTAINING THE SAME HEIGHT AT 3490 MM.

NORTH :	PROJECT :	GENERAL NOTES :	REVISIONS				LEGEND		DWG. NO.				CLIENT :	HEISETASSE BEVERAGES PRIVATE LTD. Brigade Road, Next to IIRIS - The Business Hotel & Spa, Ashok Nagar Brigade road Bangalore- 560025.		
MIRA ROAD, MUMBAI		1) CONTRACTOR TO CHECK AND VERIFY ALL DIMENSIONS BEFORE EXECUTION OF WORK 2) DO NOT SCALE THE DRAWINGS 3) WRITTEN DIMENSIONS TO BE FOLLOWED 4) CONTRACTOR TO MARK LINEOUT ALL THE DOORS, WINDOW OPENINGS, DOORS & THEIR HEIGHTS ON SITE FOR ARCHITECT TO CHECK 5) CONTRACTOR TO INFORM ARCHITECT OF ANY DISCREPANCIES IN SITE MEASUREMENTS 6) ALL DIMENSIONS ARE FINISHED DIMENSIONS AND ARE TO BE CONSIDERED SO 7) ALL BRICK WORK IS SHOWN HATCHED	REV. NO.	DATE	DESCRIPTION	PRINTS ISSUED DATE	SYMBOL	DESCRIPTION	DWG. NAME.	HVAC LAYOUT	DATE	07.05.2026			SCALE	N/A
			DRAWN BY		GURUVIGNESH		JOB NO.		APPROVED BY		KARTHIK				REV NO.	

THIRD WAVE COFFEE

This drawing is the property of **Third wave coffee** and is not to be reproduced or copied in whole or in part. It is to be used for the project and site specifically identified herein and is not to be used on any other project. It is to be returned upon request.