




DESCRIPTION :

Site Name :
Guwahati


Layout : First floor
Sofa section
Furniture Layout

Area:
7175.83 sft

NOTE :
Sofa Sets - 14nos.
Dining Set - 02nos.

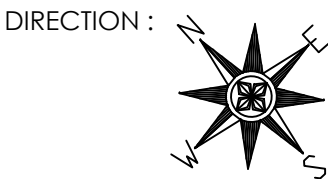


FORMAT : A3
DRAWN BY : Jigar Panchal
DATE: 19-12-2023
DATE OF EDIT:

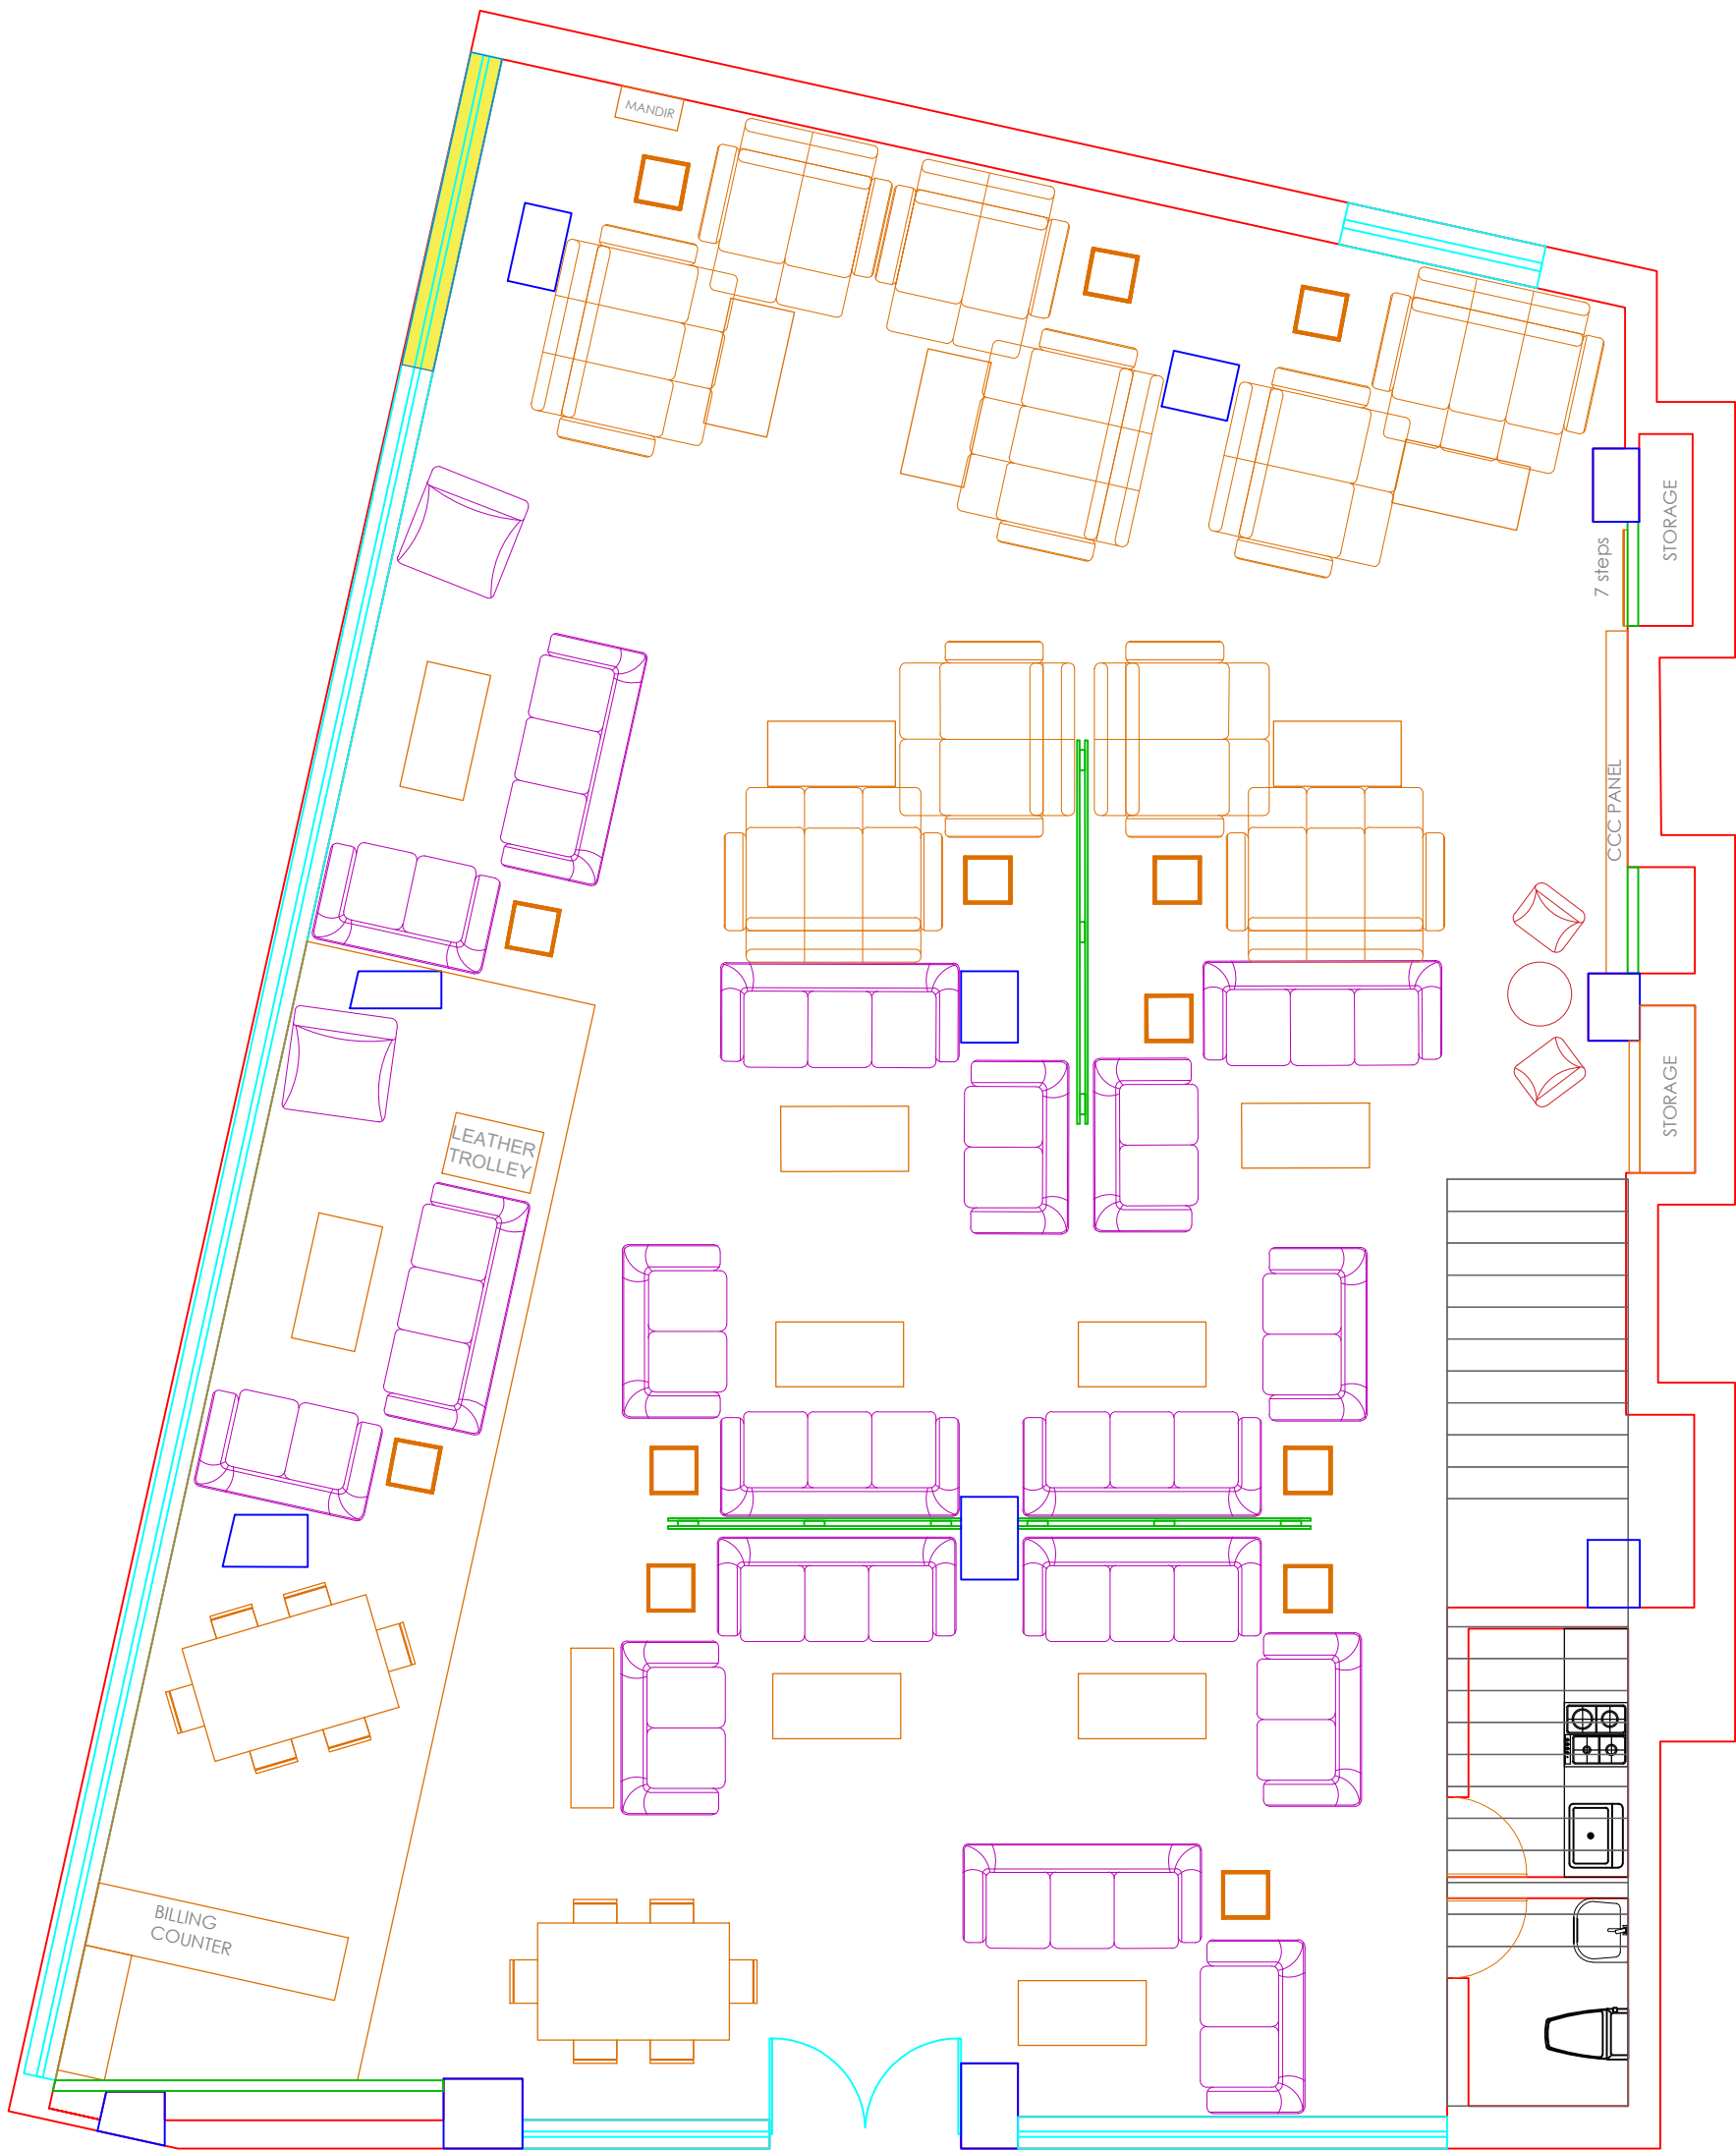



DESCRIPTION :

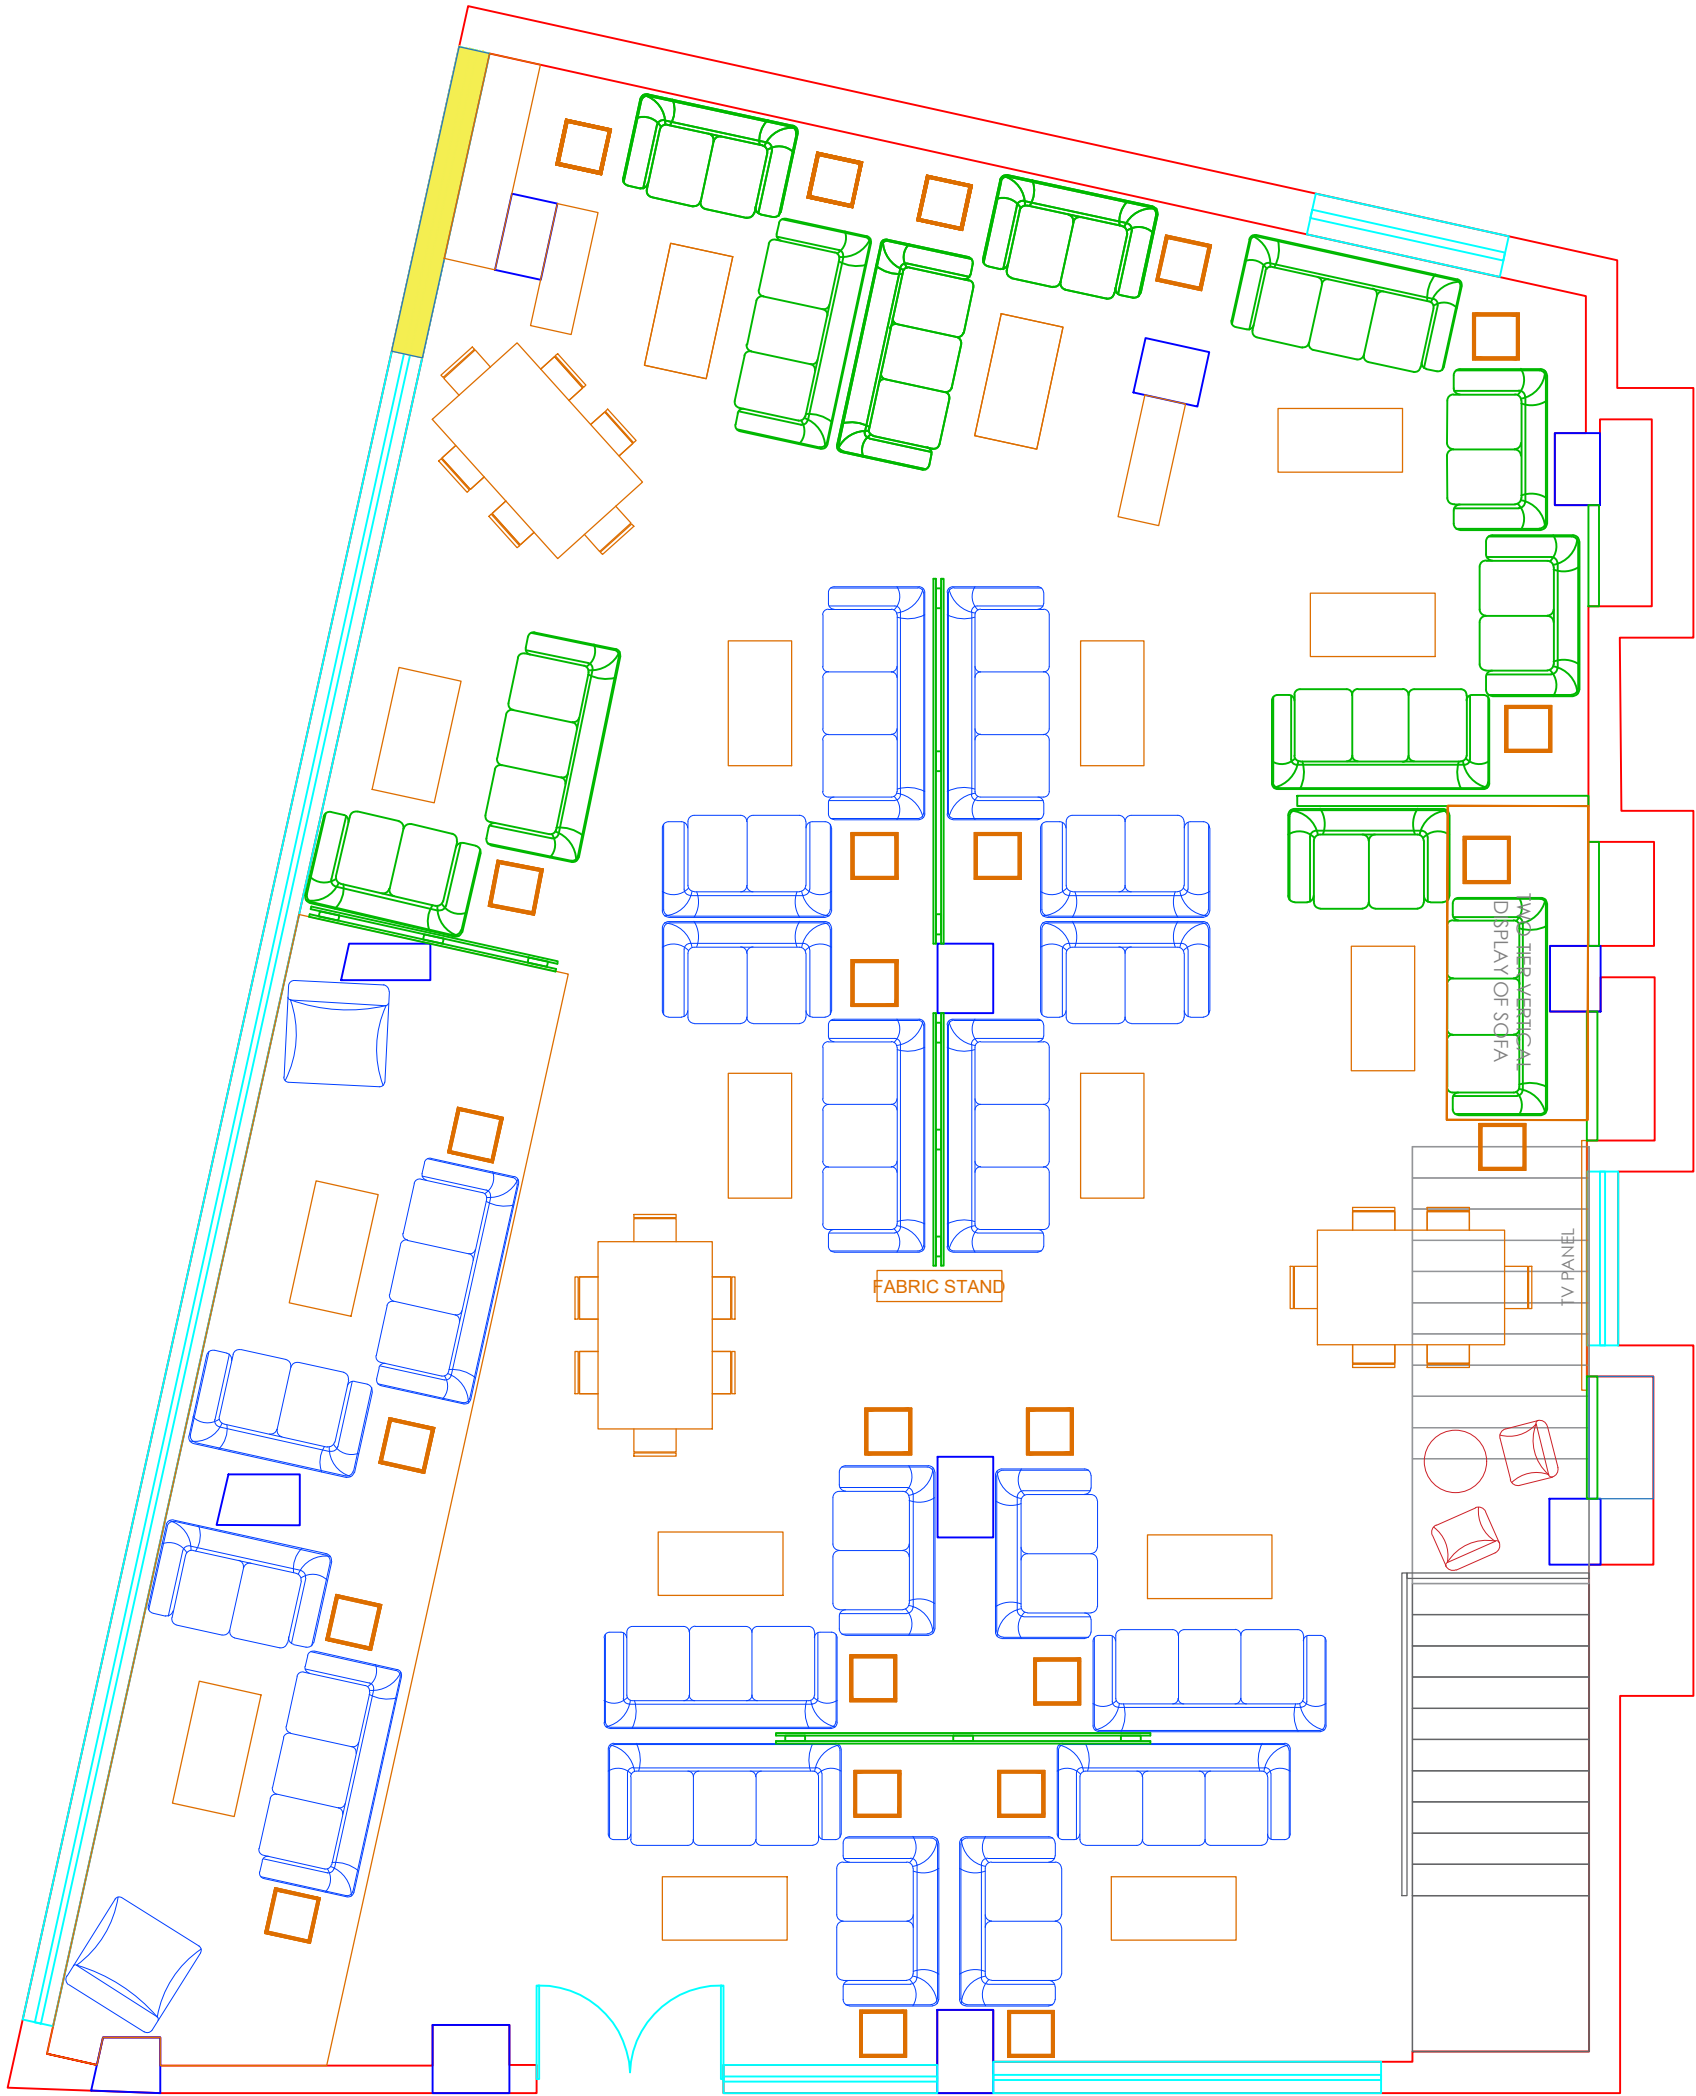


Site Name :
Guwahati

Layout : Second floor
Sofa section Furniture
Layout

Area:
7175.83 sft

NOTE :
Sofa Sets - 16nos.
Dining Set - 03nos.

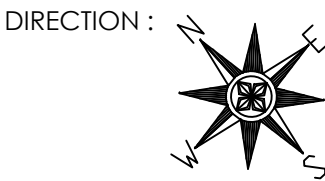

FORMAT : A3
DRAWN BY : Jigar Panchal
DATE: 19-12-2023
DATE OF EDIT:




DESCRIPTION :

Site Name :
Guwahati


Layout : Second Floor
Bed Section Combined
RCP Layout

Area:
7175.83 sft

NOTE :
Beds - 11nos.
Office table - 02nos

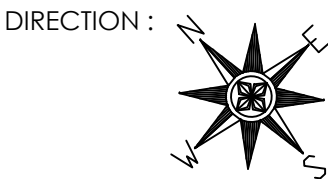

FORMAT : A3
DRAWN BY : Jigar Panchal
DATE: 19-12-2023
DATE OF EDIT:

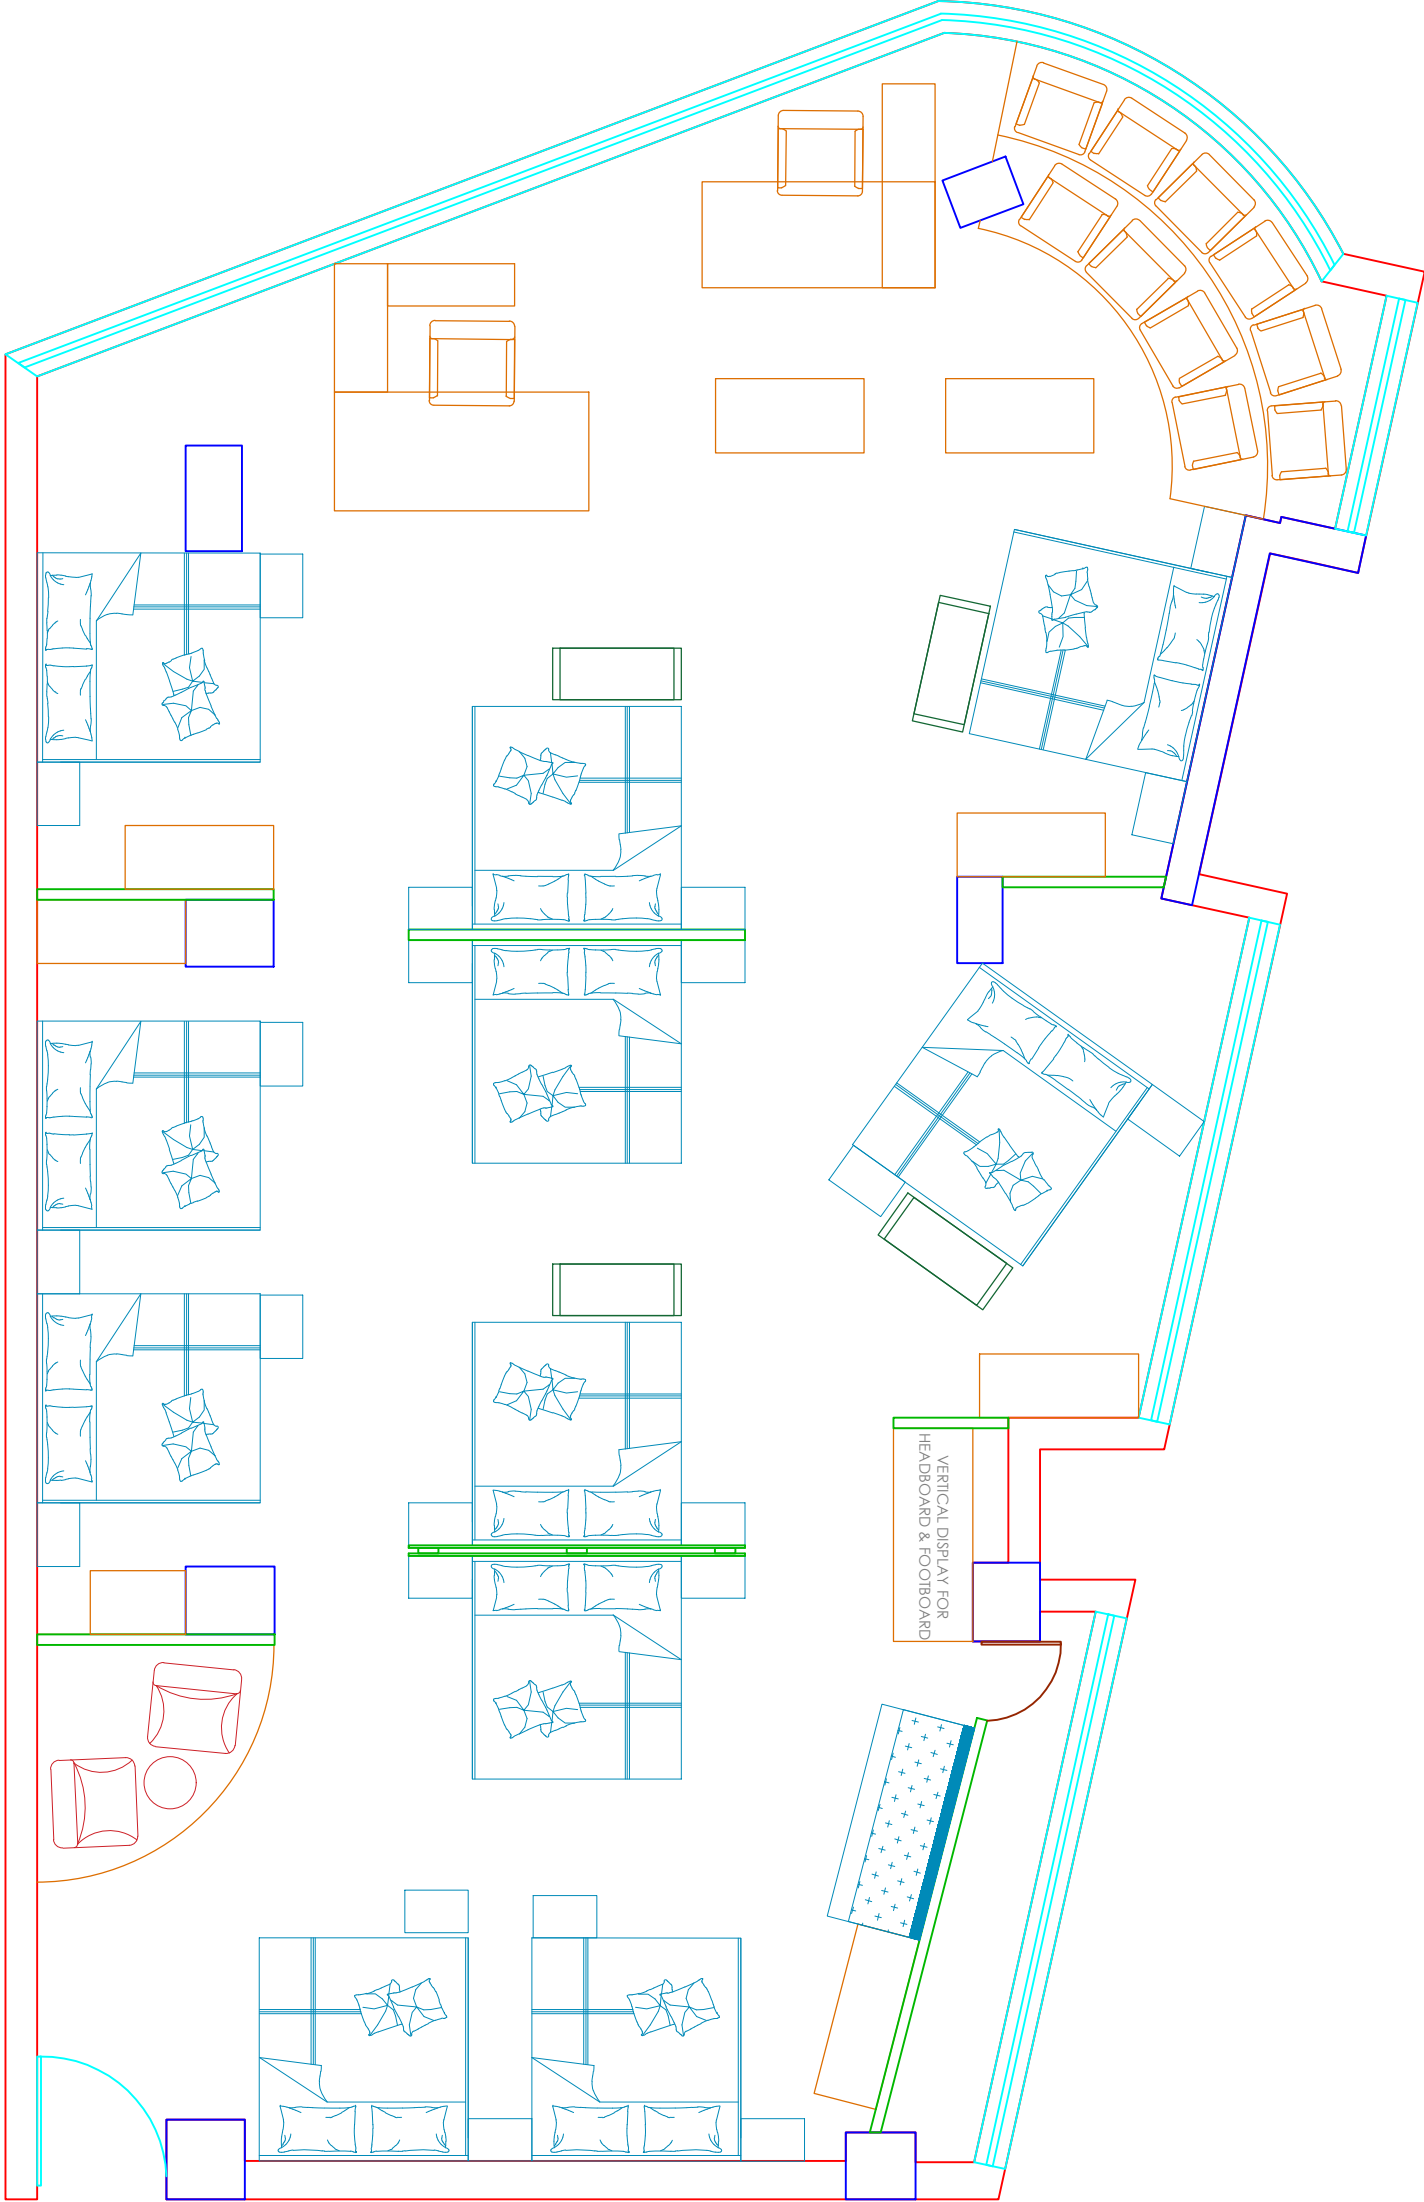



DESCRIPTION :

Site Name :
Guwahati

Layout : First floor
Sofa section
Dimension Layout

Area:
7175.83 sft

NOTE :
Sofa Sets - 14nos.
Dining Set - 02nos.

DIRECTION :




FORMAT : A3

DRAWN BY : Jigar Panchal

DATE: 19-12-2023

DATE OF EDIT:

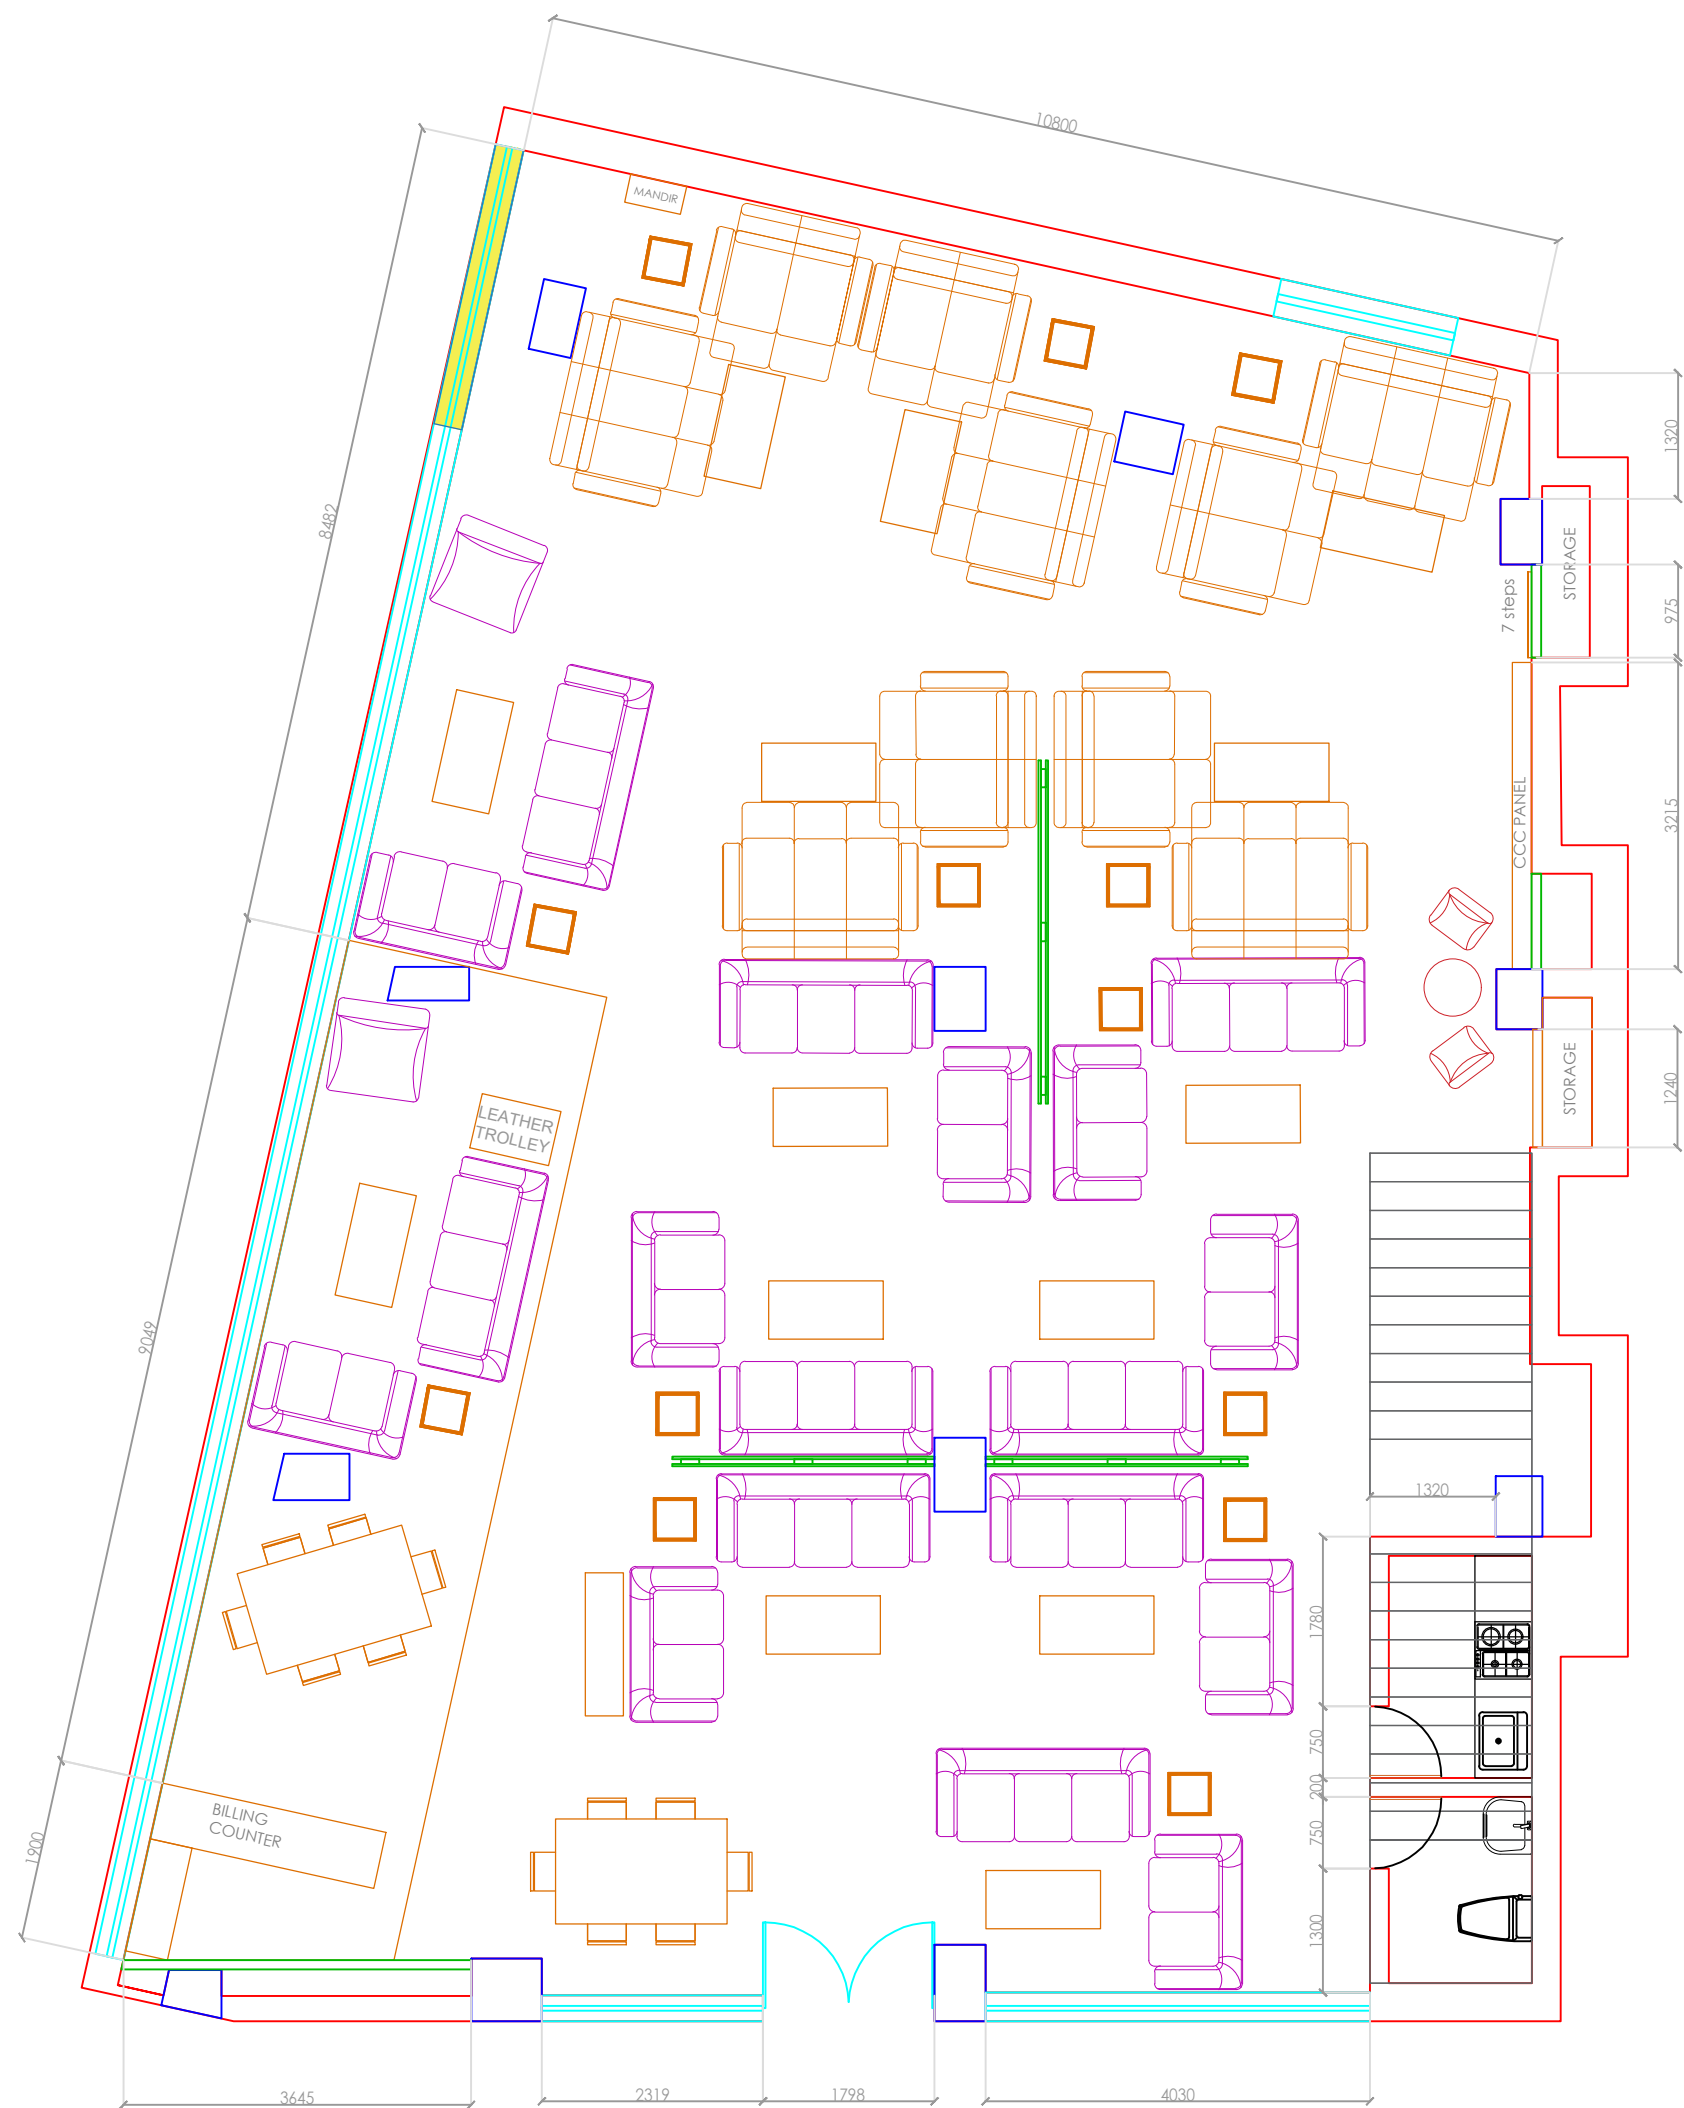




DESCRIPTION :

Site Name :
Guwahati

Layout : Second floor
Sofa section
Dimension Layout

Area:
7175.83 sft

NOTE :
Sofa Sets - 16nos.
Dining Set - 03nos.

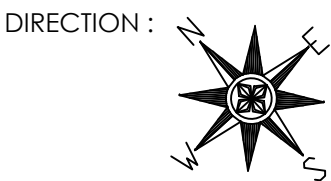

FORMAT : A3
DRAWN BY : Jigar Panchal
DATE: 19-12-2023
DATE OF EDIT:






DESCRIPTION :

Site Name :
Guwahati


Layout : Second Floor
Bed Section Dimension
Layout


Area:
7175.83 sft

NOTE :
Beds - 11nos.
Office table - 02nos

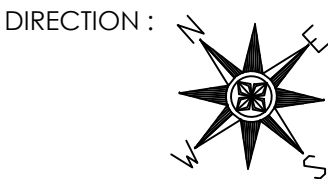

FORMAT : A3
DRAWN BY : Jigar Panchal
DATE: 19-12-2023
DATE OF EDIT:

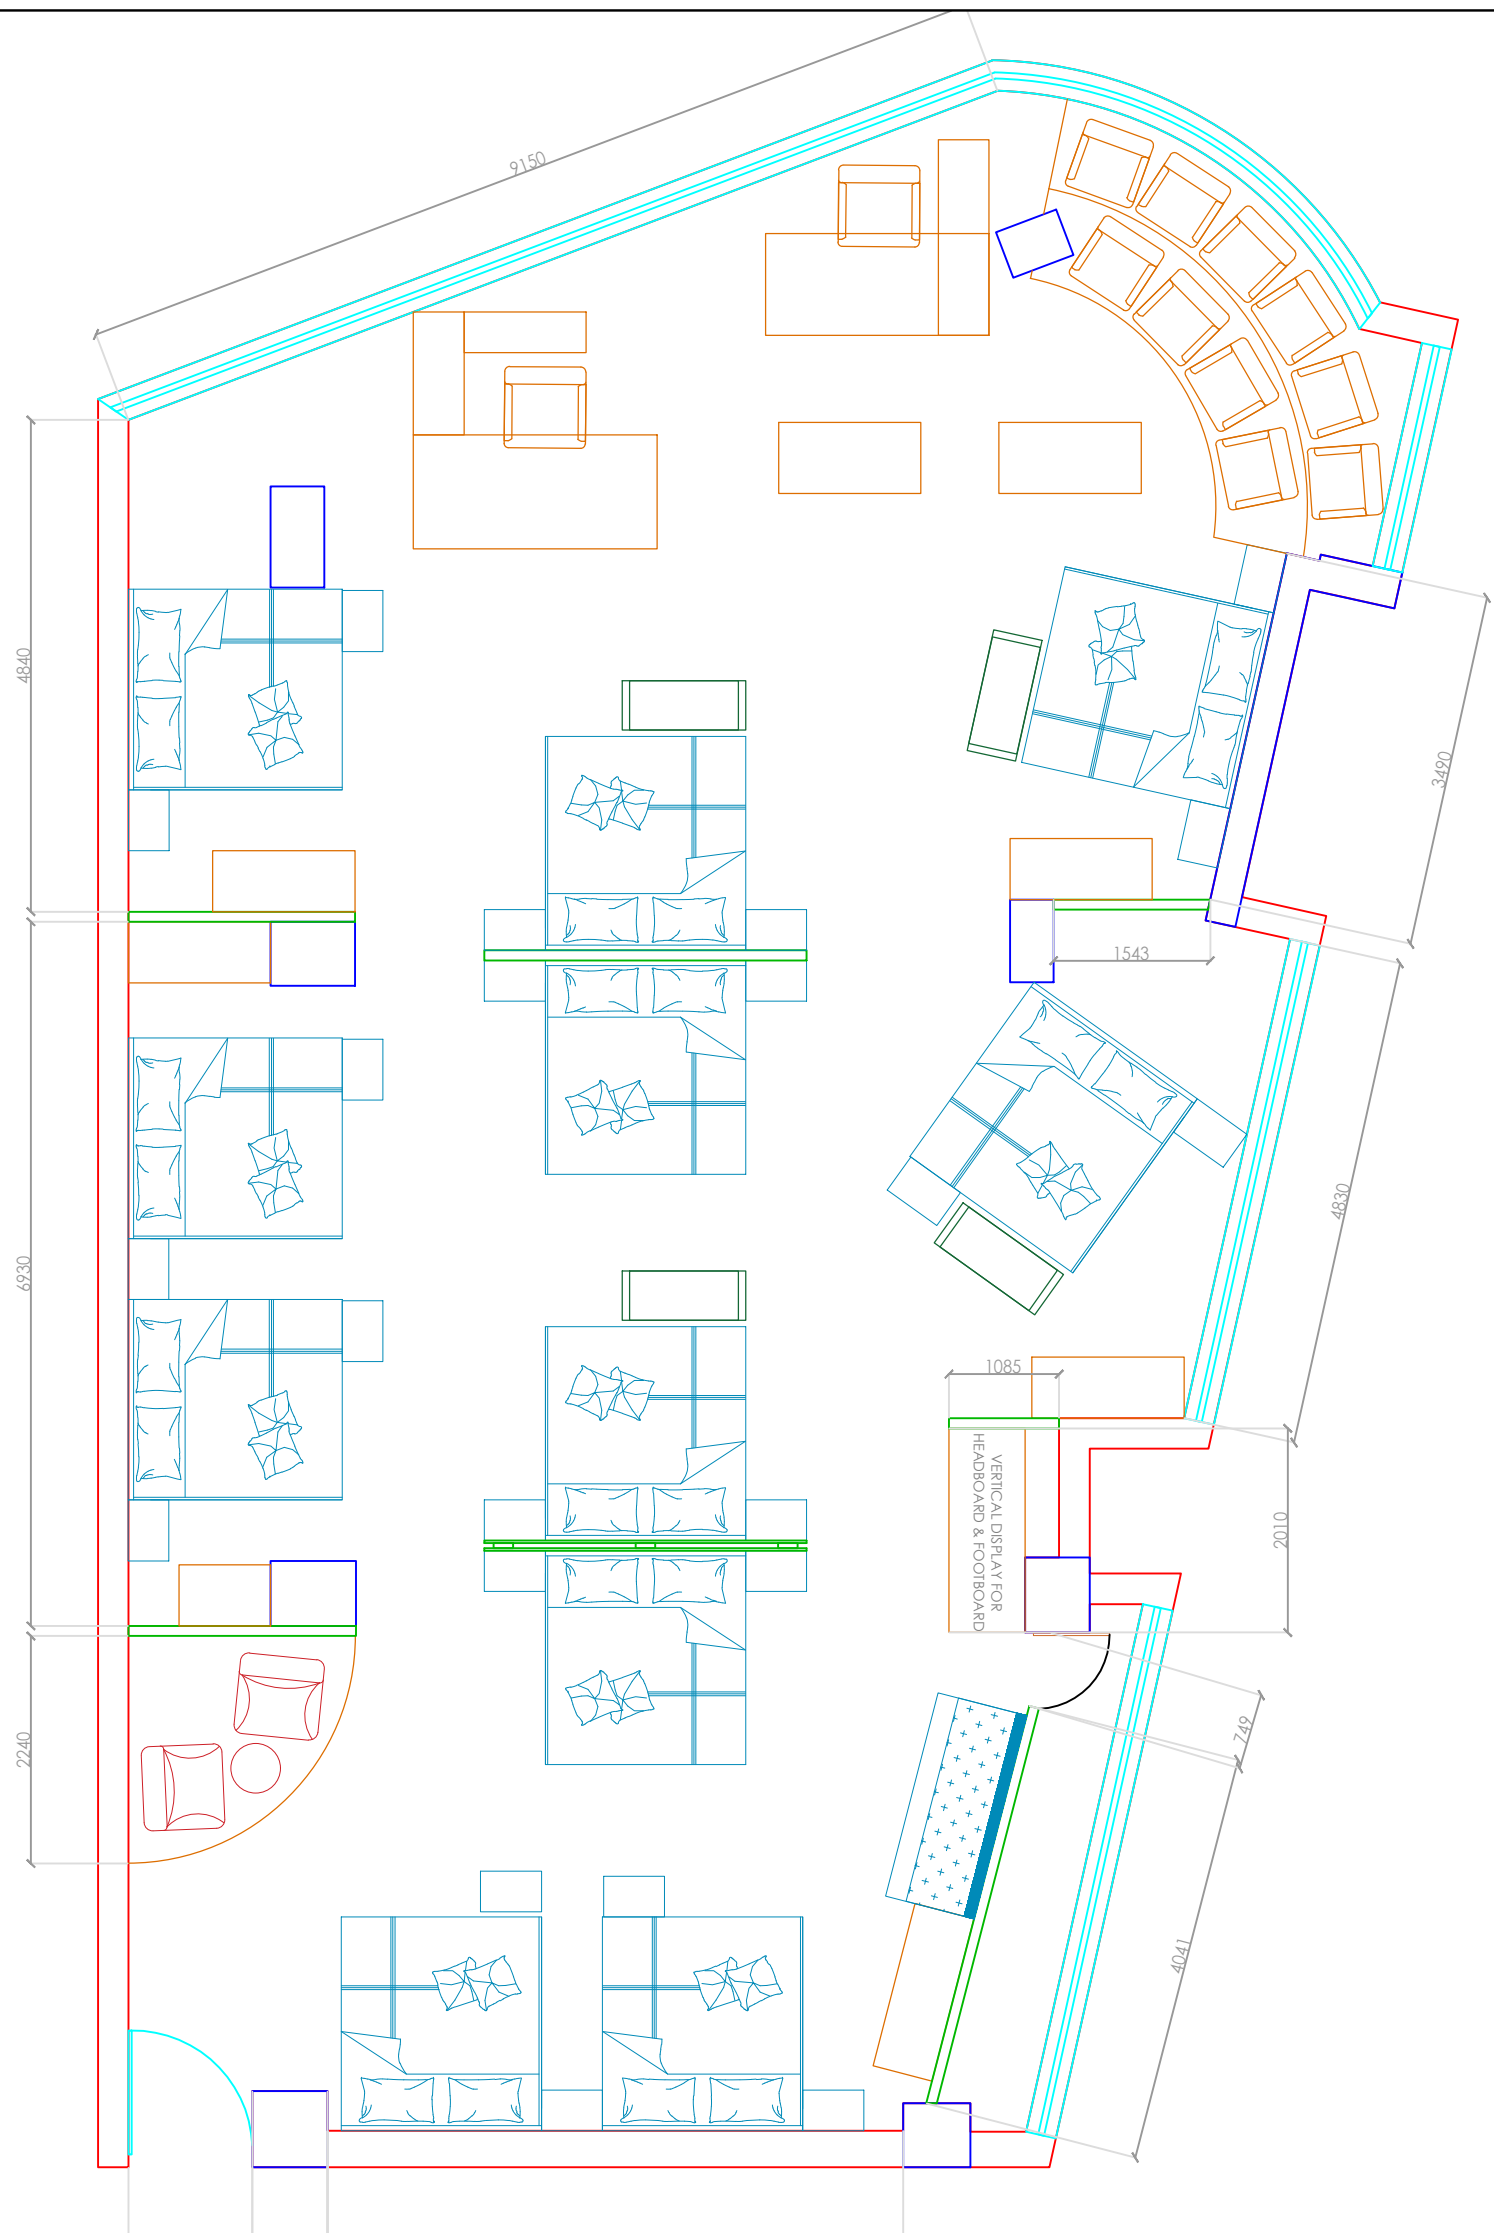

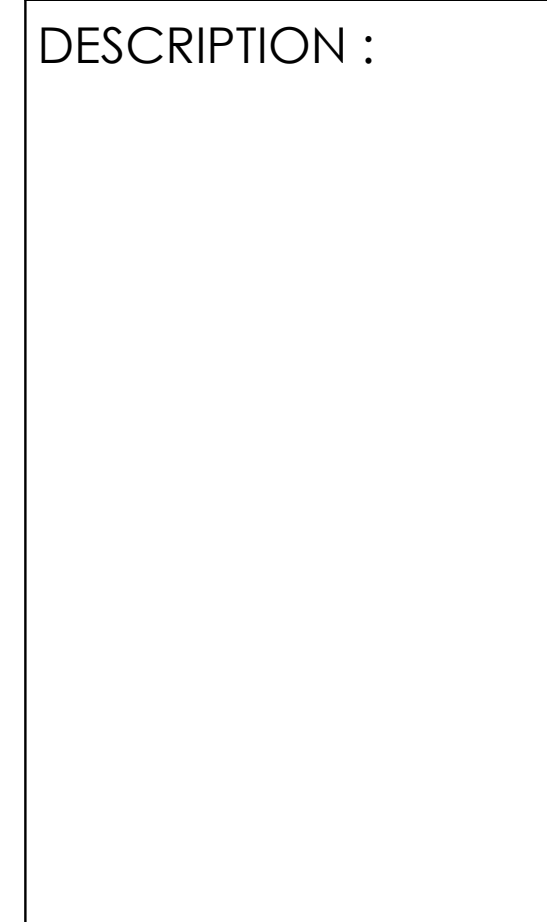


Layout : First floor
Sofa section Partition
Layout

NOTE :
Sofa Sets - 14nos.
Dining Set - 02nos.

FORMAT : A3


DATE: 19-12-2023

DATE OF EDIT:

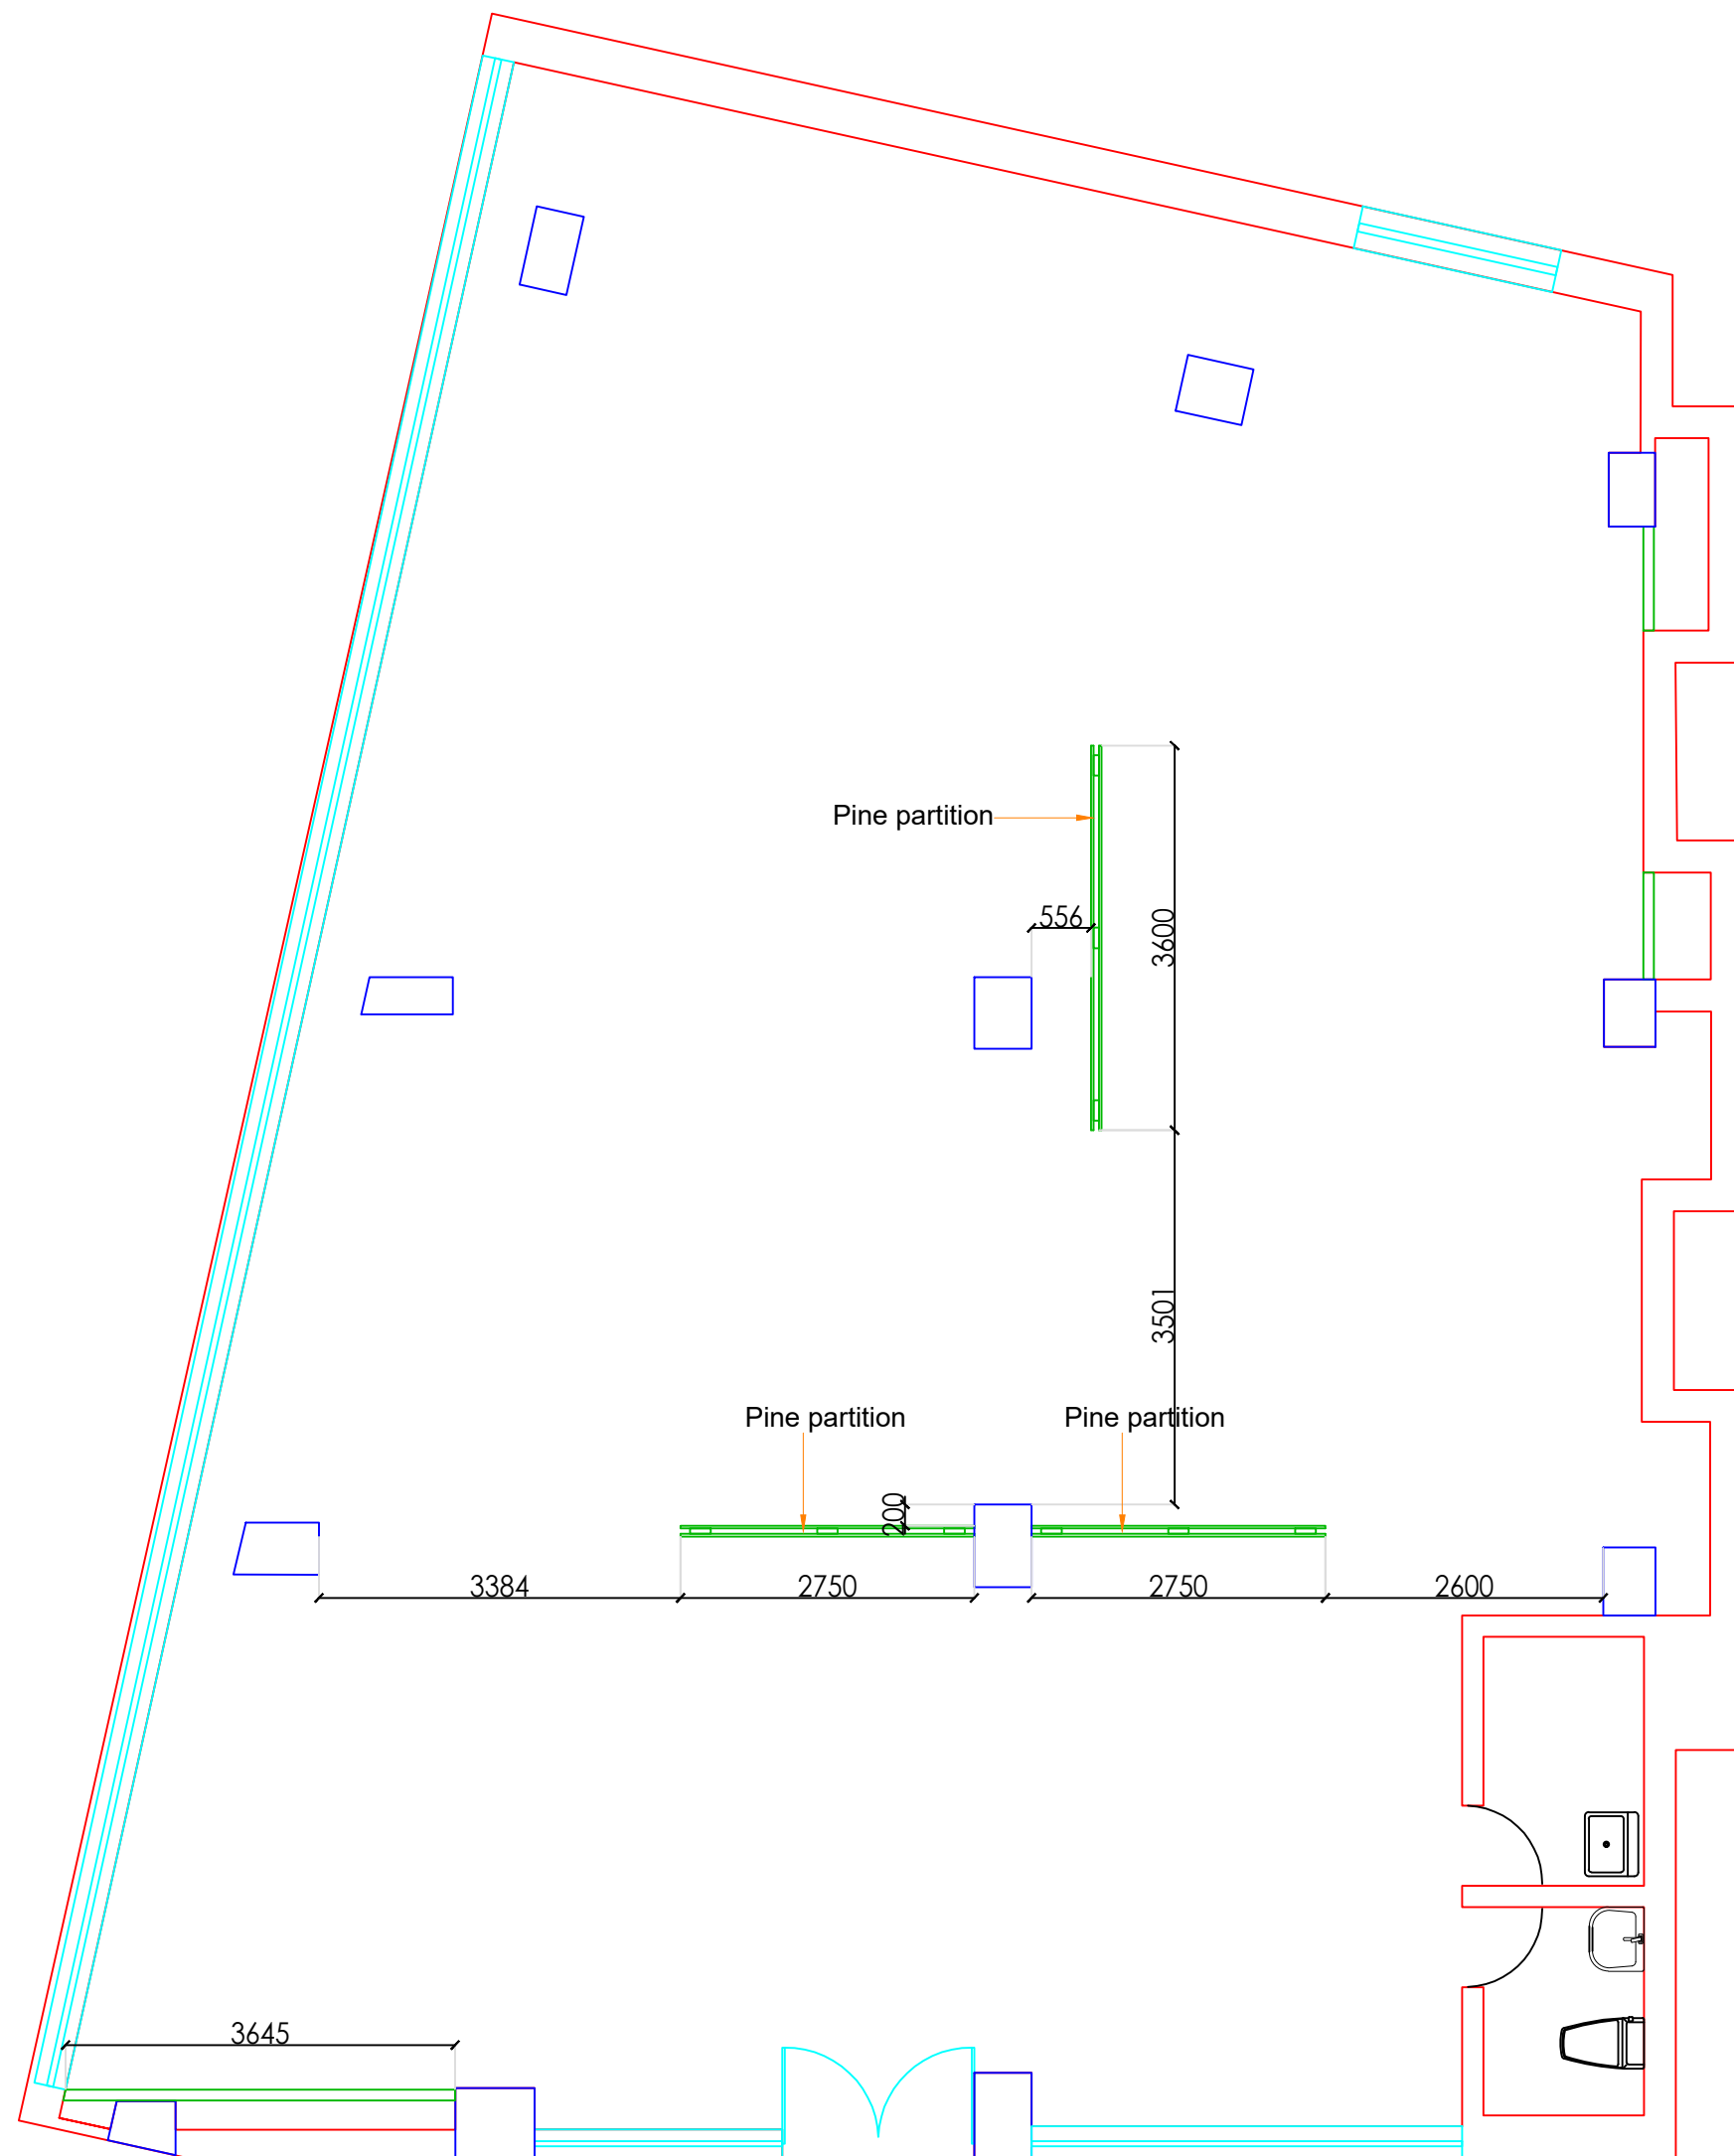



DESCRIPTION :

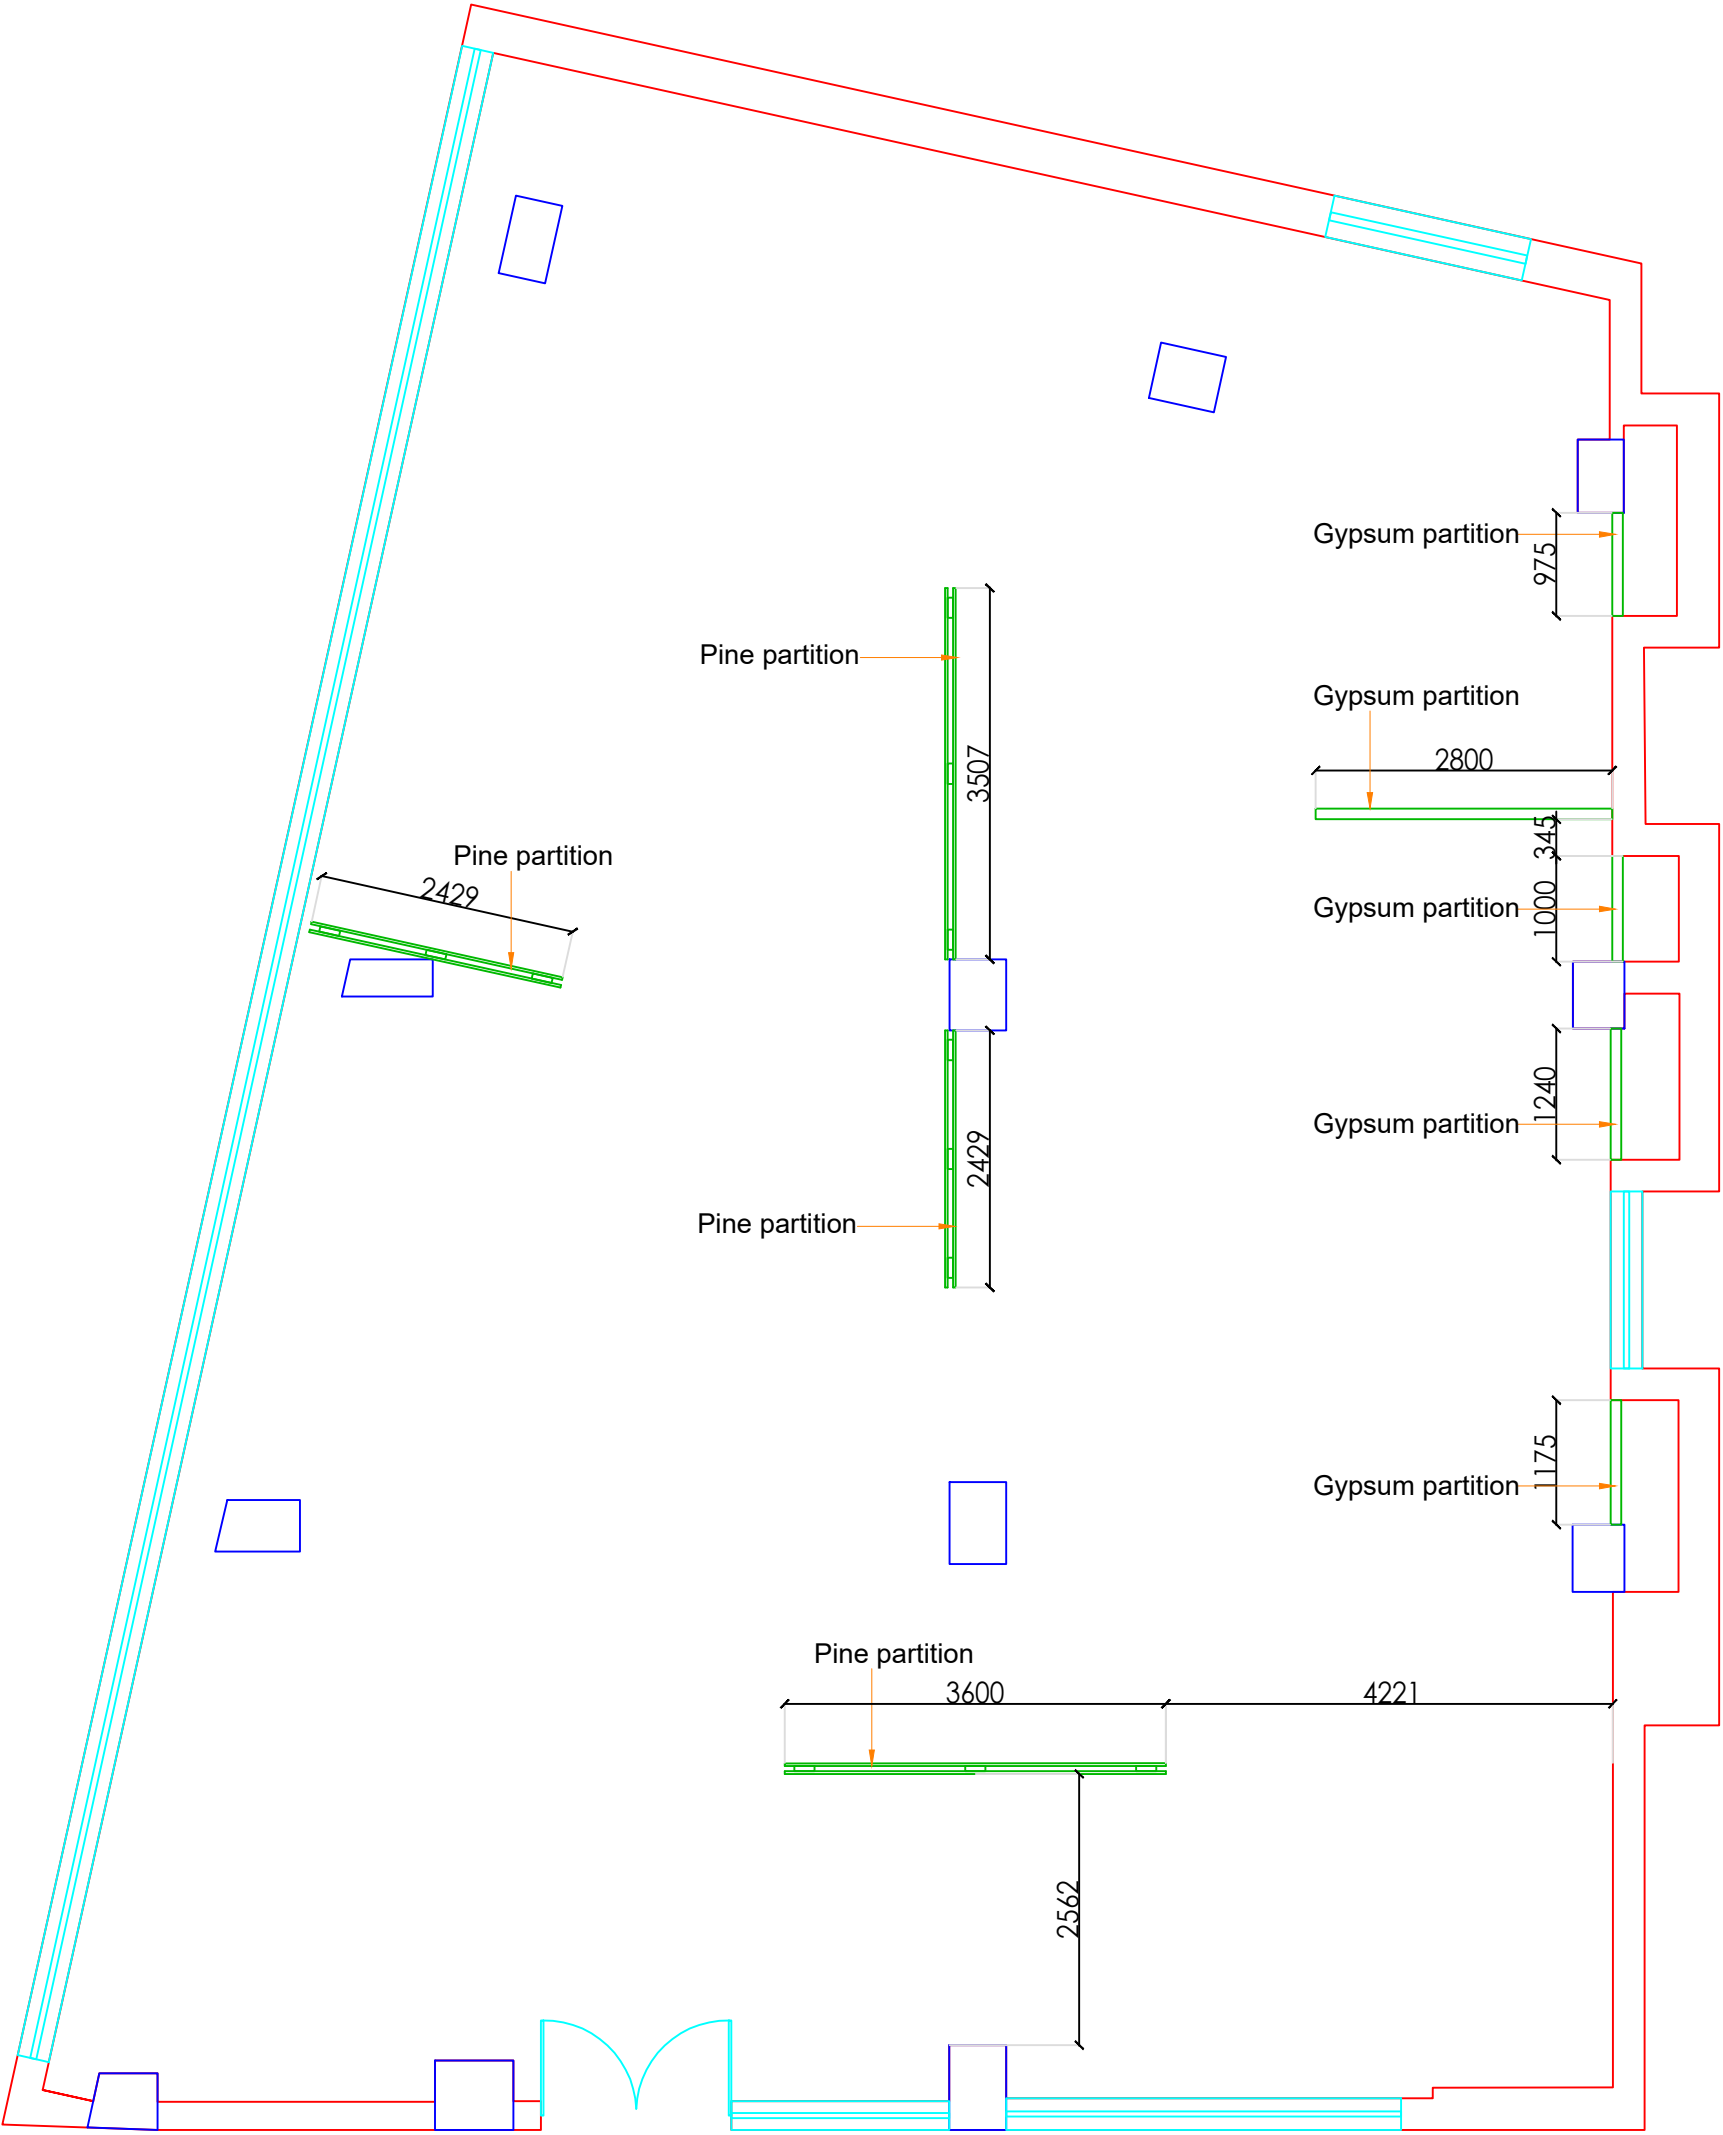


Site Name :
Guwahati

Layout : Second floor
Sofa section
Partition Layout

Area:
7175.83 sft

NOTE :
Sofa Sets - 16nos.
Dining Set - 03nos.

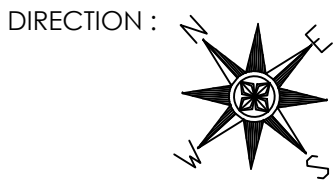

FORMAT : A3
DRAWN BY : Jigar Panchal
DATE: 19-12-2023
DATE OF EDIT:




DESCRIPTION :

Site Name :
Guwahati


Layout : Second Floor
Bed Section Partition
Layout

Area:
7175.83 sft

NOTE :
Beds - 11nos.
Office table - 02nos

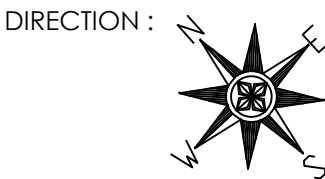

FORMAT : A3
DRAWN BY : Jigar Panchal
DATE: 19-12-2023
DATE OF EDIT:

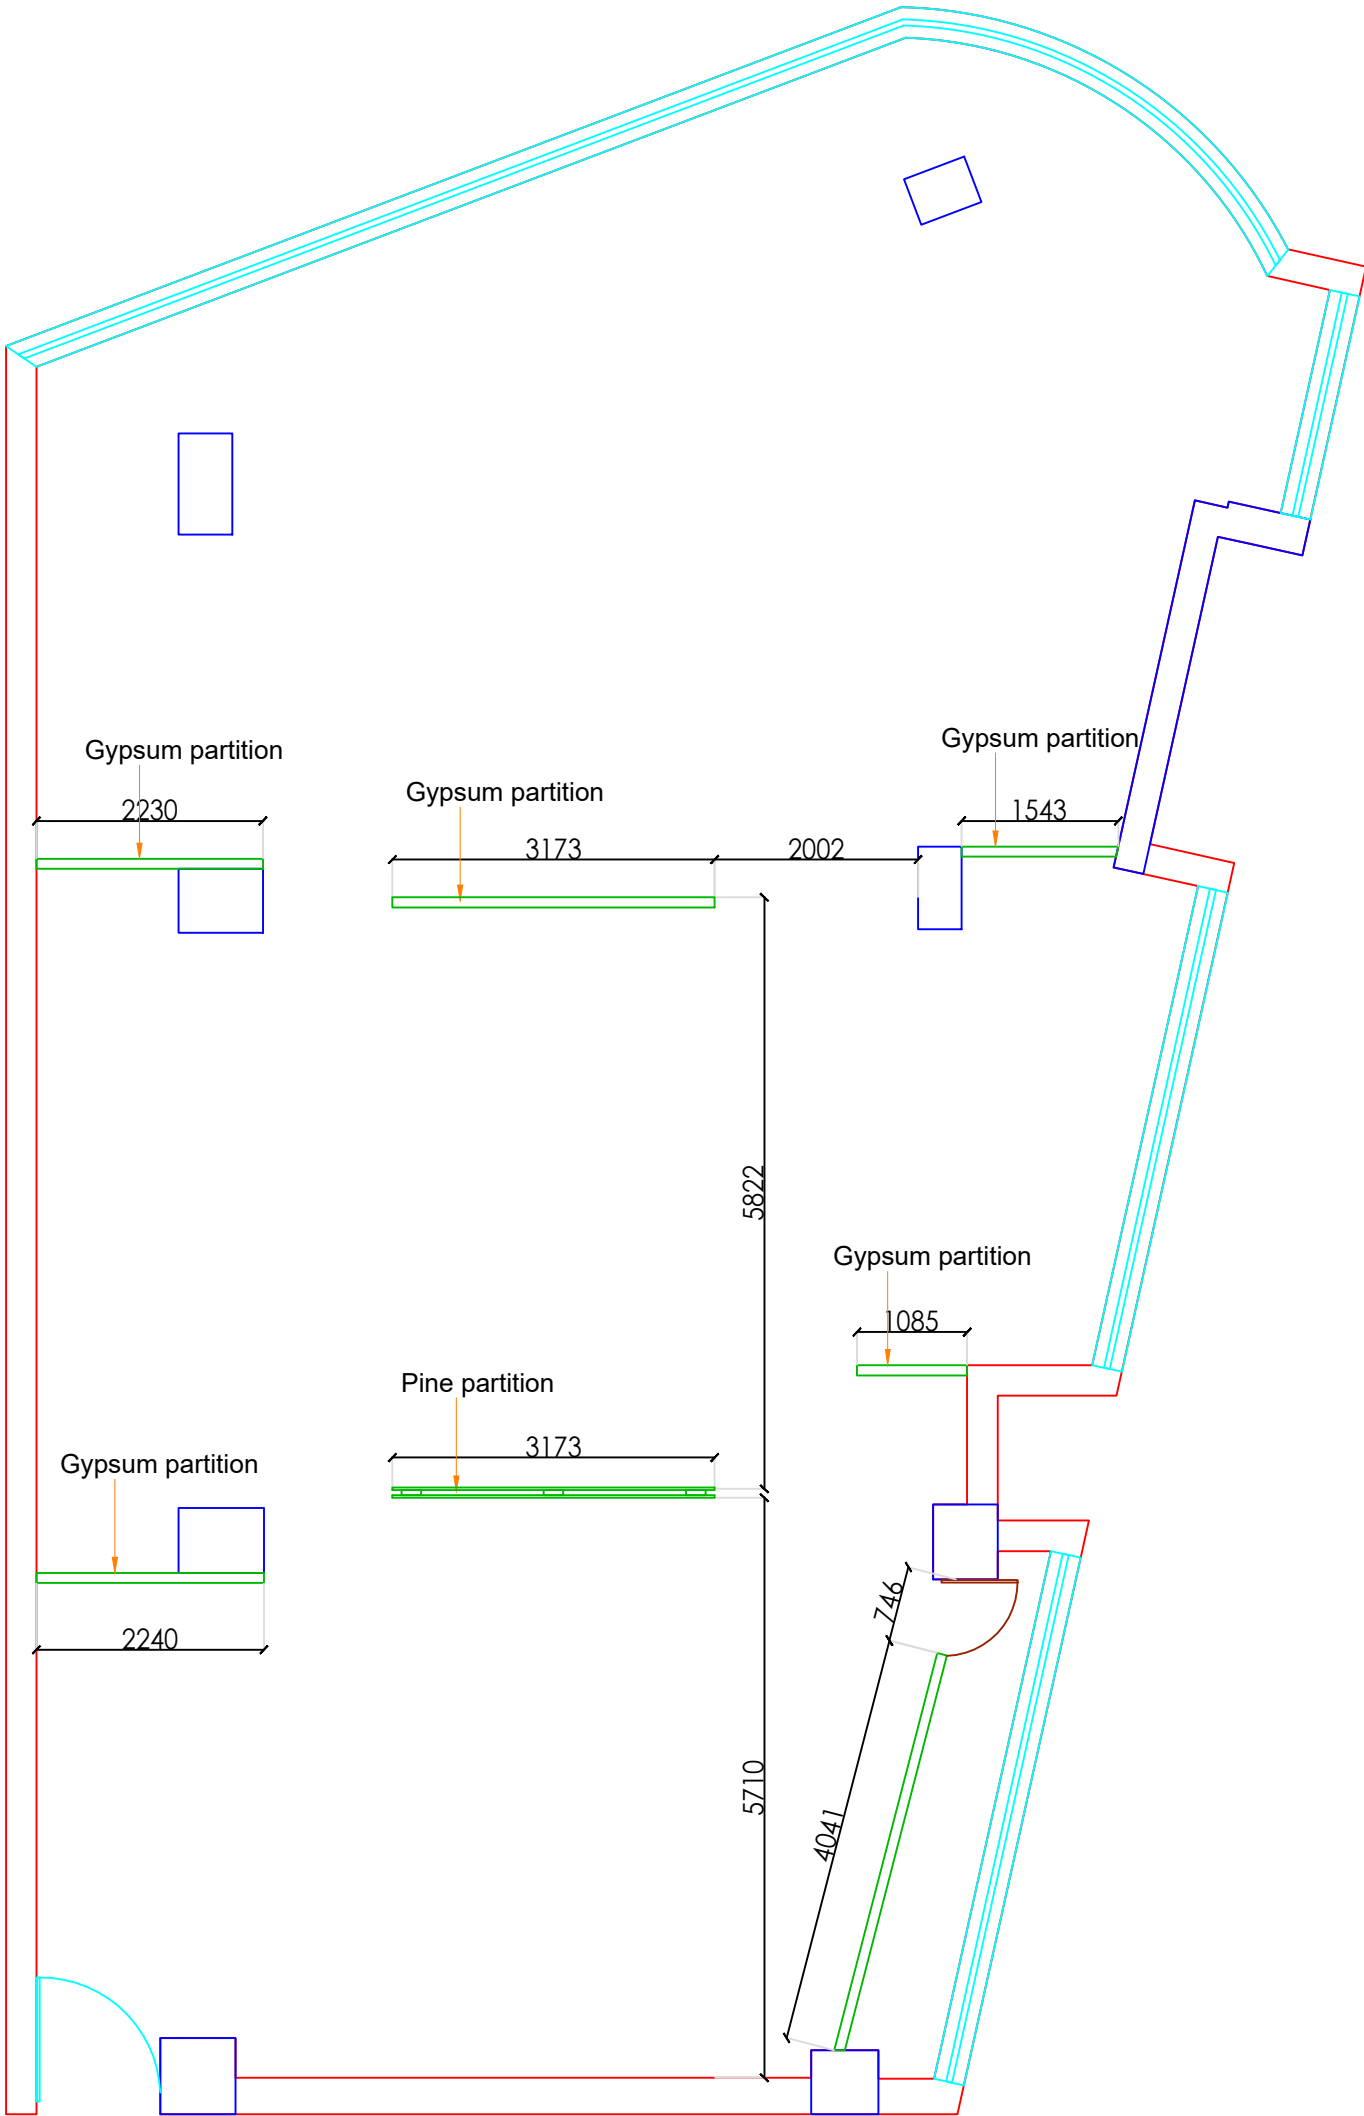



DESCRIPTION :

Site Name :
Guwahati

Layout : First floor
Sofa section Power
Layout

Area:
7175.83 sft

NOTE :
Sofa Sets - 14nos.
Dining Set - 02nos.

DIRECTION :




FORMAT : A3

DRAWN BY : Jigar Panchal

DATE: 19-12-2023

DATE OF EDIT:

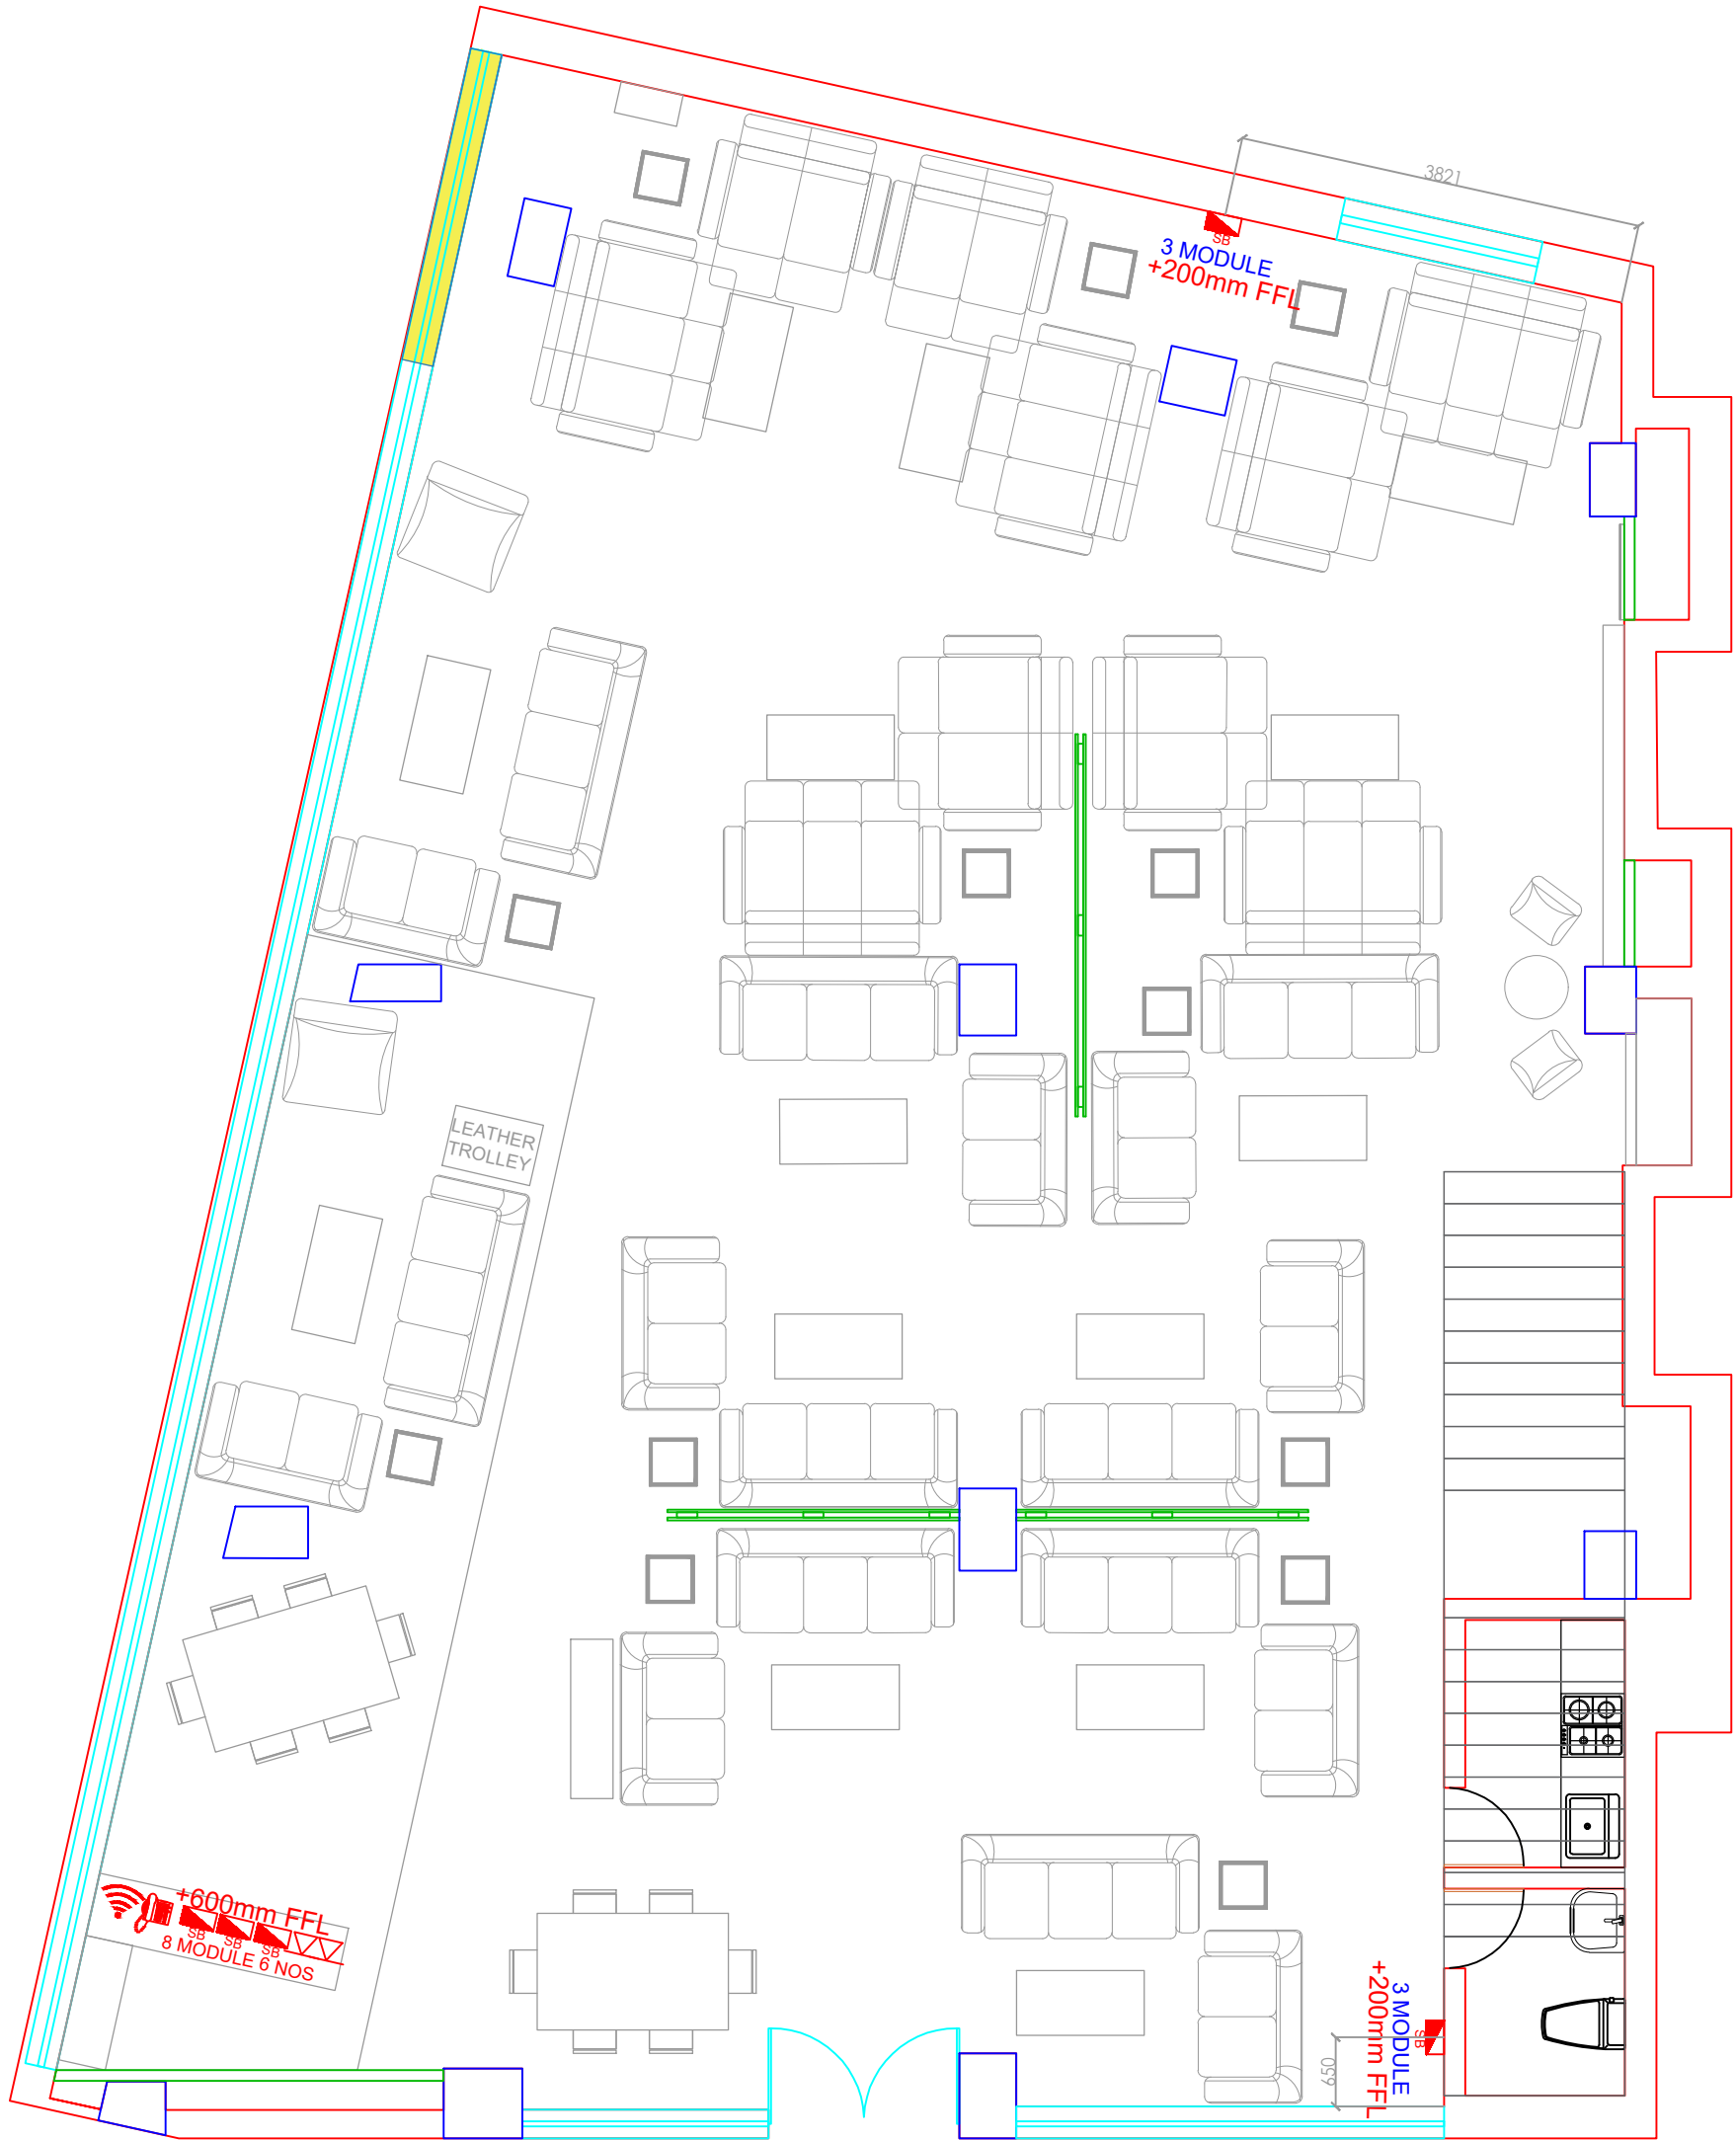




DESCRIPTION :

Site Name :
Guwahati


Layout : Second floor
Sofa section
Power Layout

Area:
7175.83 sft

NOTE :
Sofa Sets - 16nos.
Dining Set - 03nos.

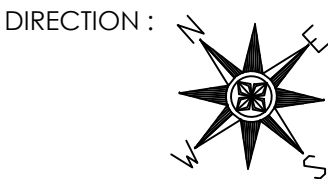

FORMAT : A3
DRAWN BY : Jigar Panchal
DATE: 19-12-2023
DATE OF EDIT:

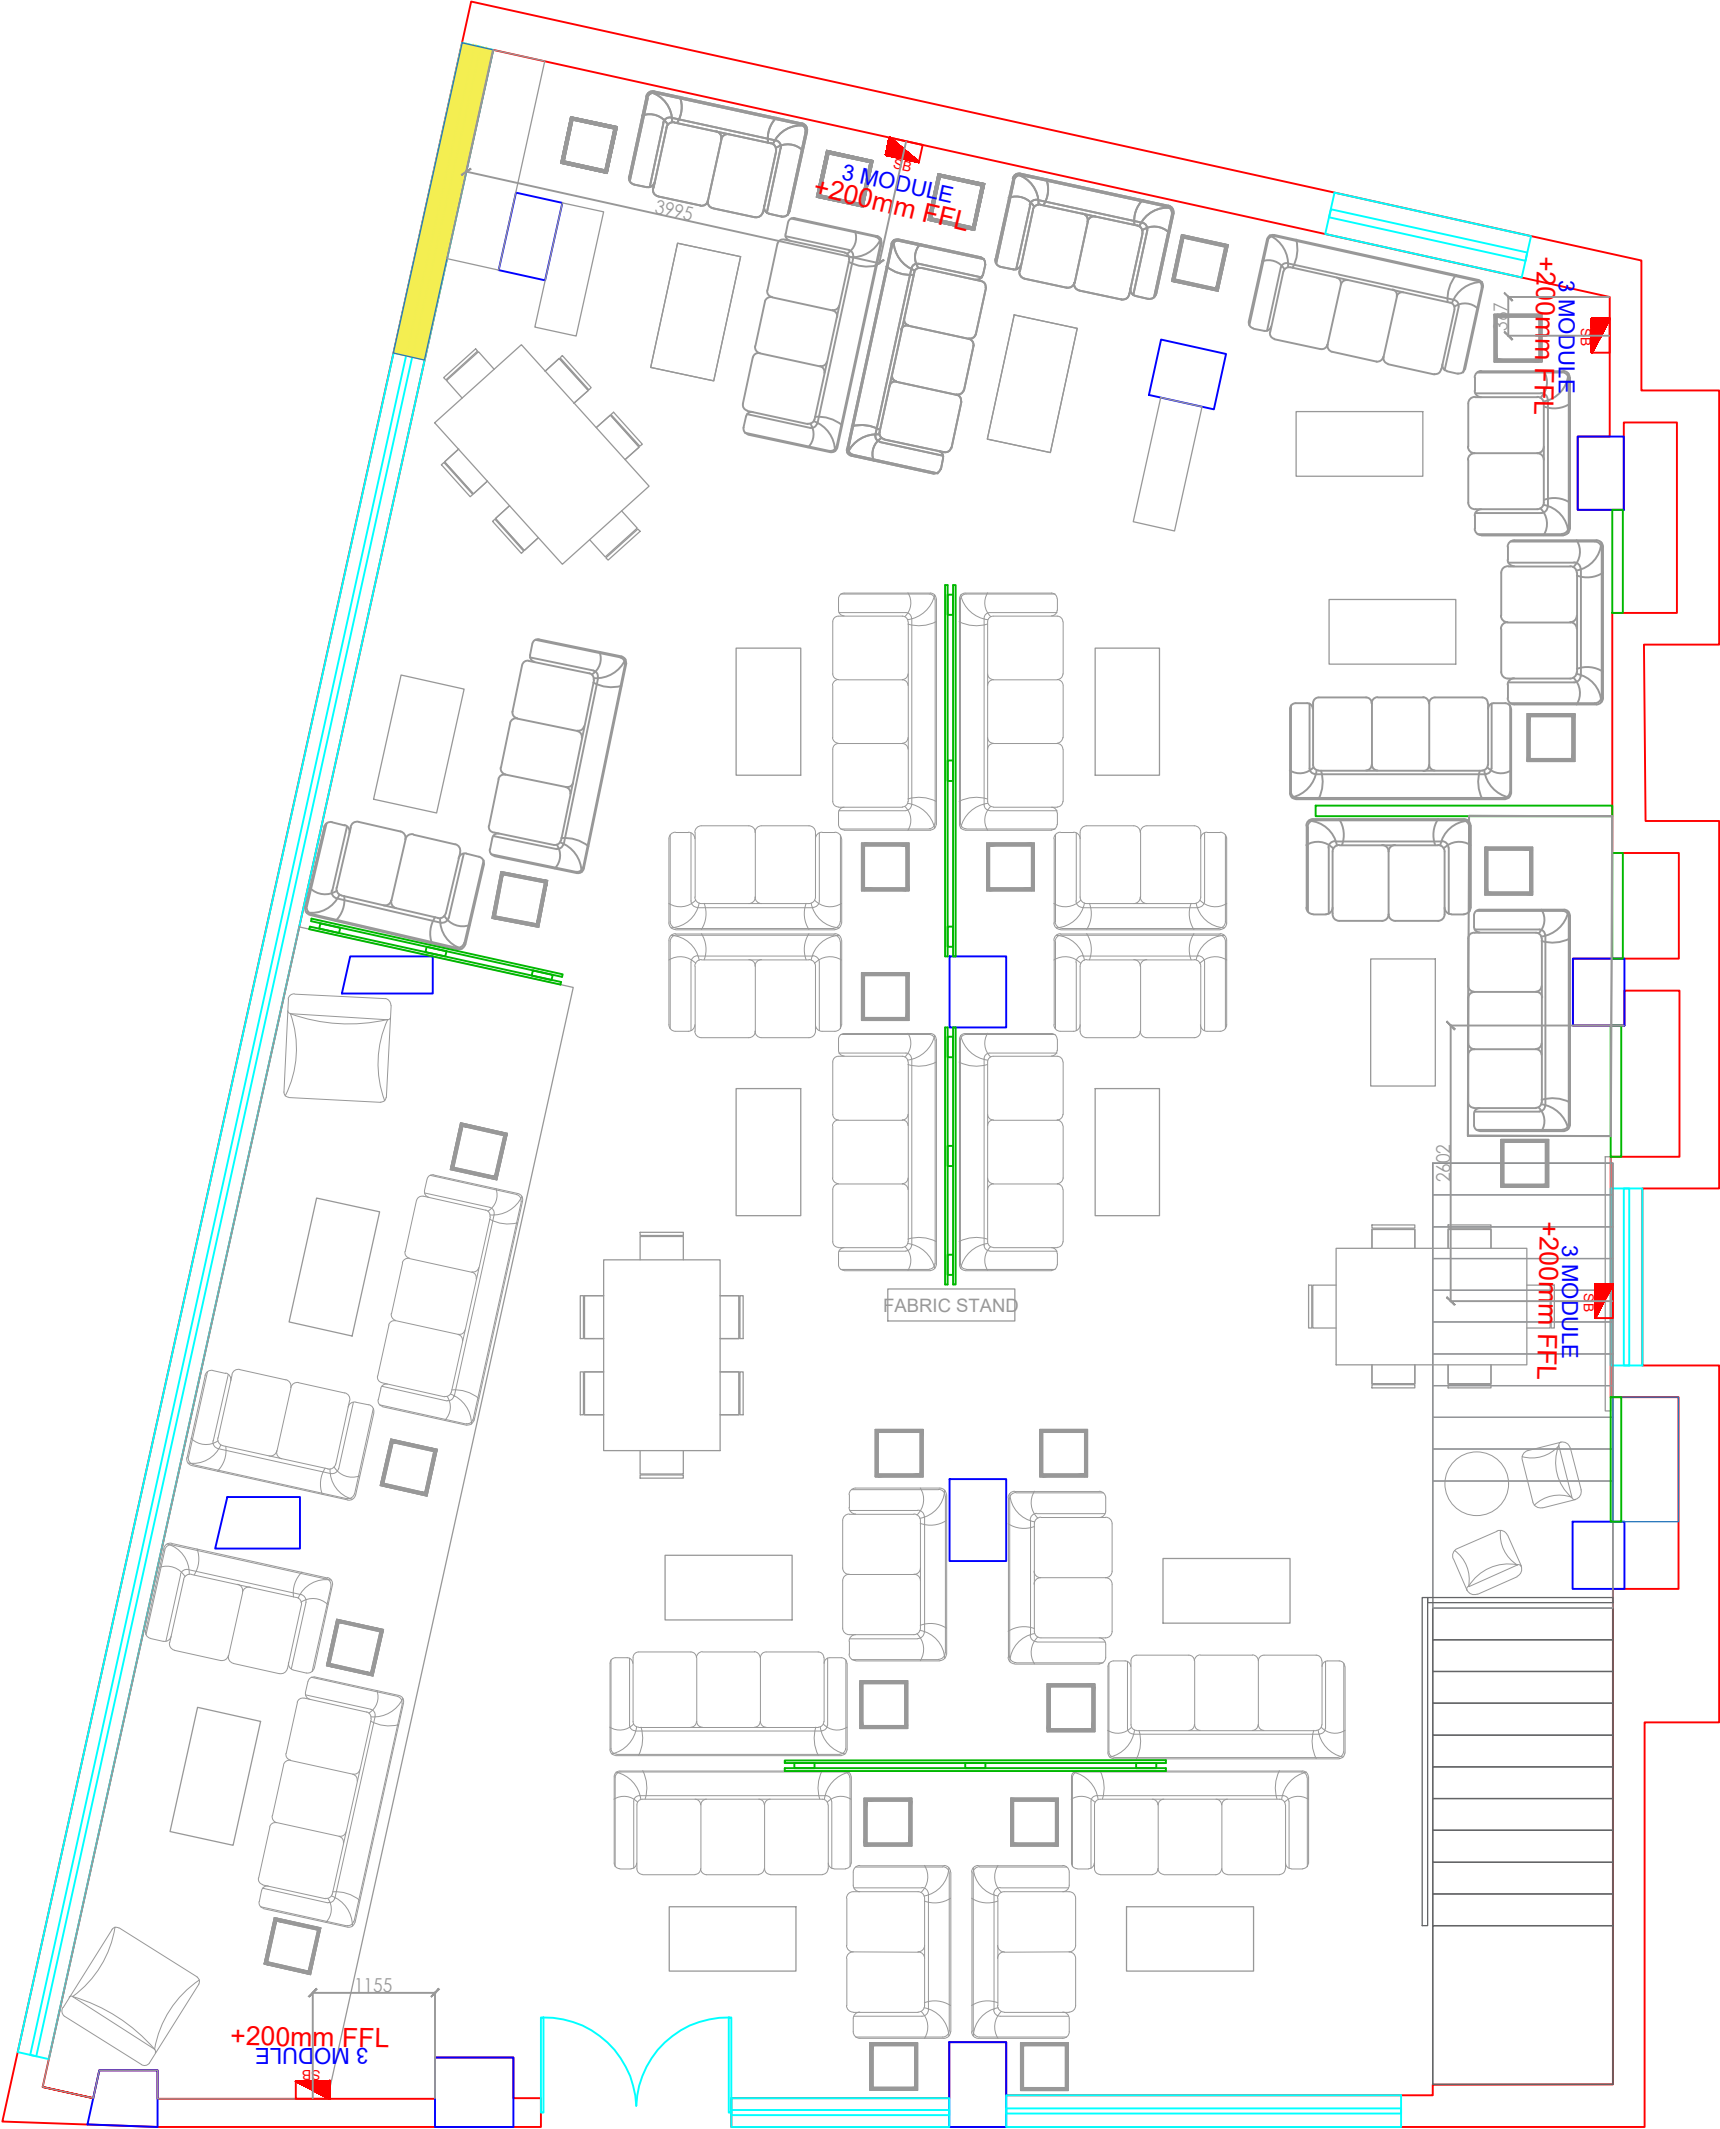



DESCRIPTION :

Site Name :
Guwahati

Layout : Second Floor
Bed Section Power
Layout

Area:
7175.83 sft

NOTE :
Beds - 11nos.
Office table - 02nos

DIRECTION :





FORMAT : A3

DRAWN BY : Jigar Panchal

DATE: 19-12-2023

DATE OF EDIT:

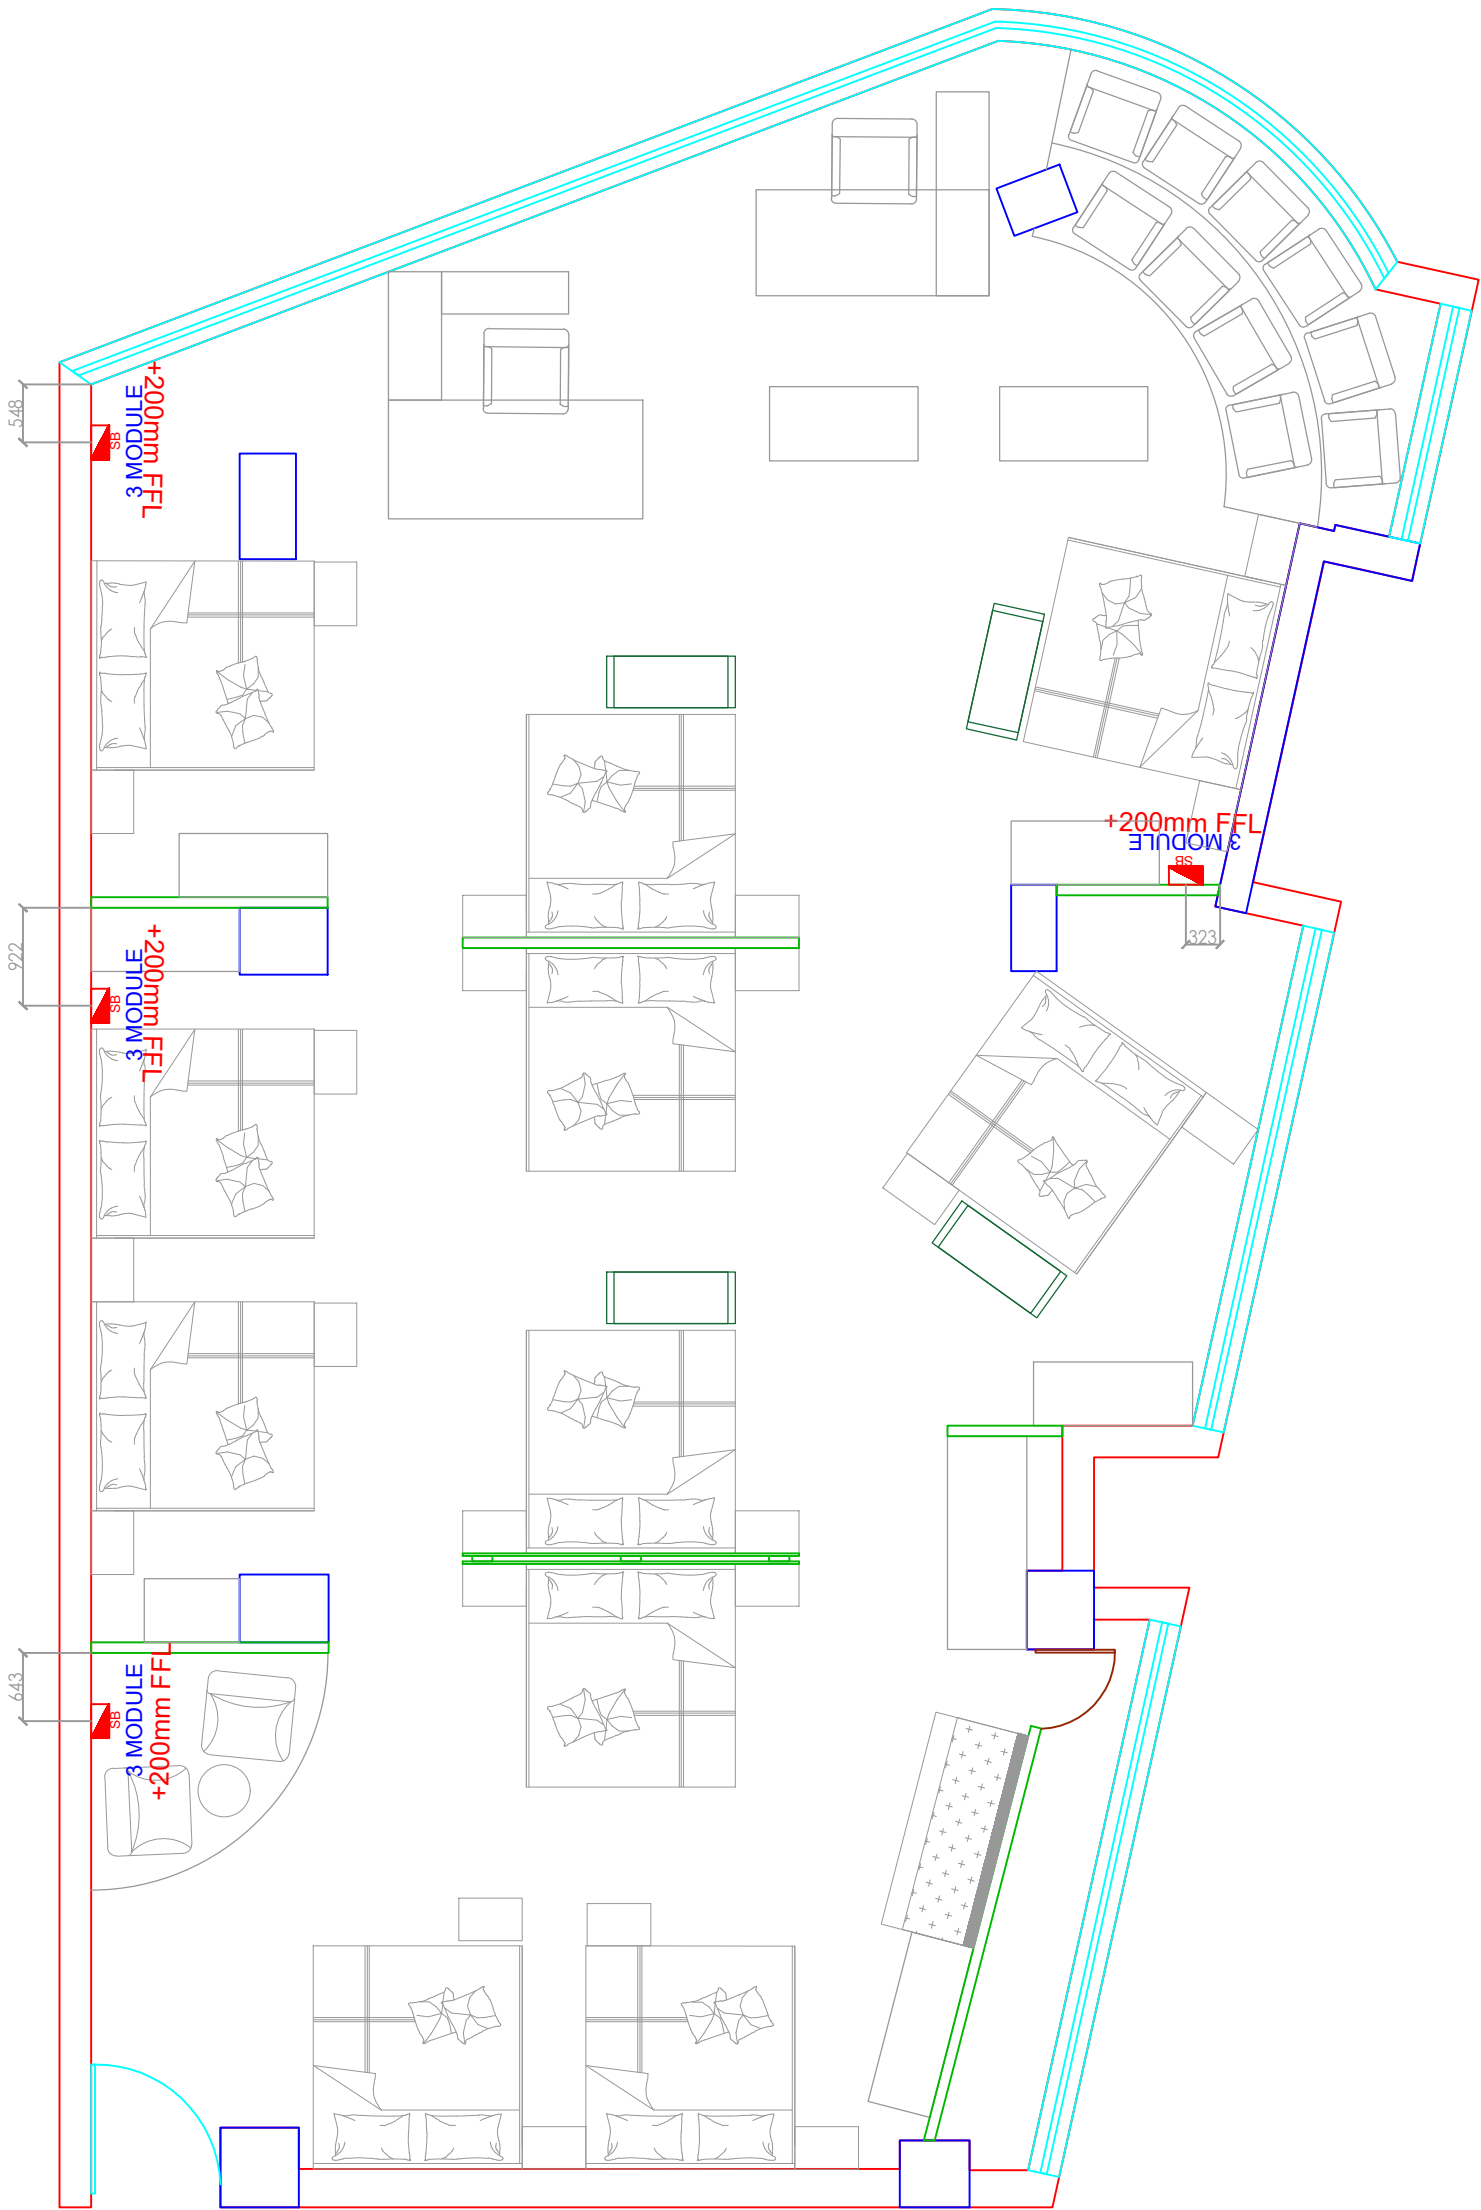

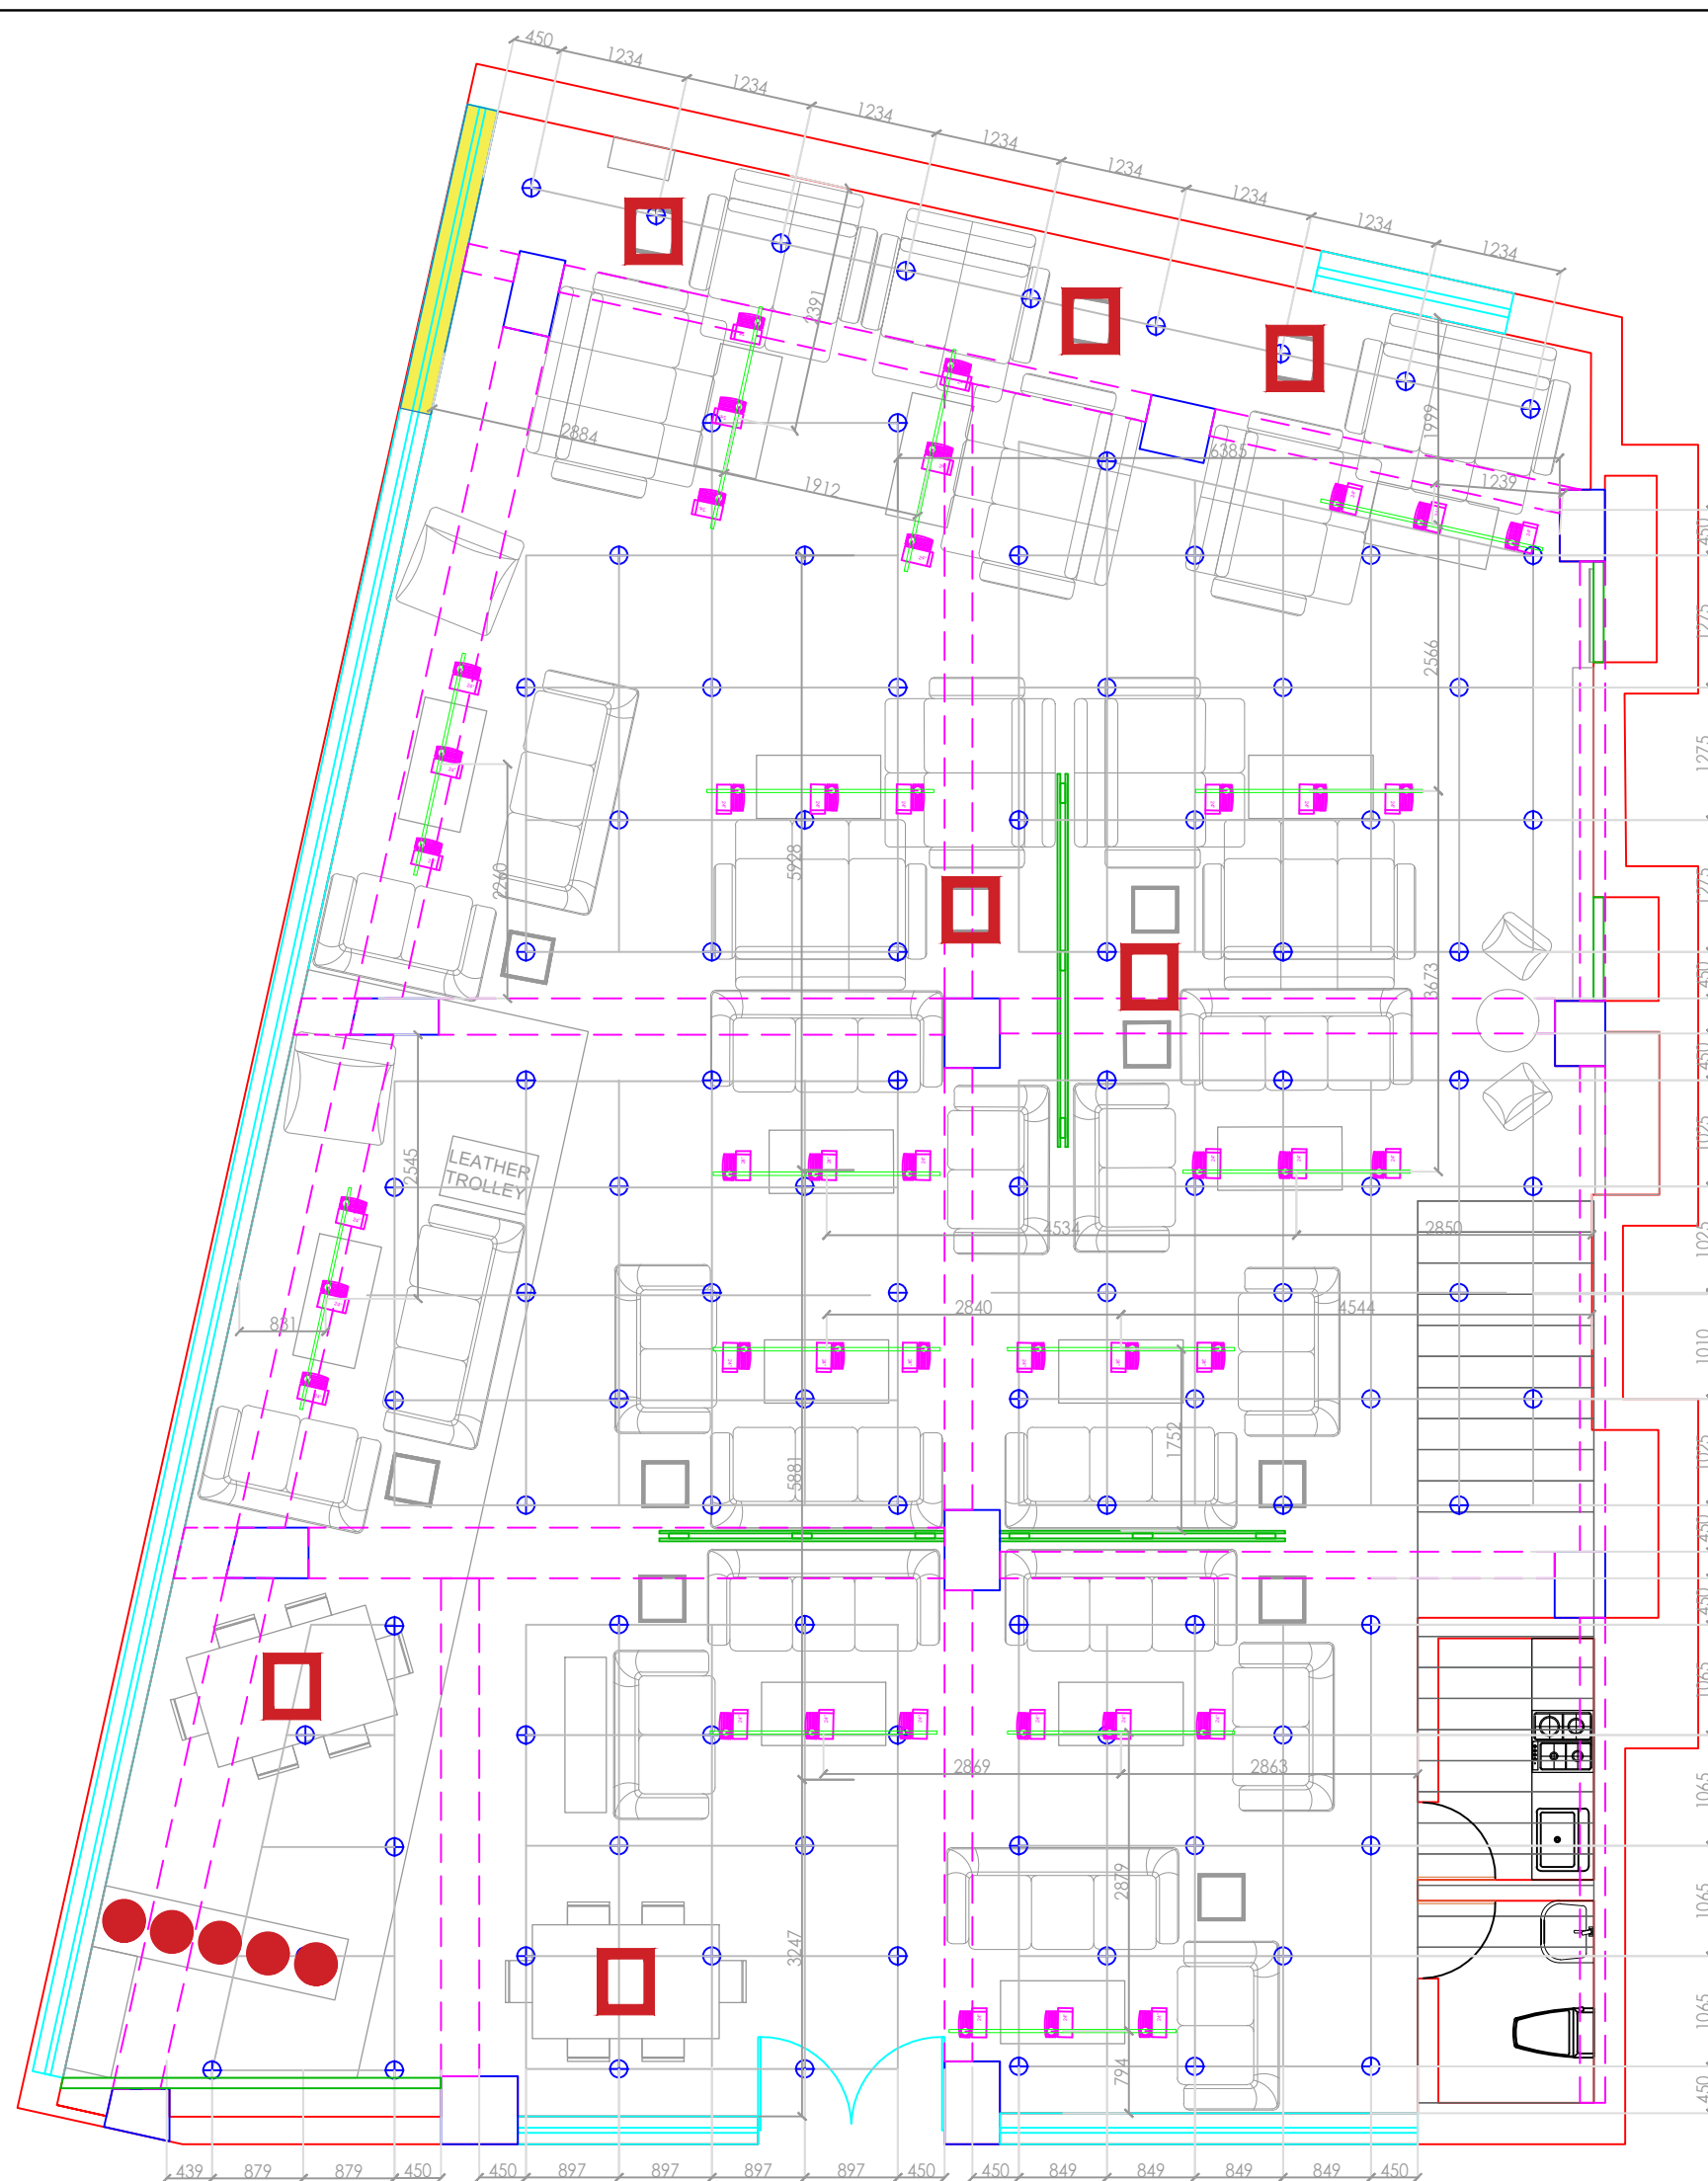

DATE OF EDIT:



DESCRIPTION :

Site Name :
Guwahati

Layout : Second floor
Sofa section RCP
Layout

Area:
7175.83 sft

NOTE :
Sofa Sets - 16nos.
Dining Set - 03nos.

DIRECTION :




FORMAT : A3

DRAWN BY : Jigar Panchal

DATE: 19-12-2023

DATE OF EDIT:

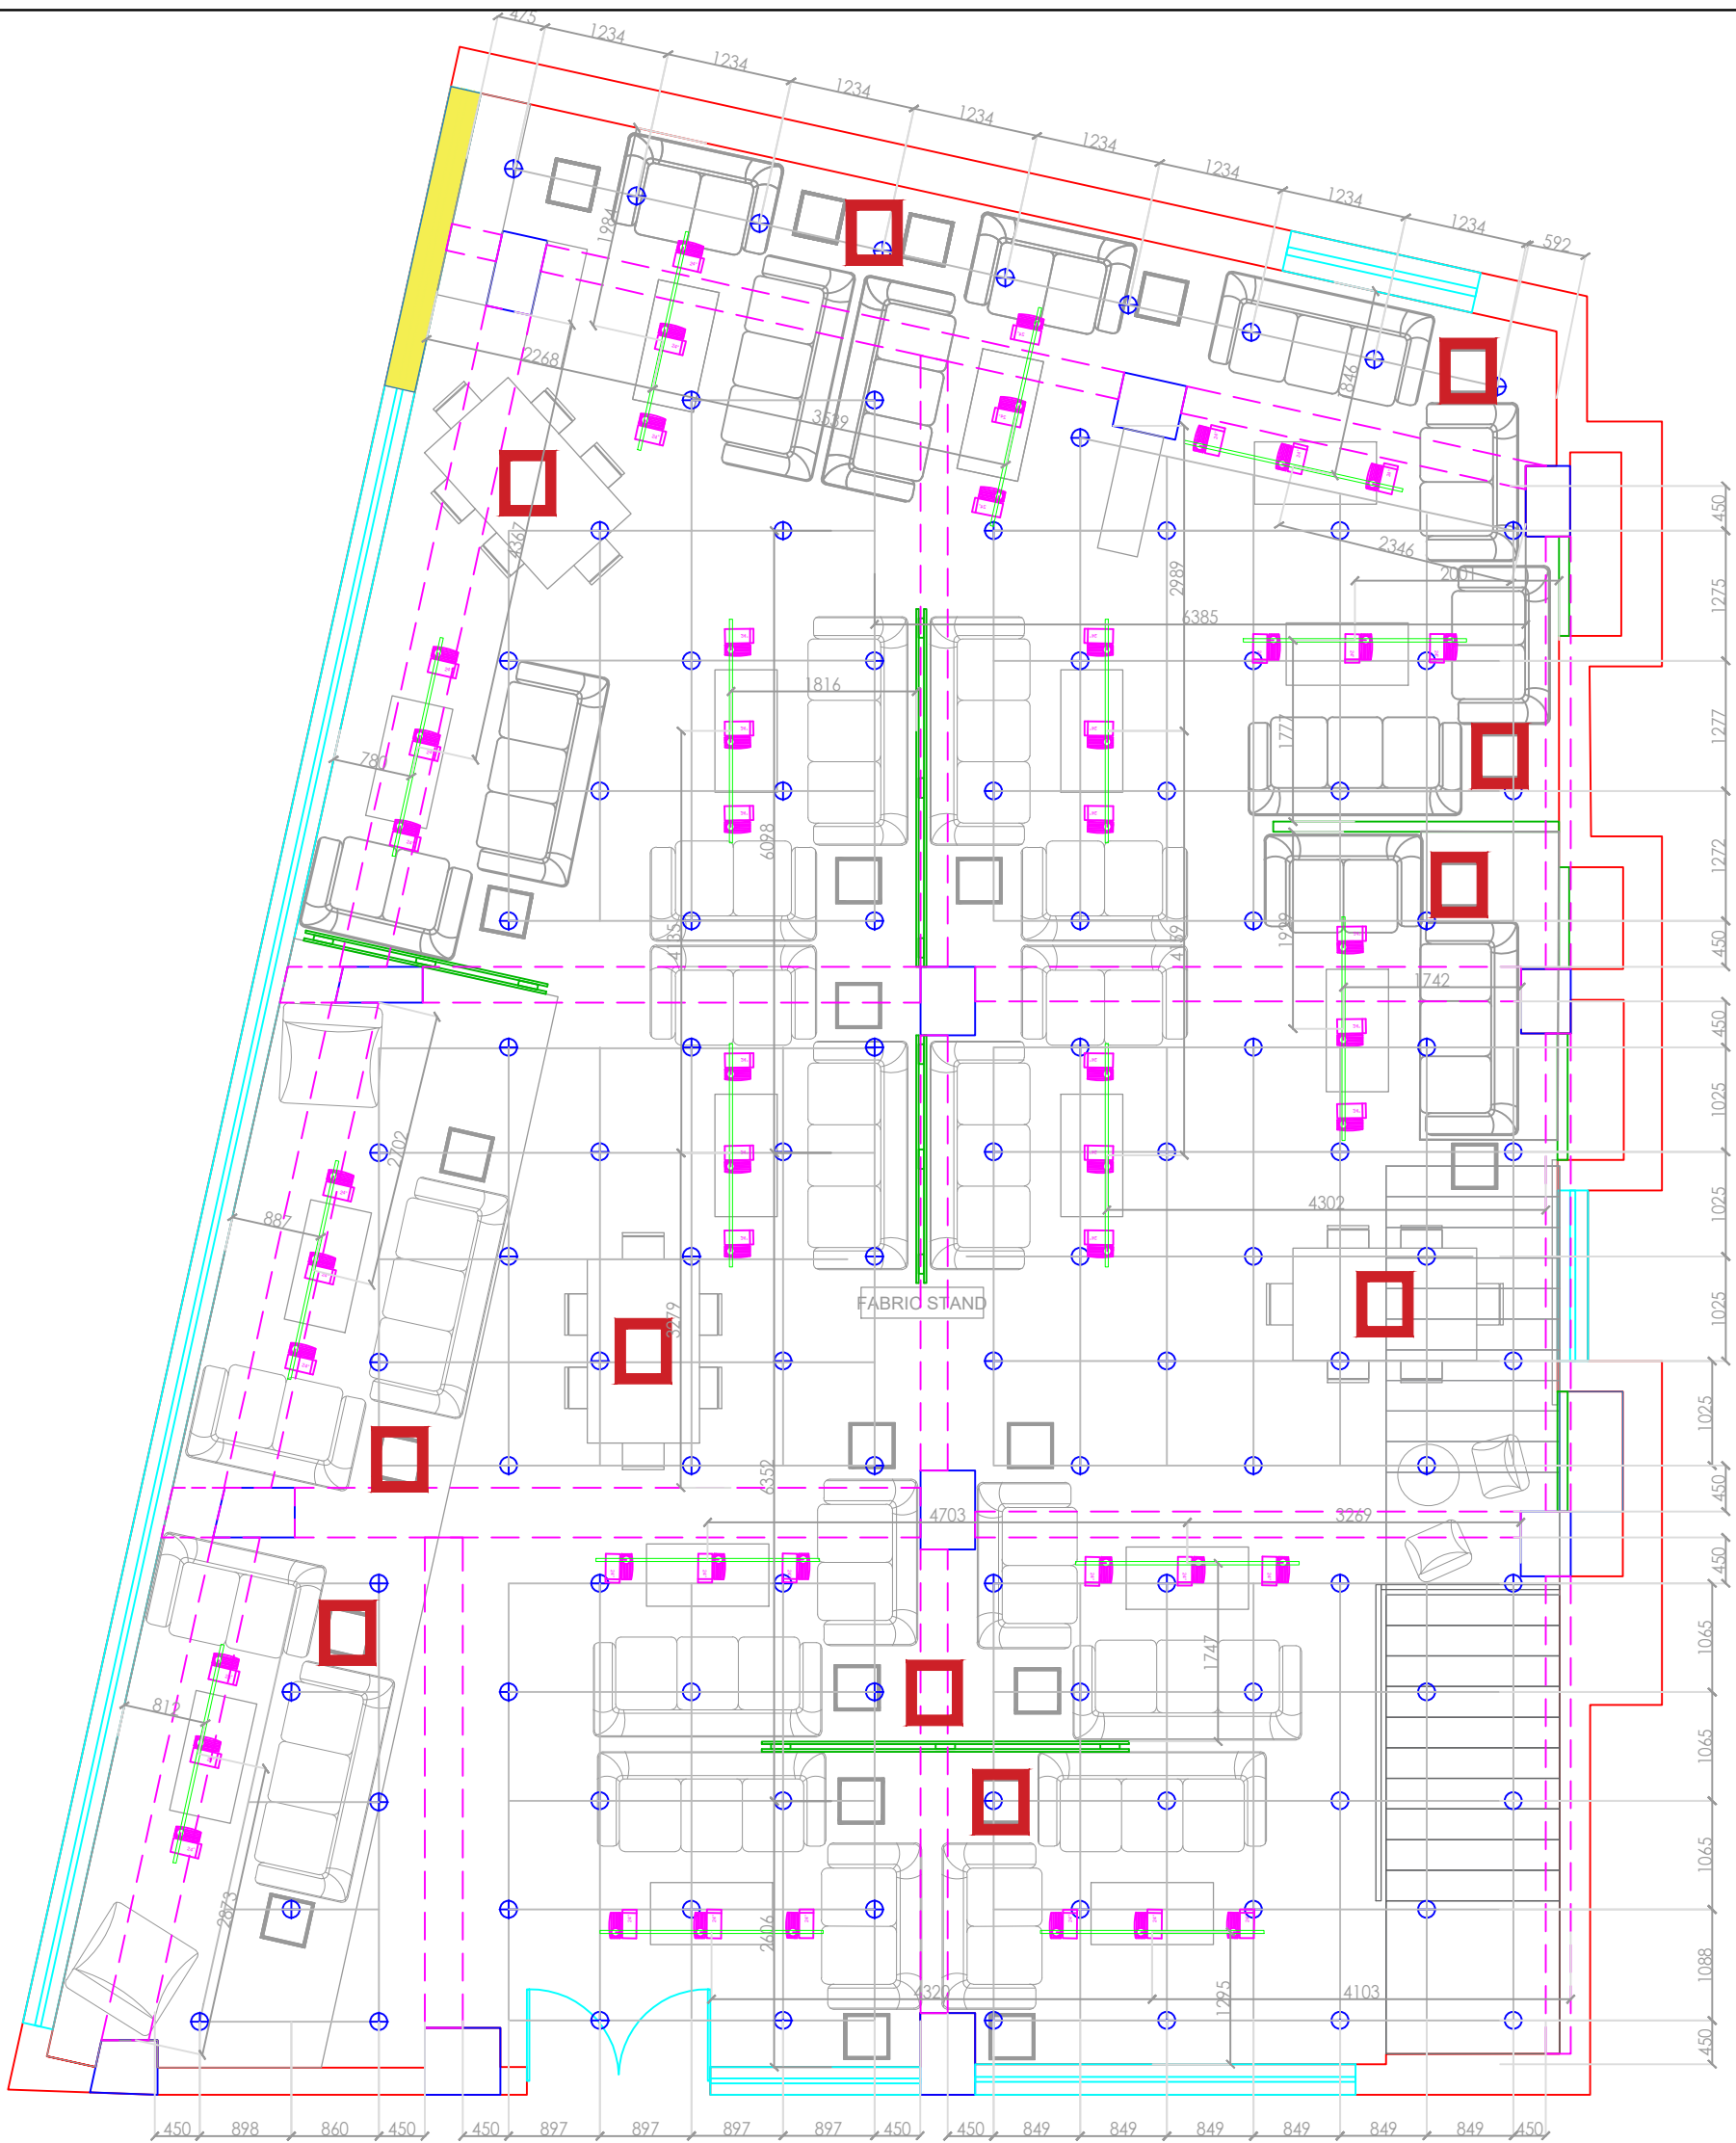



DESCRIPTION :

Site Name :
Guwahati

Layout : Second Floor
Bed Section RCP
Layout

Area:
7175.83 sft

NOTE :
Beds - 11 nos.
Office table - 02nos

DIRECTION :




FORMAT : A3

DRAWN BY : Jigar Panchal

DATE: 19-12-2023

DATE OF EDIT:

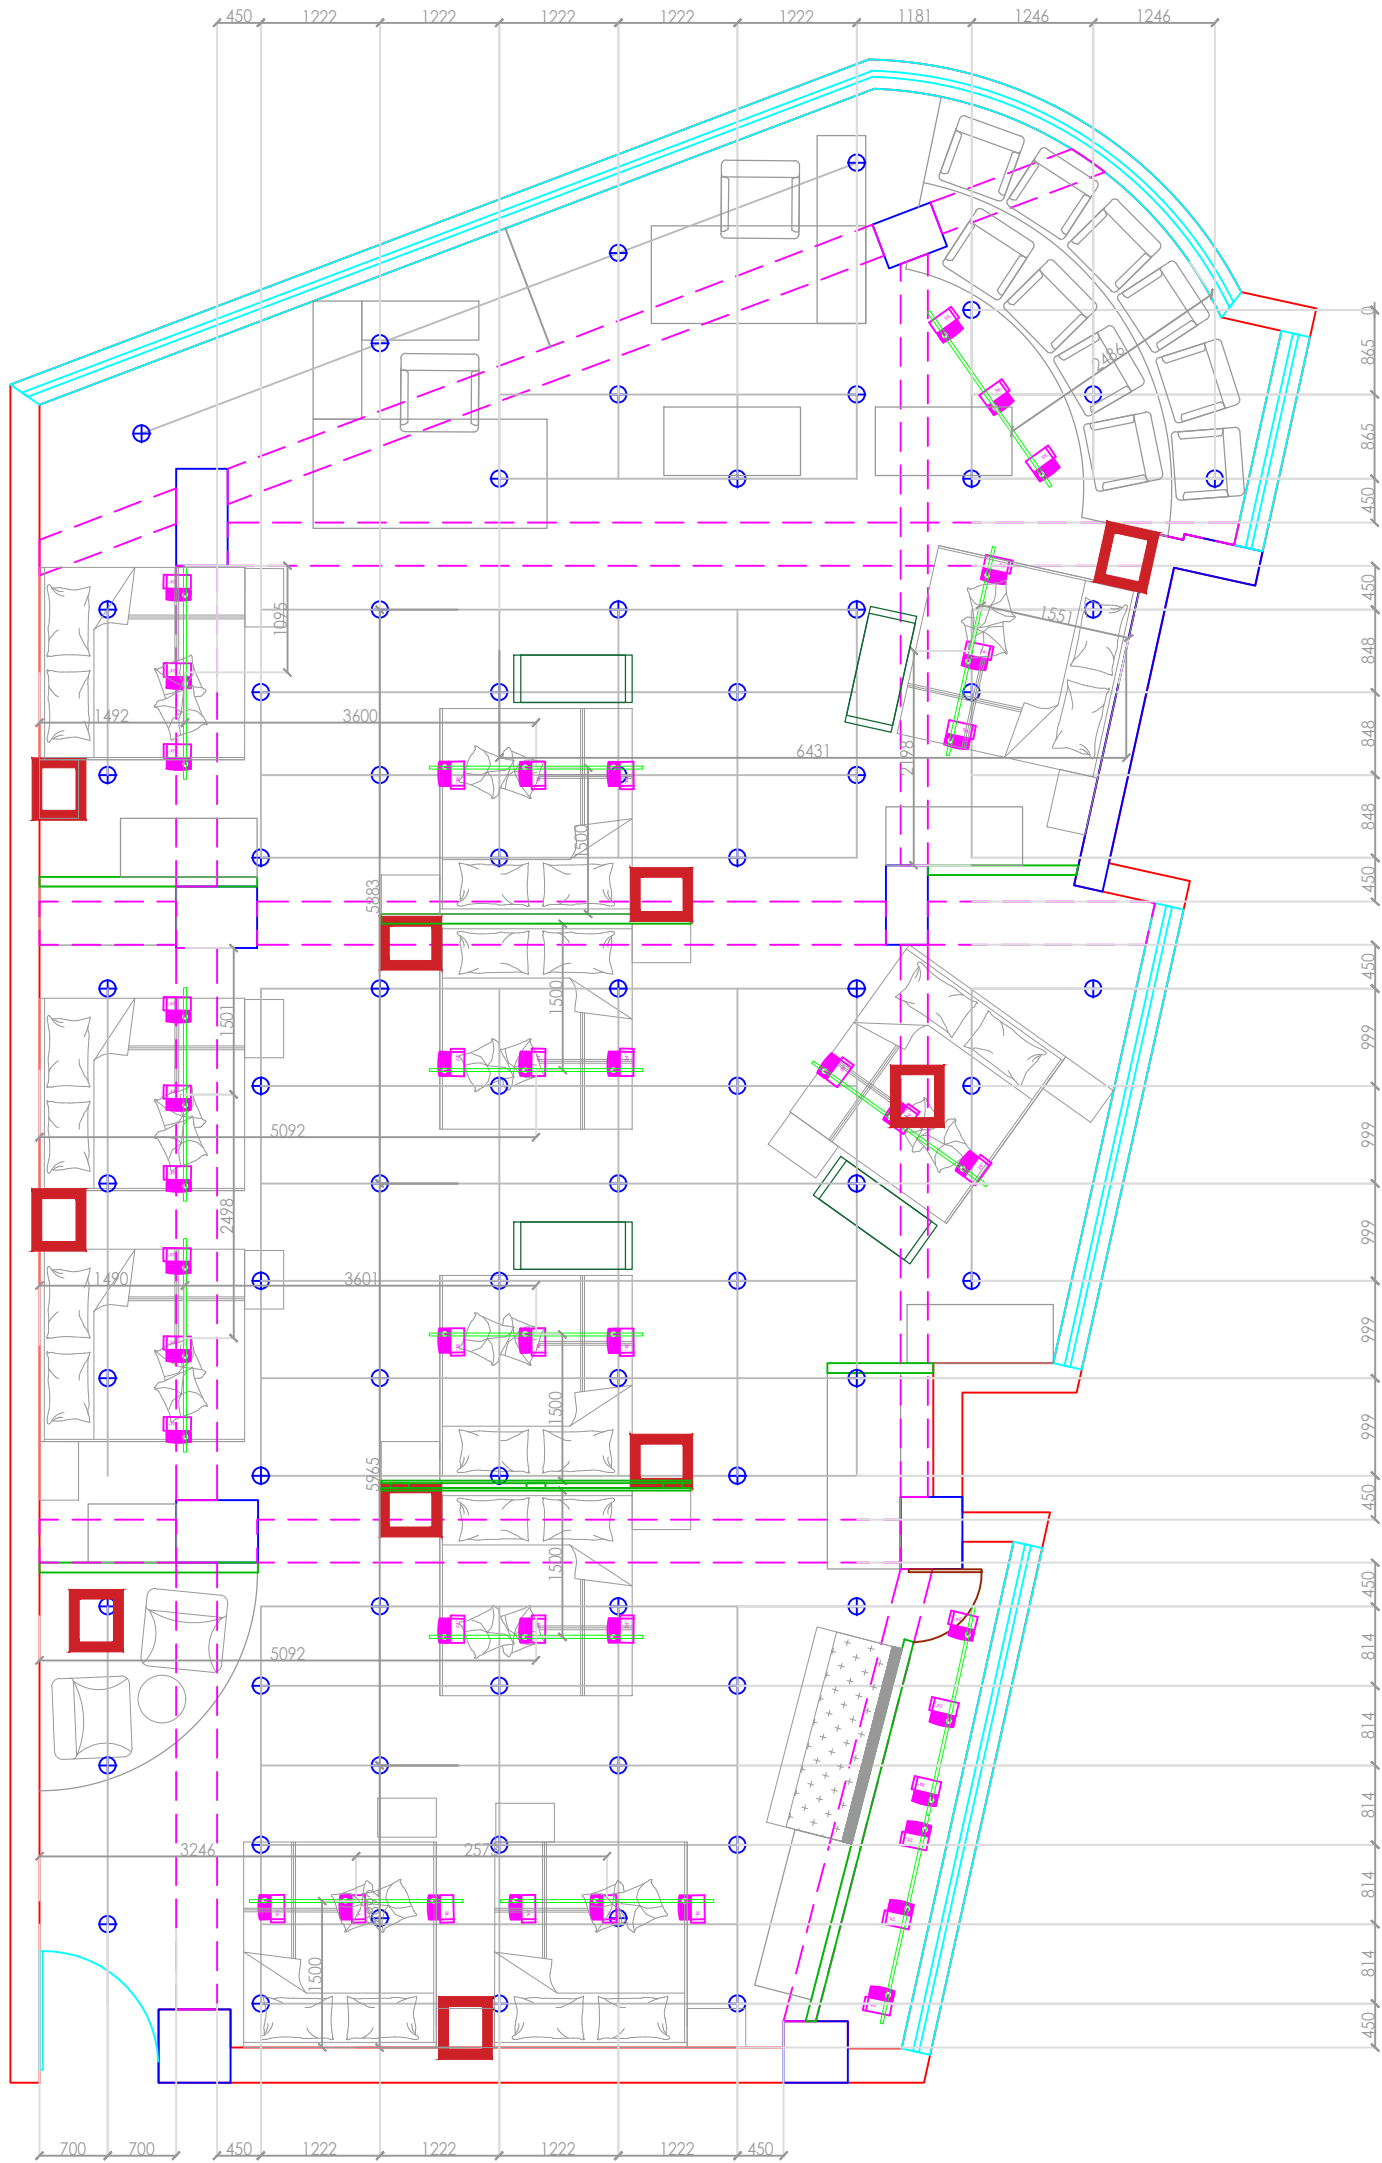




DESCRIPTION :

Site Name :
Guwahati


Layout : First floor
Sofa section VM
Hanging Lights Layout

Area:
7175.83 sft

NOTE :
Sofa Sets - 14nos.
Dining Set - 02nos.

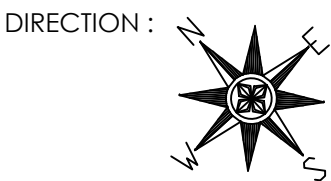

FORMAT : A3
DRAWN BY : Jigar Panchal
DATE: 19-12-2023
DATE OF EDIT:

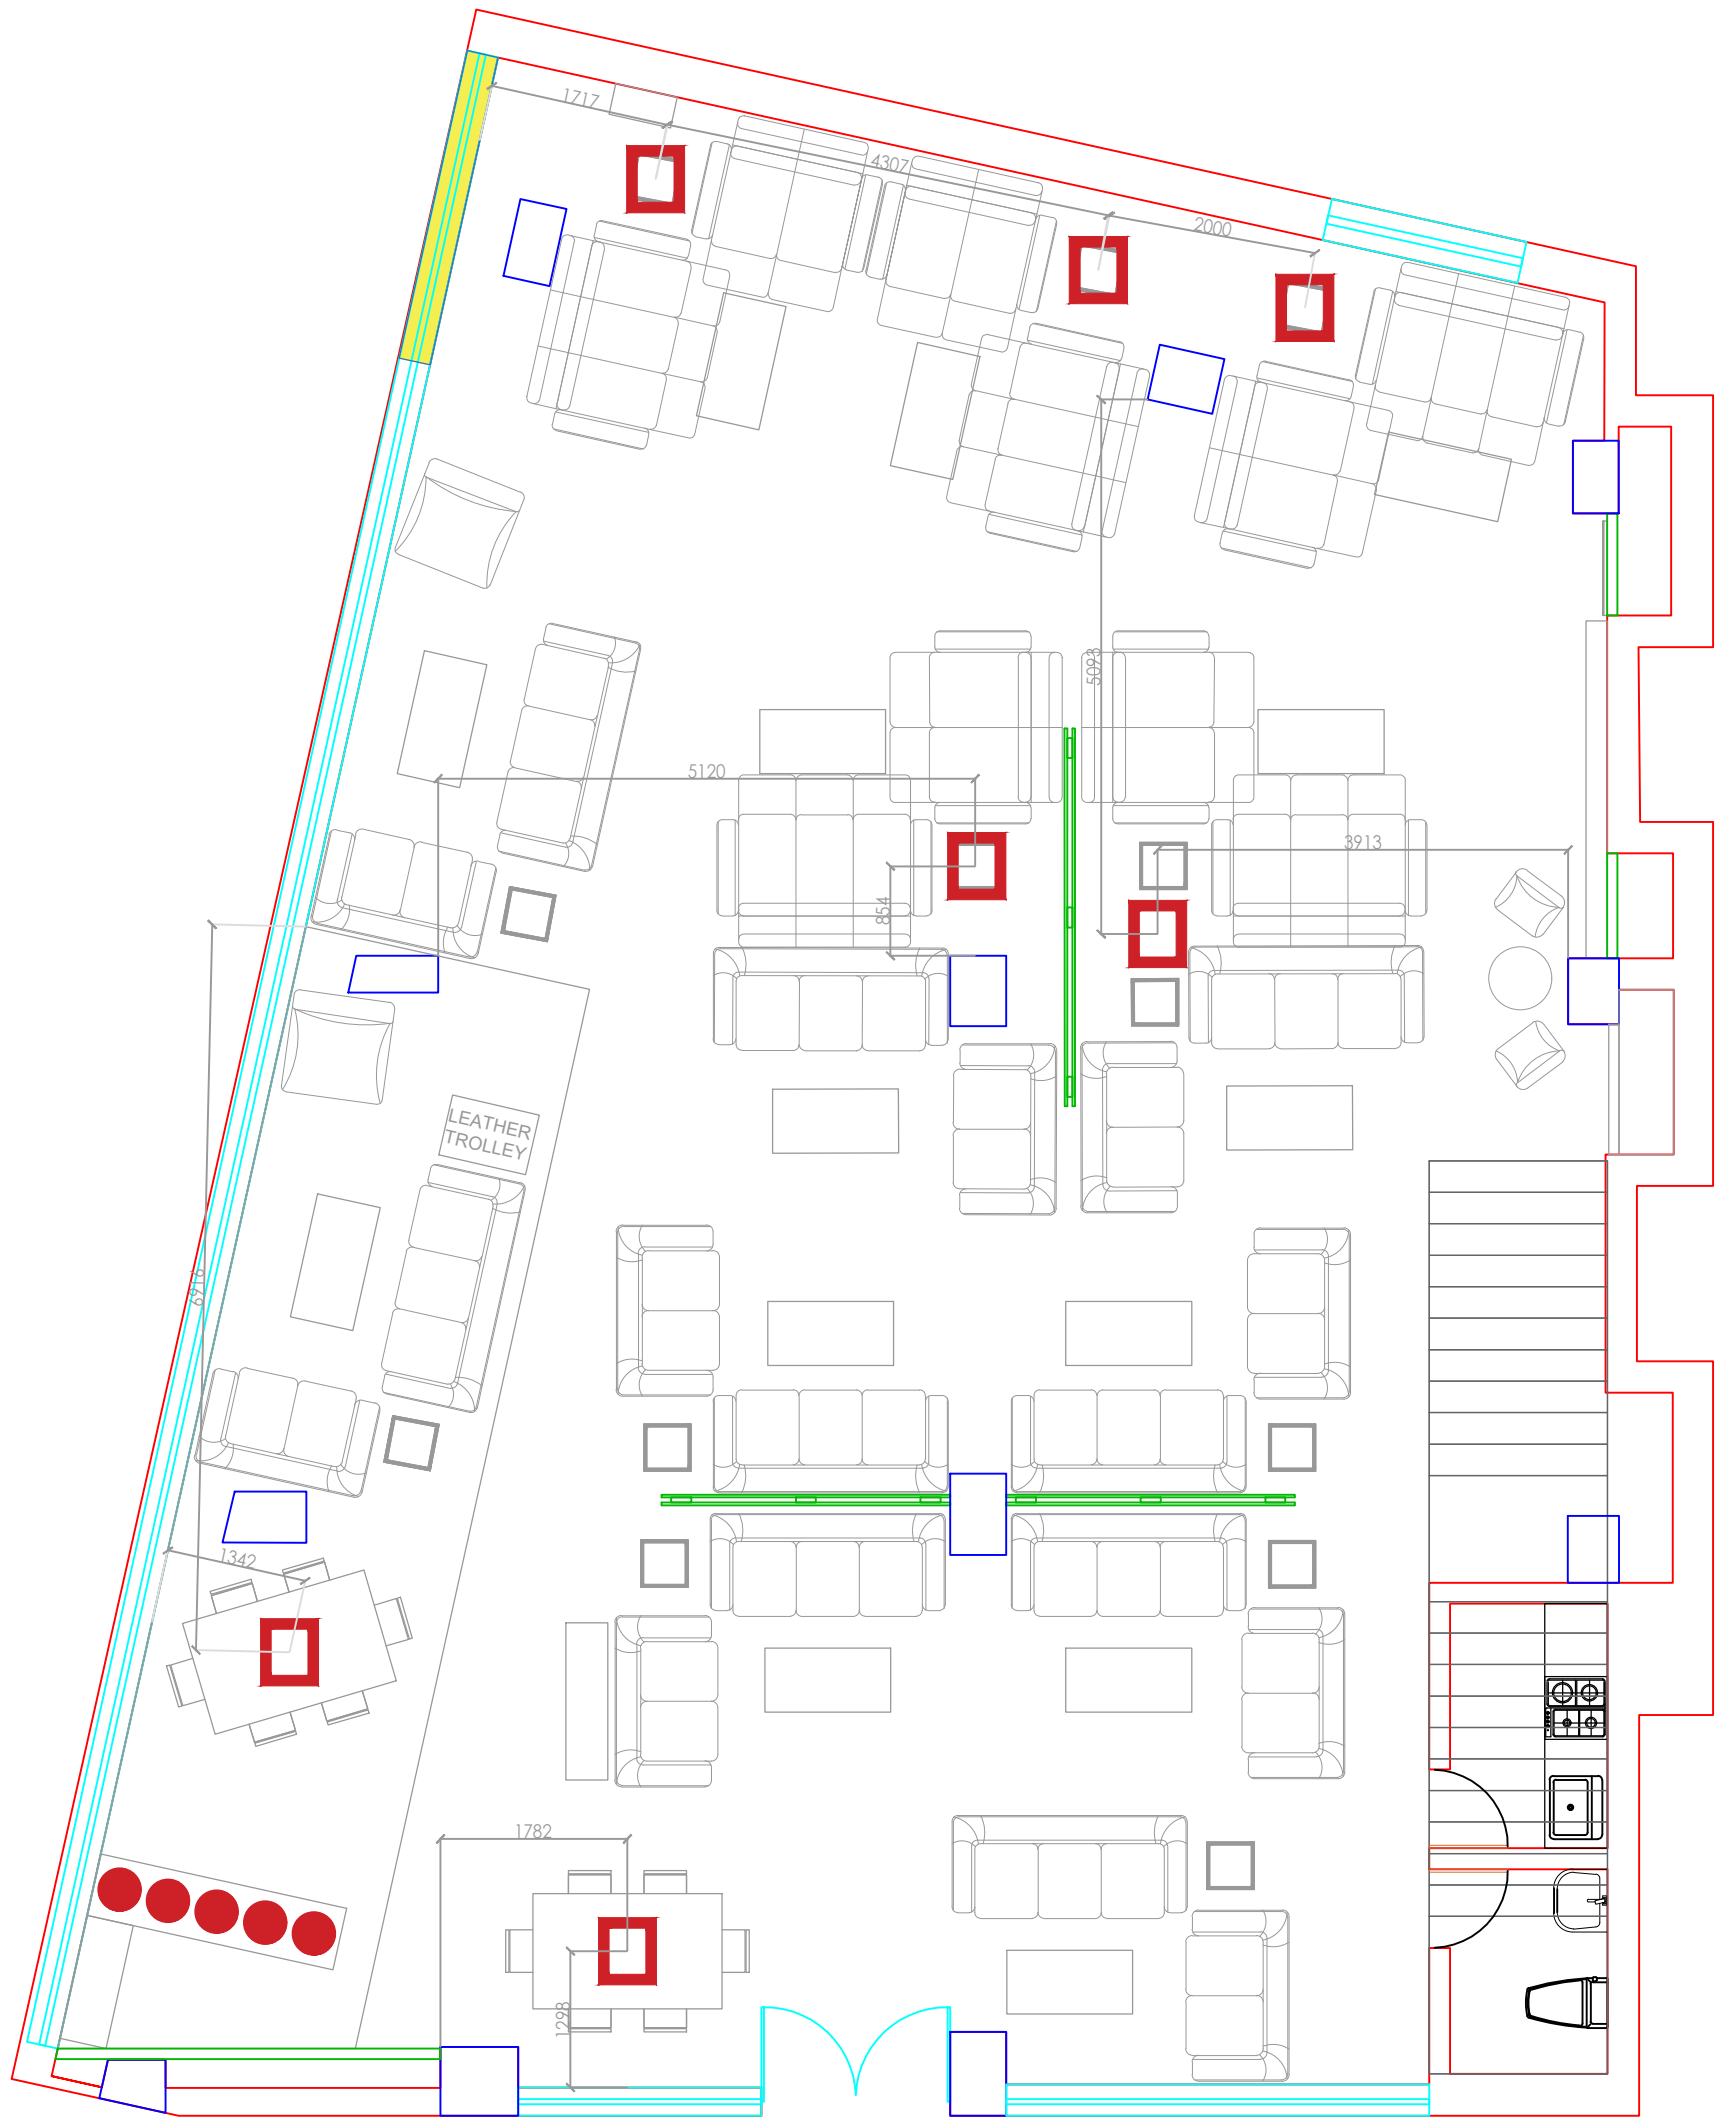




DESCRIPTION :

Site Name :
Guwahati


Layout : Second floor
Sofa section VM
Hanging Lights Layout

Area:
7175.83 sft

NOTE :
Sofa Sets - 16nos.
Dining Set - 03nos.

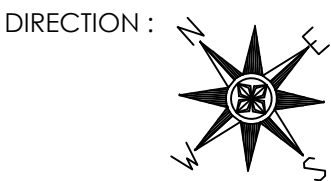

FORMAT : A3
DRAWN BY : Jigar Panchal
DATE: 19-12-2023
DATE OF EDIT:

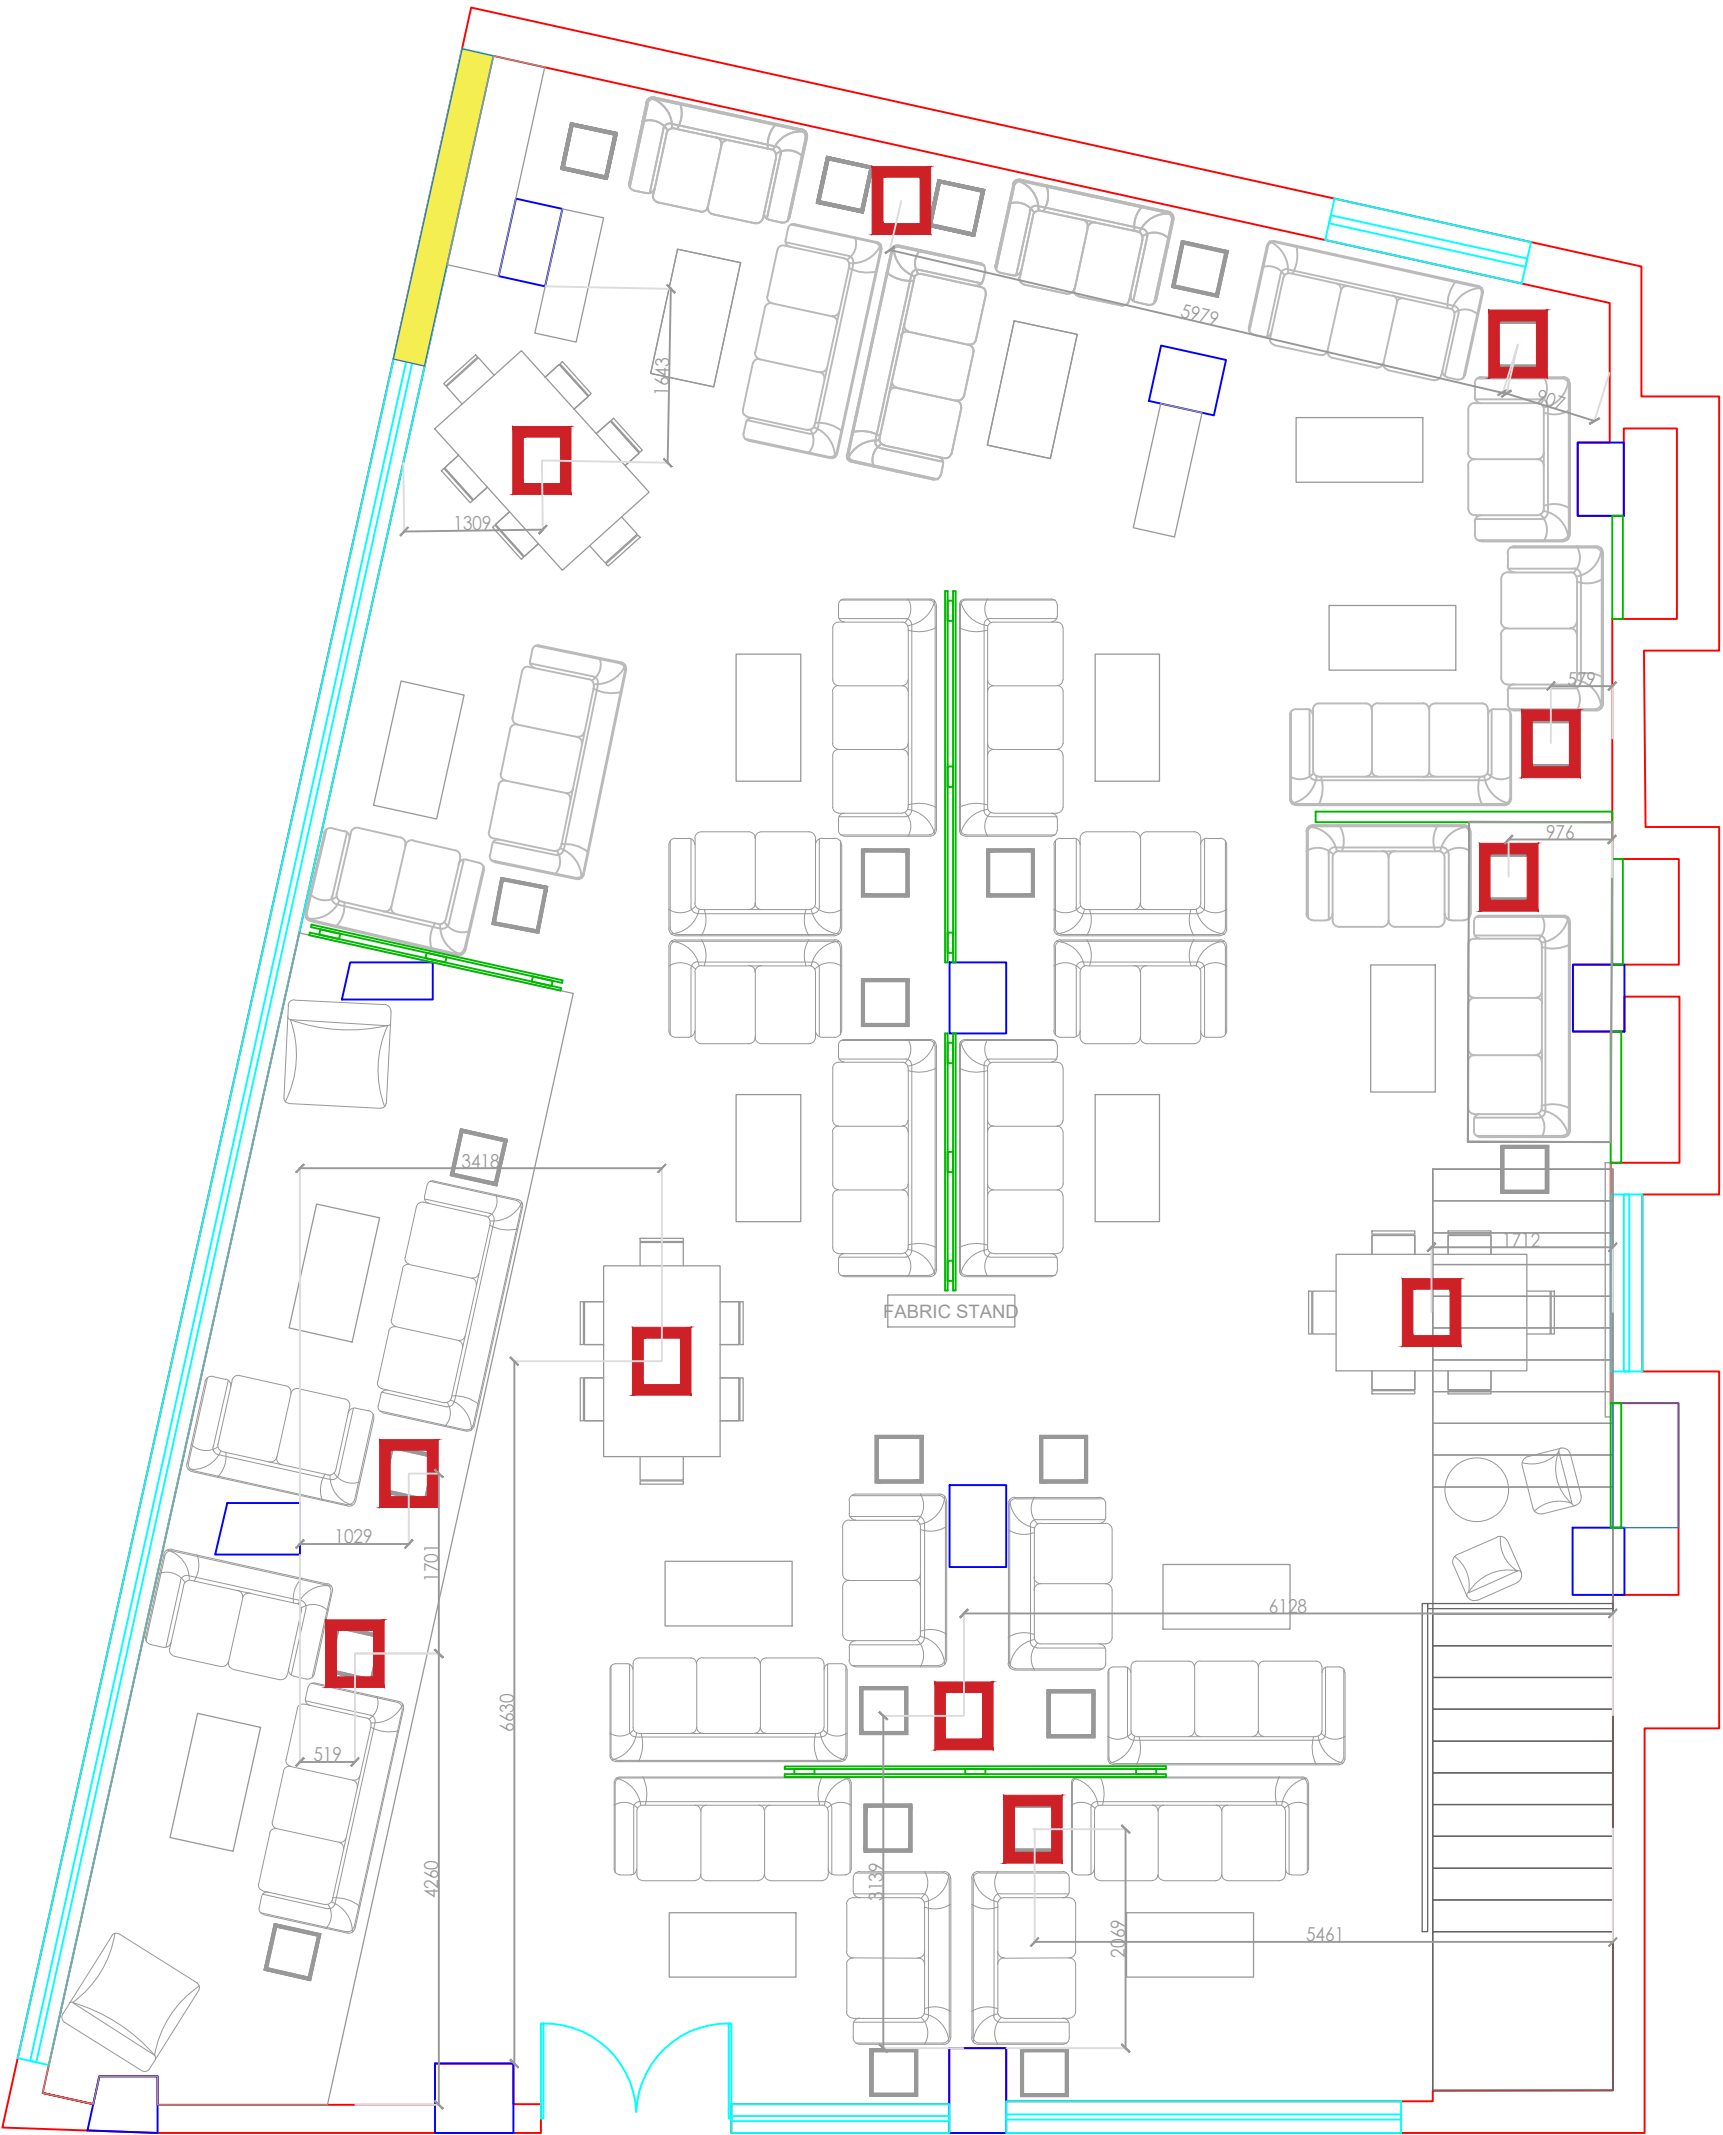




DESCRIPTION :

Site Name :
Guwahati


Layout : Second Floor
Bed Section Combined
RCP Layout

Area:
7175.83 sft

NOTE :
Beds - 11 nos.
Office table - 02nos

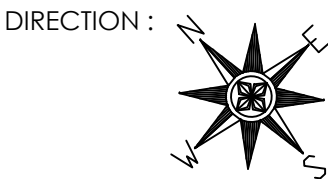

FORMAT : A3
DRAWN BY : Jigar Panchal
DATE: 19-12-2023
DATE OF EDIT:

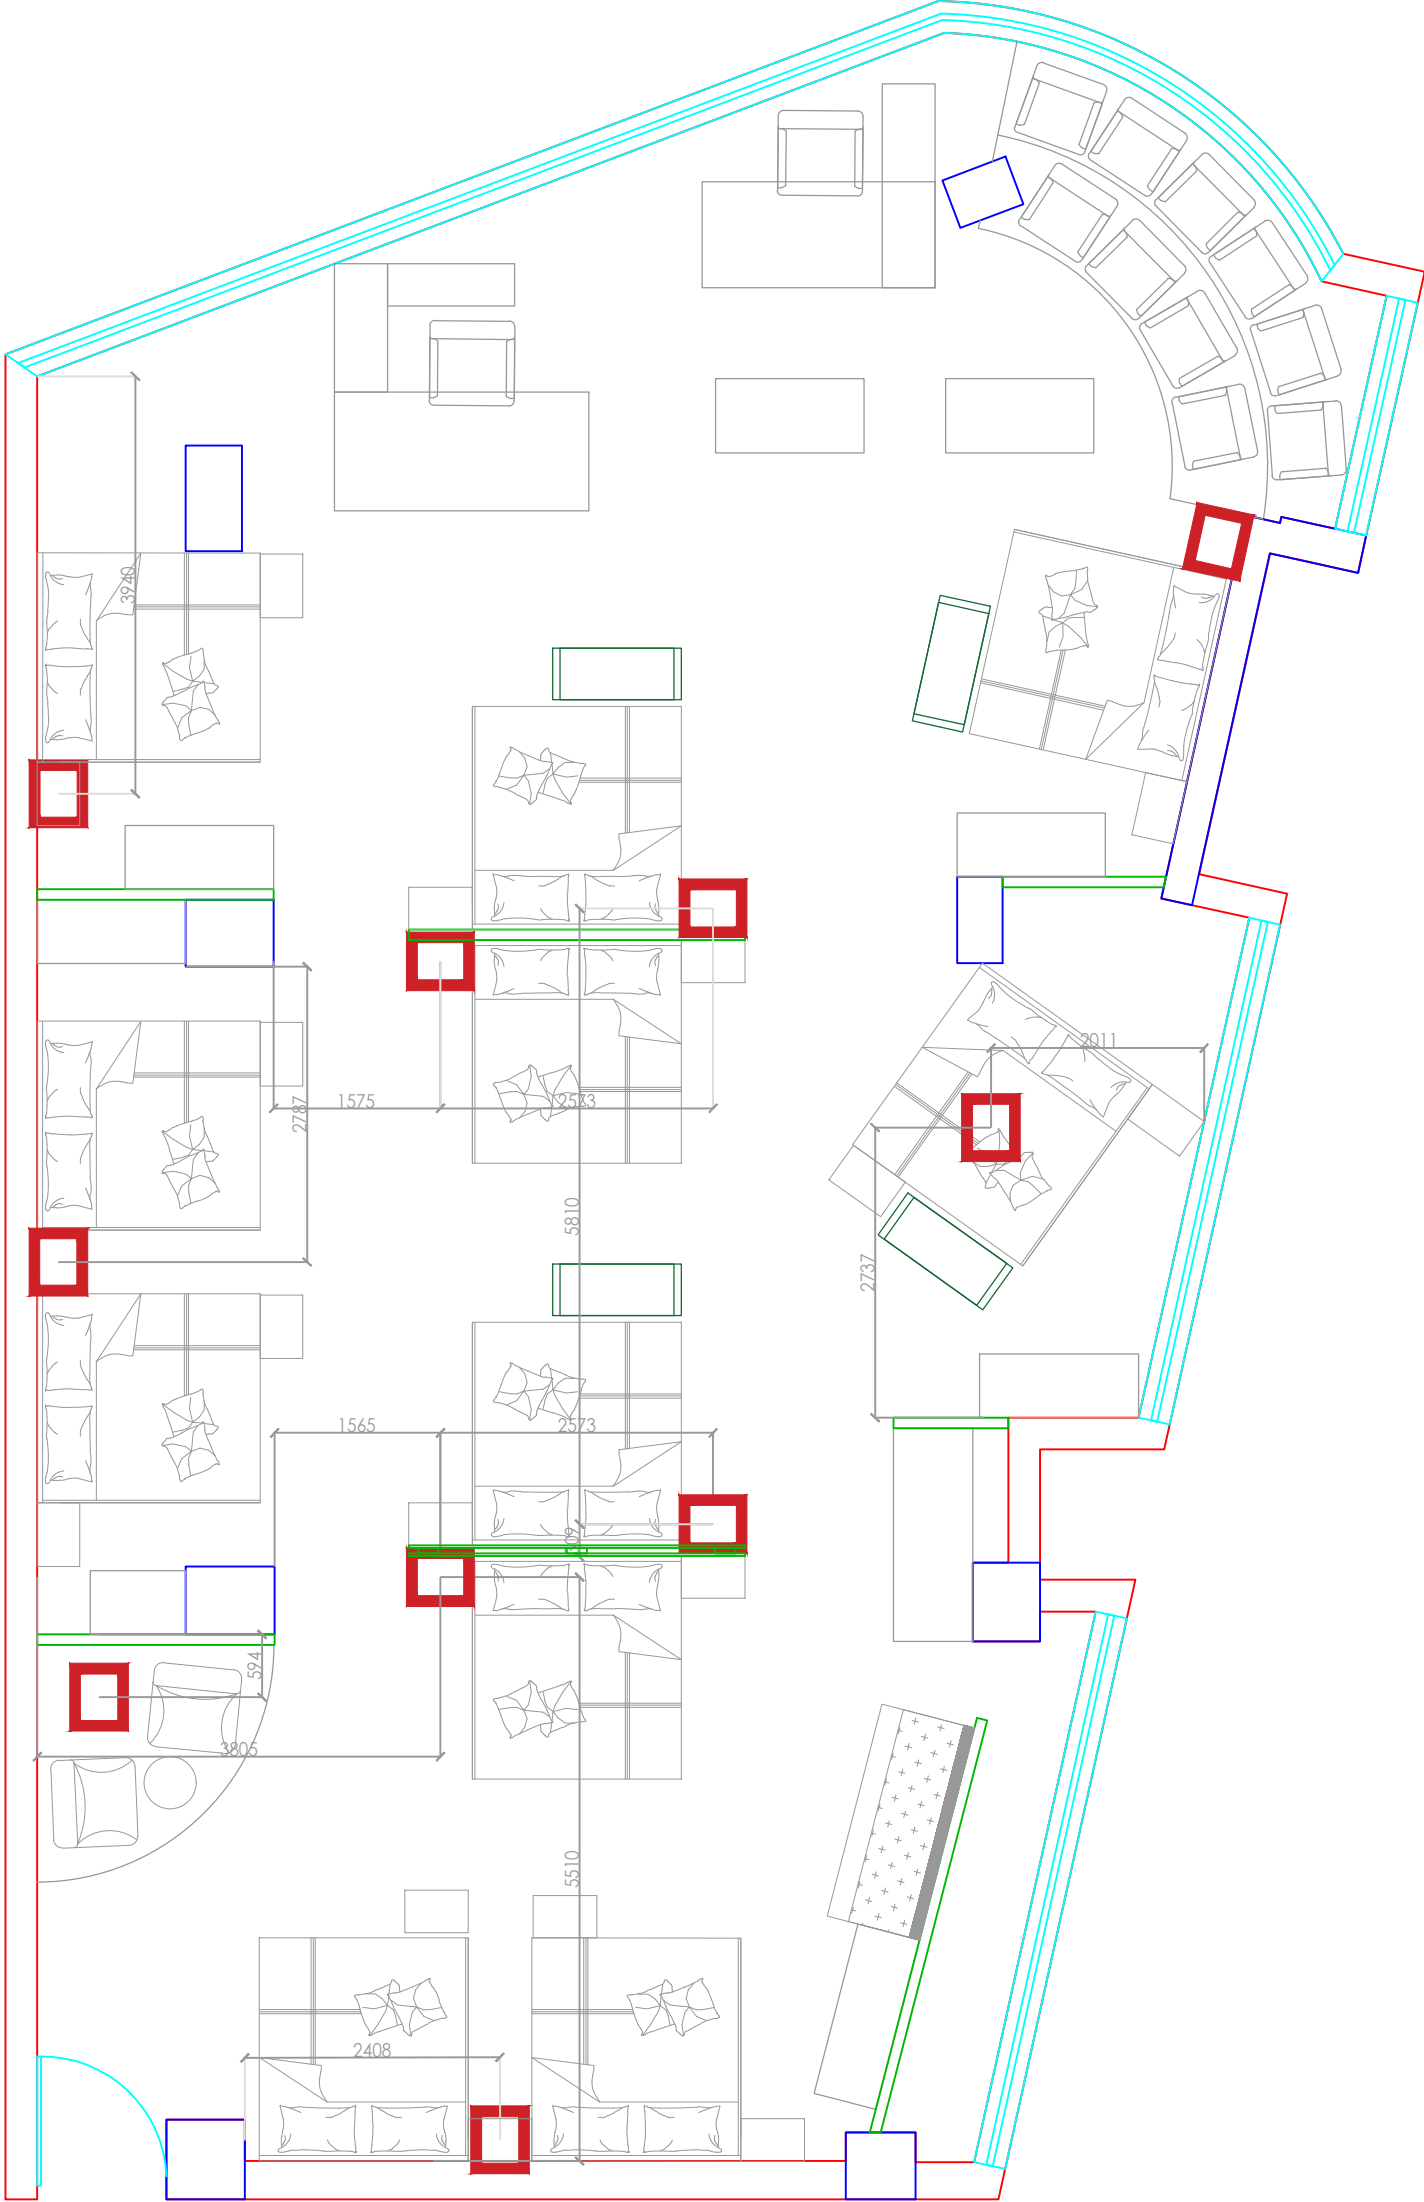




DESCRIPTION :

Site Name :
Guwahati

Layout : First floor
Sofa section CCTV &
Speaker Layout

Area:
7175.83 sft

NOTE :
Sofa Sets - 14nos.
Dining Set - 02nos.

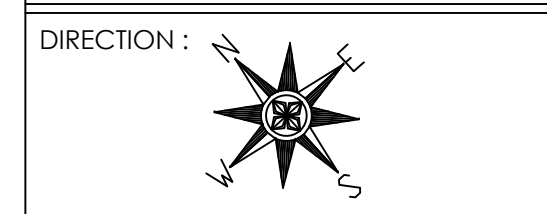


FORMAT : A3

DRAWN BY : Jigar Panchal

DATE: 19-12-2023

DATE OF EDIT:

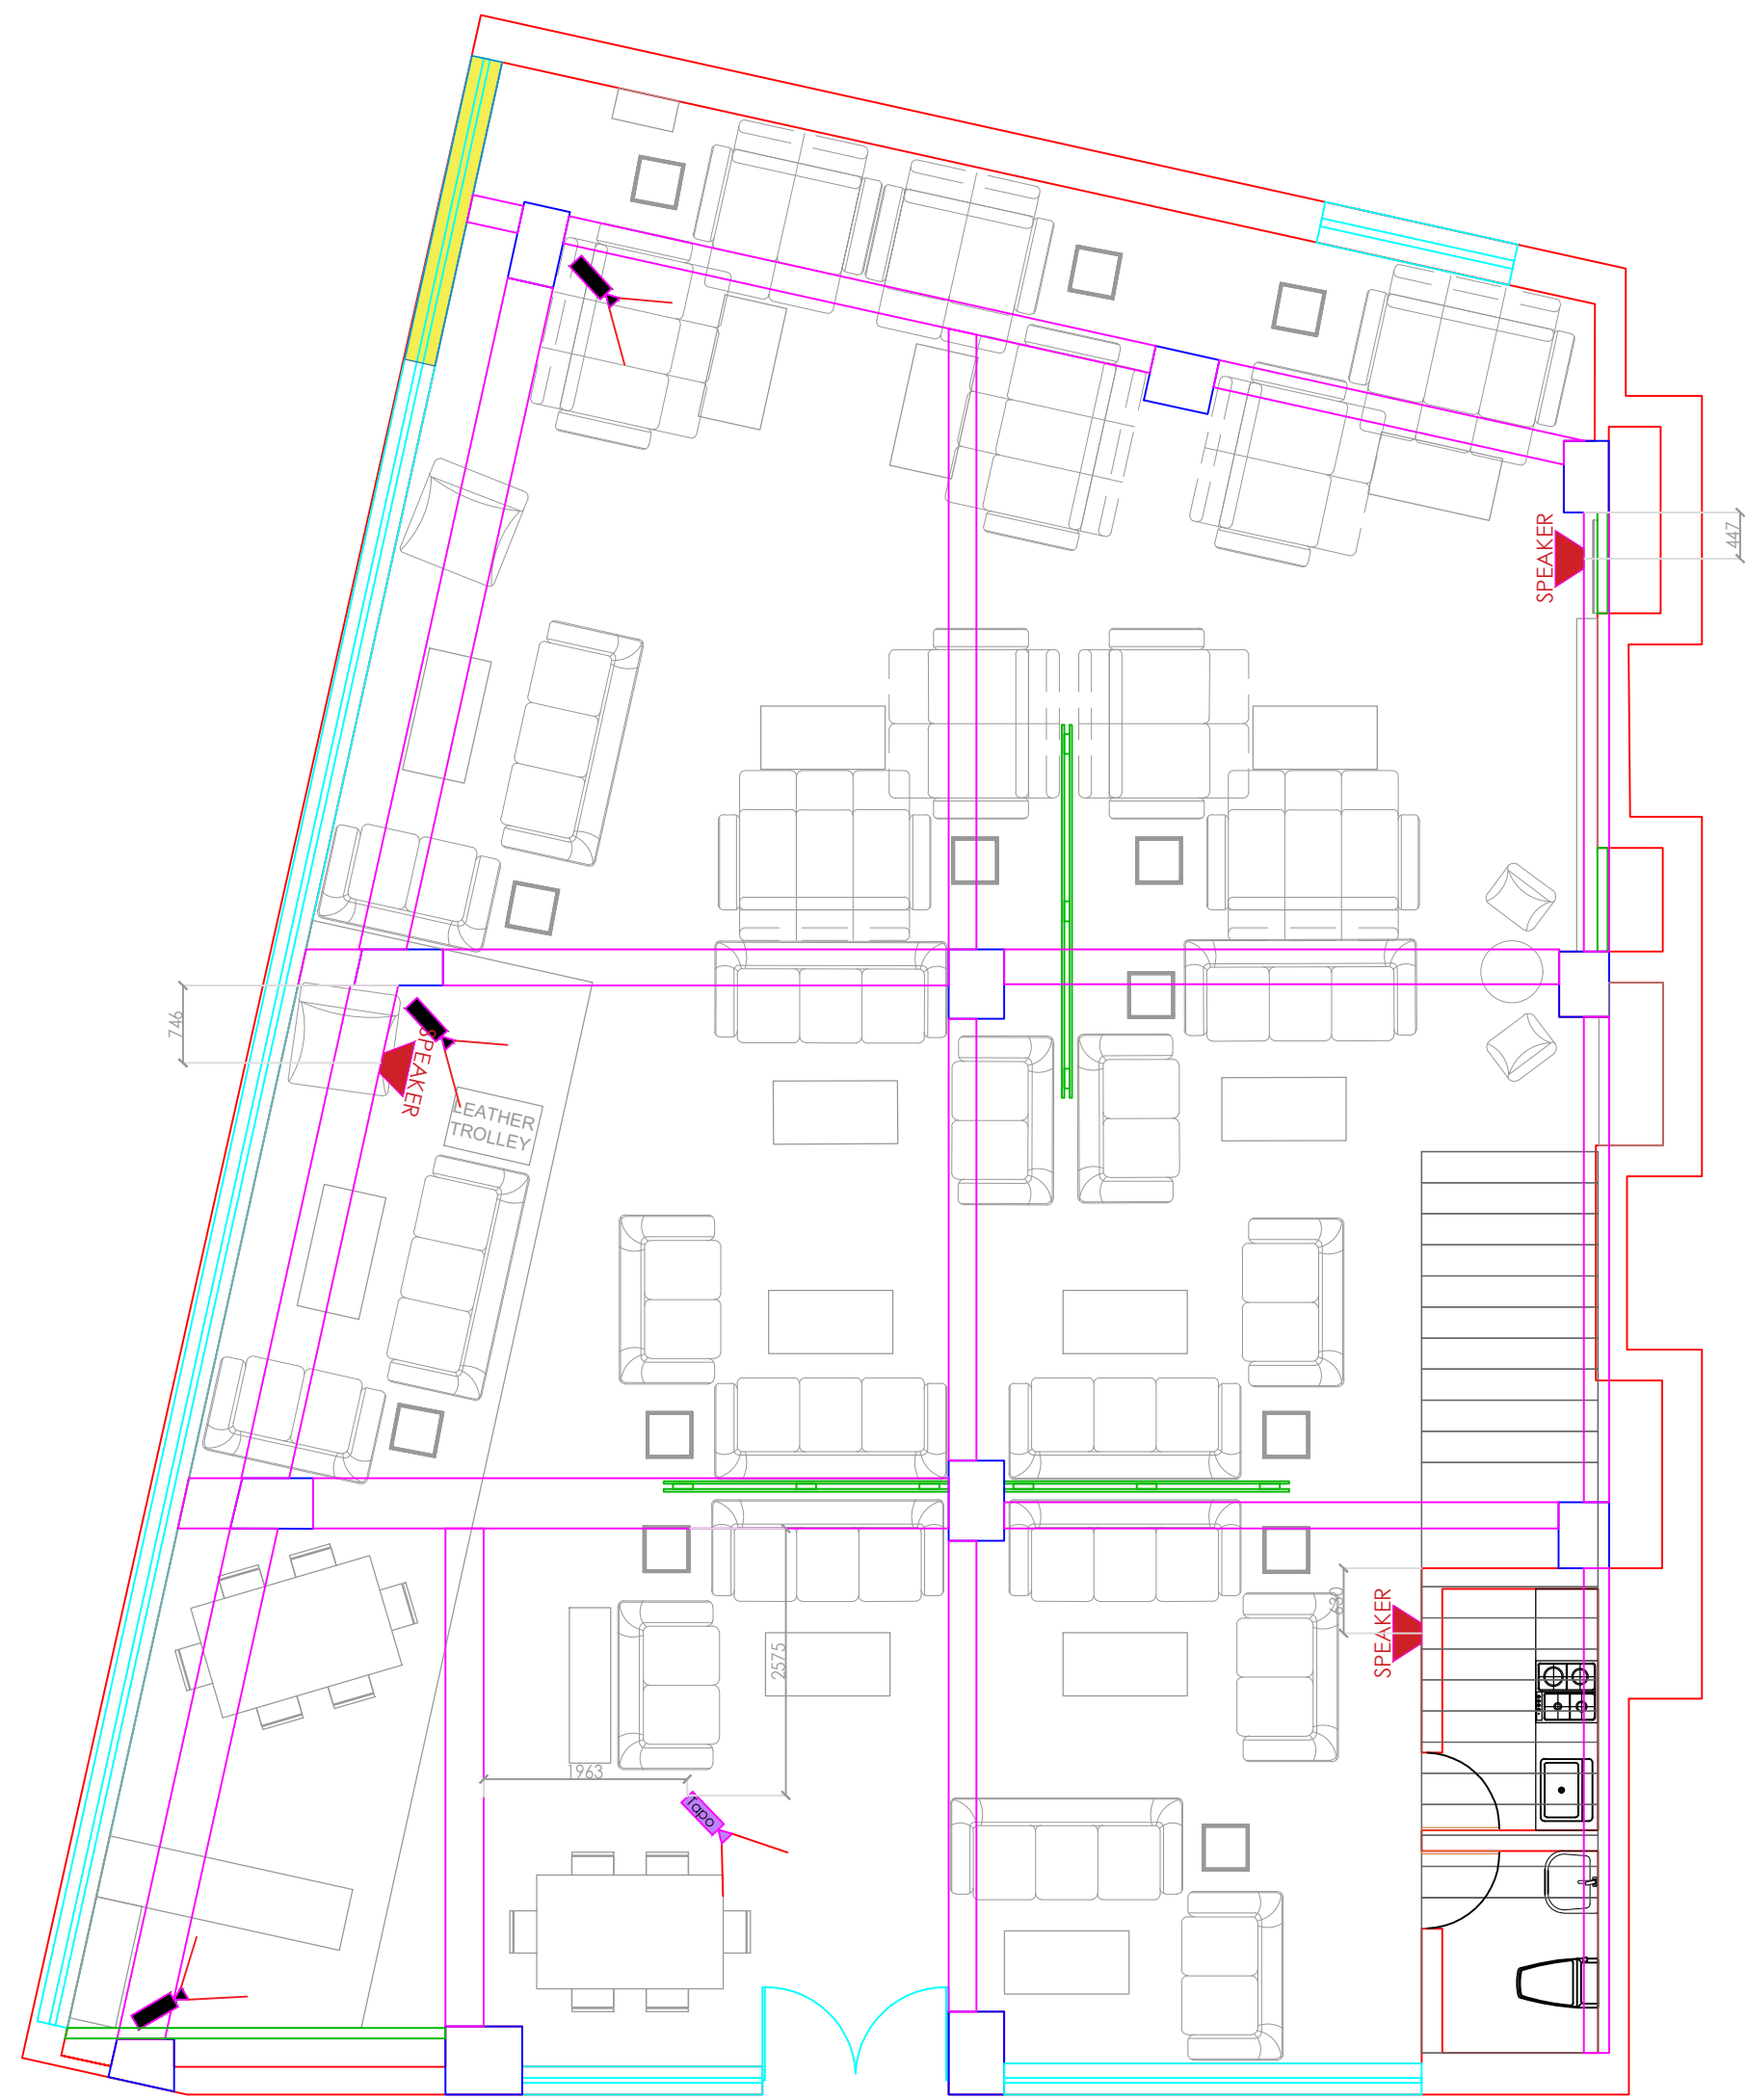



DESCRIPTION :

Site Name :
Guwahati

Layout : Second floor
Sofa section CCTV &
Speaker Layout

Area:
7175.83 sft

NOTE :
Sofa Sets - 16nos.
Dining Set - 03nos.

DIRECTION :




FORMAT : A3

DRAWN BY : Jigar Panchal

DATE: 19-12-2023

DATE OF EDIT:

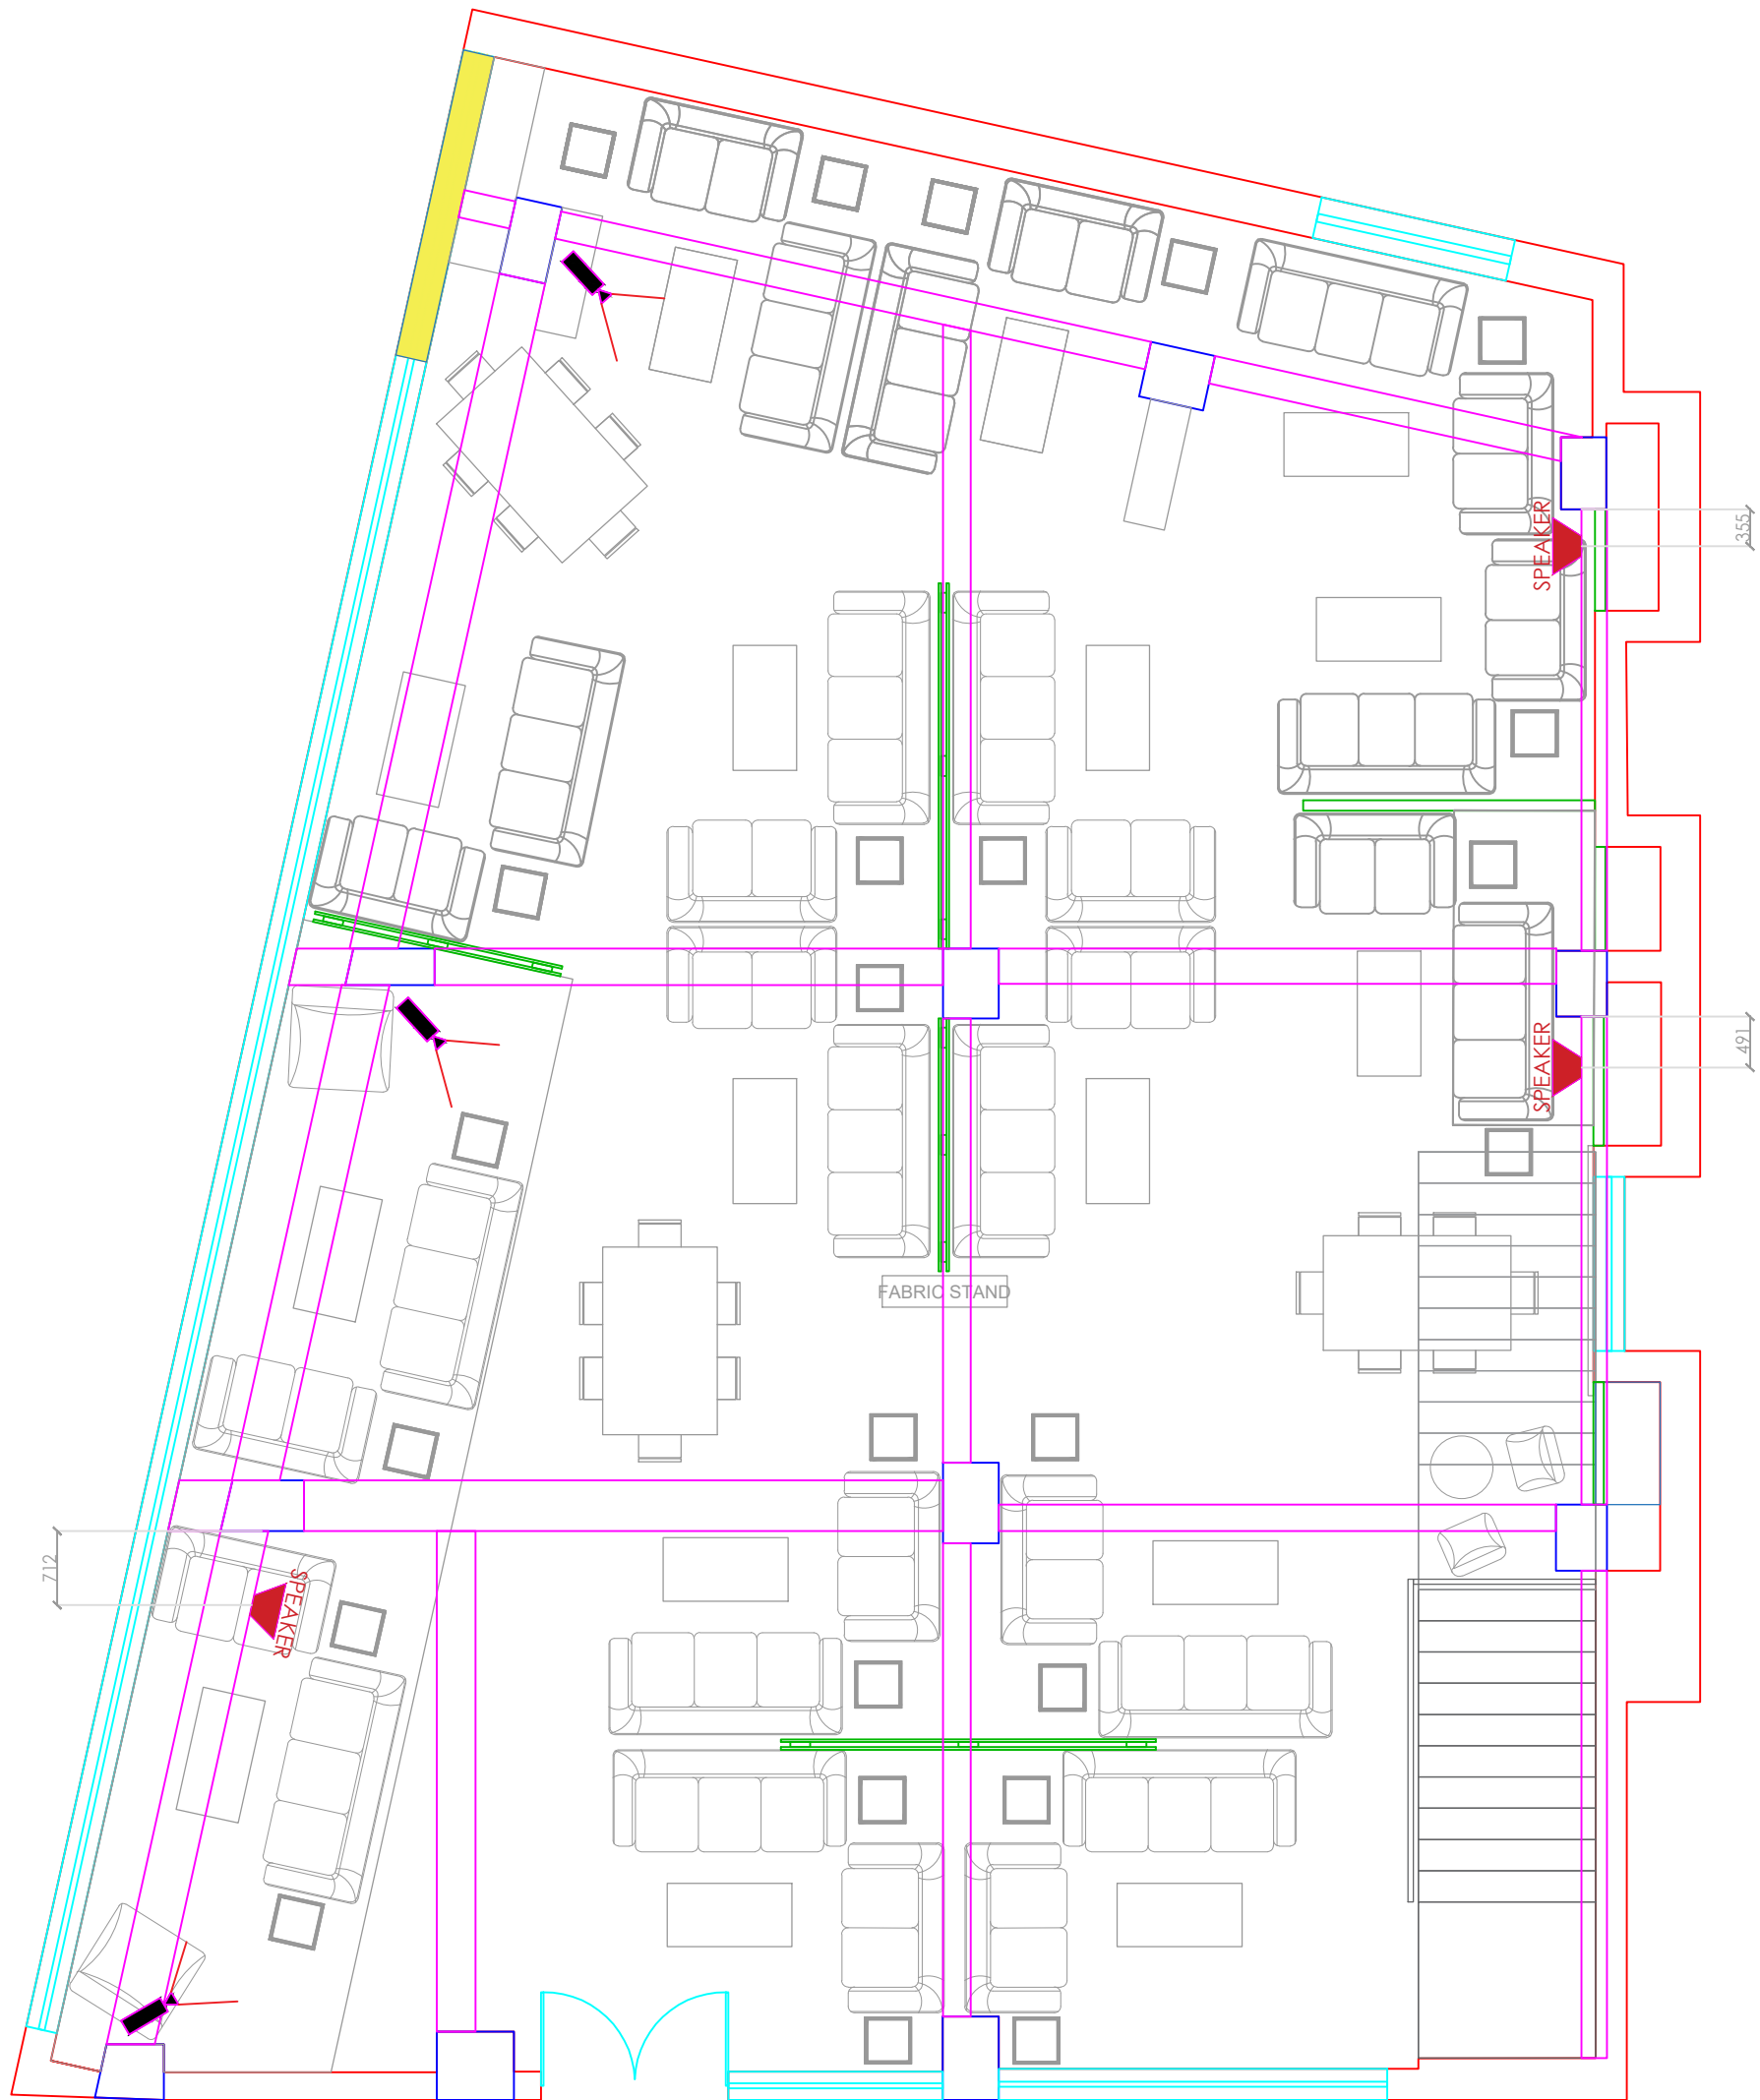



DESCRIPTION :

Site Name :
Guwahati

Layout : Second Floor
Bed Section CCTV &
Speaker Layout Layout

Area:
7175.83 sft

NOTE :
Beds - 11nos.
Office table - 02nos

DIRECTION :




FORMAT : A3

DRAWN BY : Jigar Panchal

DATE: 19-12-2023

DATE OF EDIT:

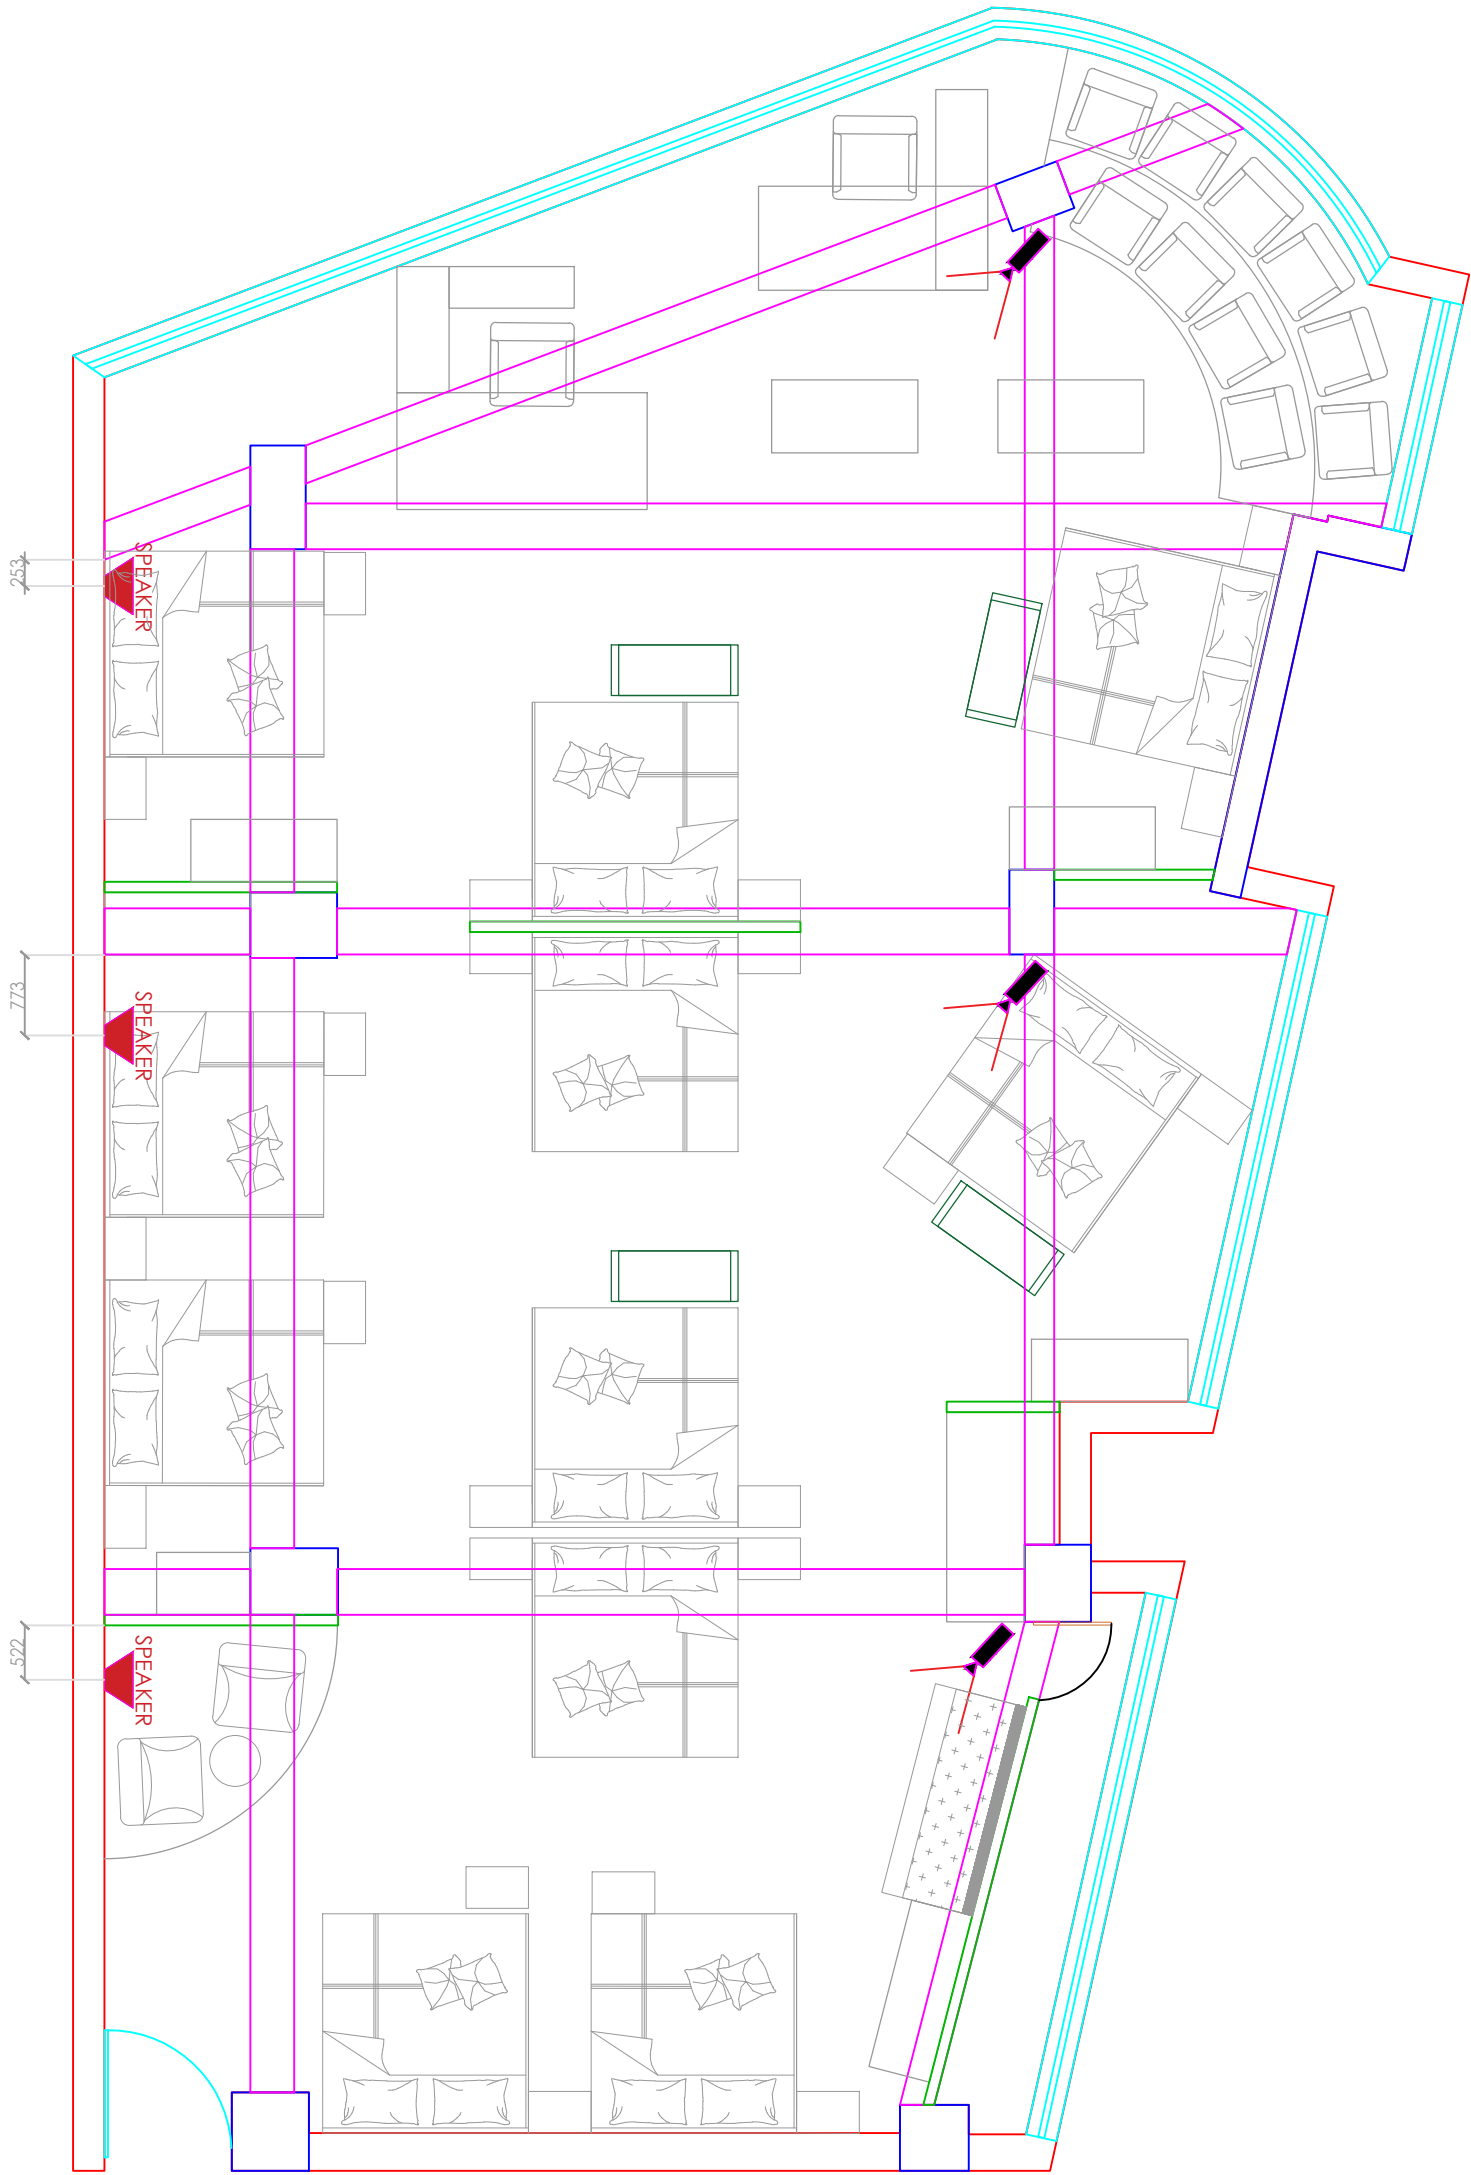



DESCRIPTION :

Site Name :
Guwahati

Layout : First floor
AC Layout

Area:
7175.83 sft

NOTE :
Sofa Sets - 14nos.
Dining Set - 02nos.

DIRECTION :




FORMAT : A3

DRAWN BY : Jigar Panchal

DATE: 19-12-2023

DATE OF EDIT:

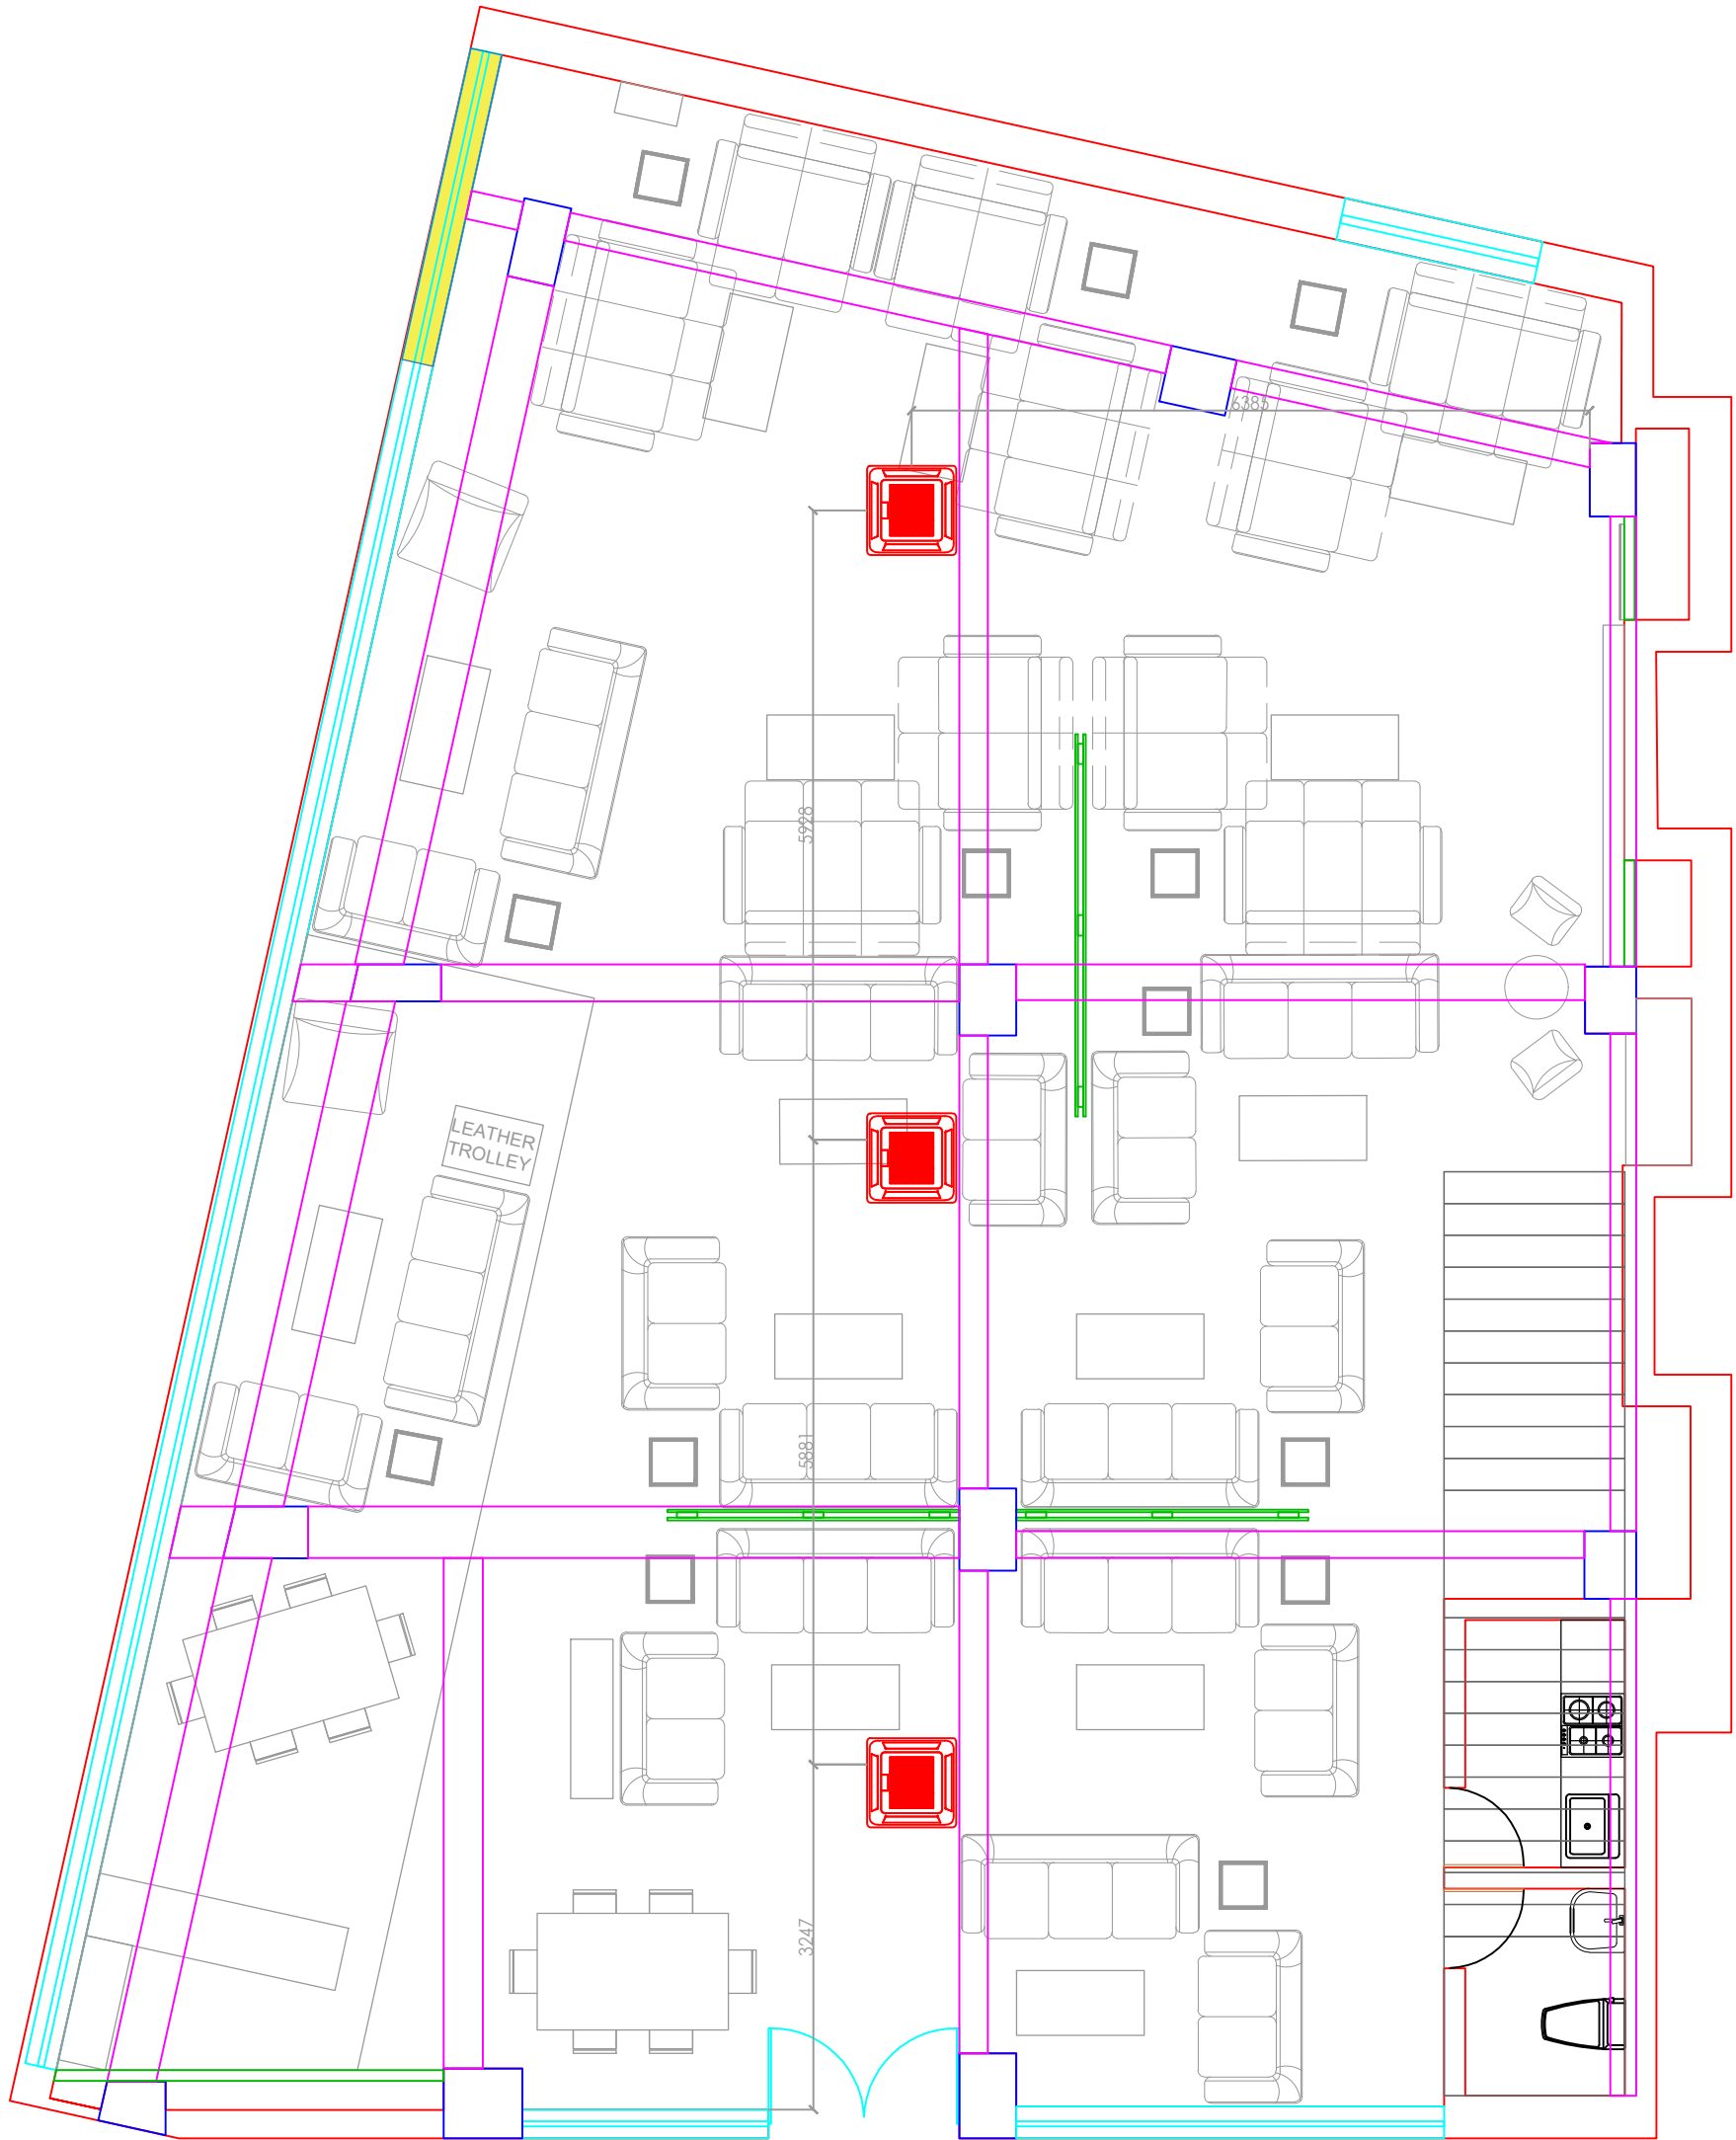



DESCRIPTION :

Site Name :
Guwahati

Layout : Second floor
AC Layout

Area:
7175.83 sft

NOTE :
Sofa Sets - 16nos.
Dining Set - 03nos.

DIRECTION :





FORMAT : A3

DRAWN BY : Jigar Panchal

DATE: 19-12-2023

DATE OF EDIT:

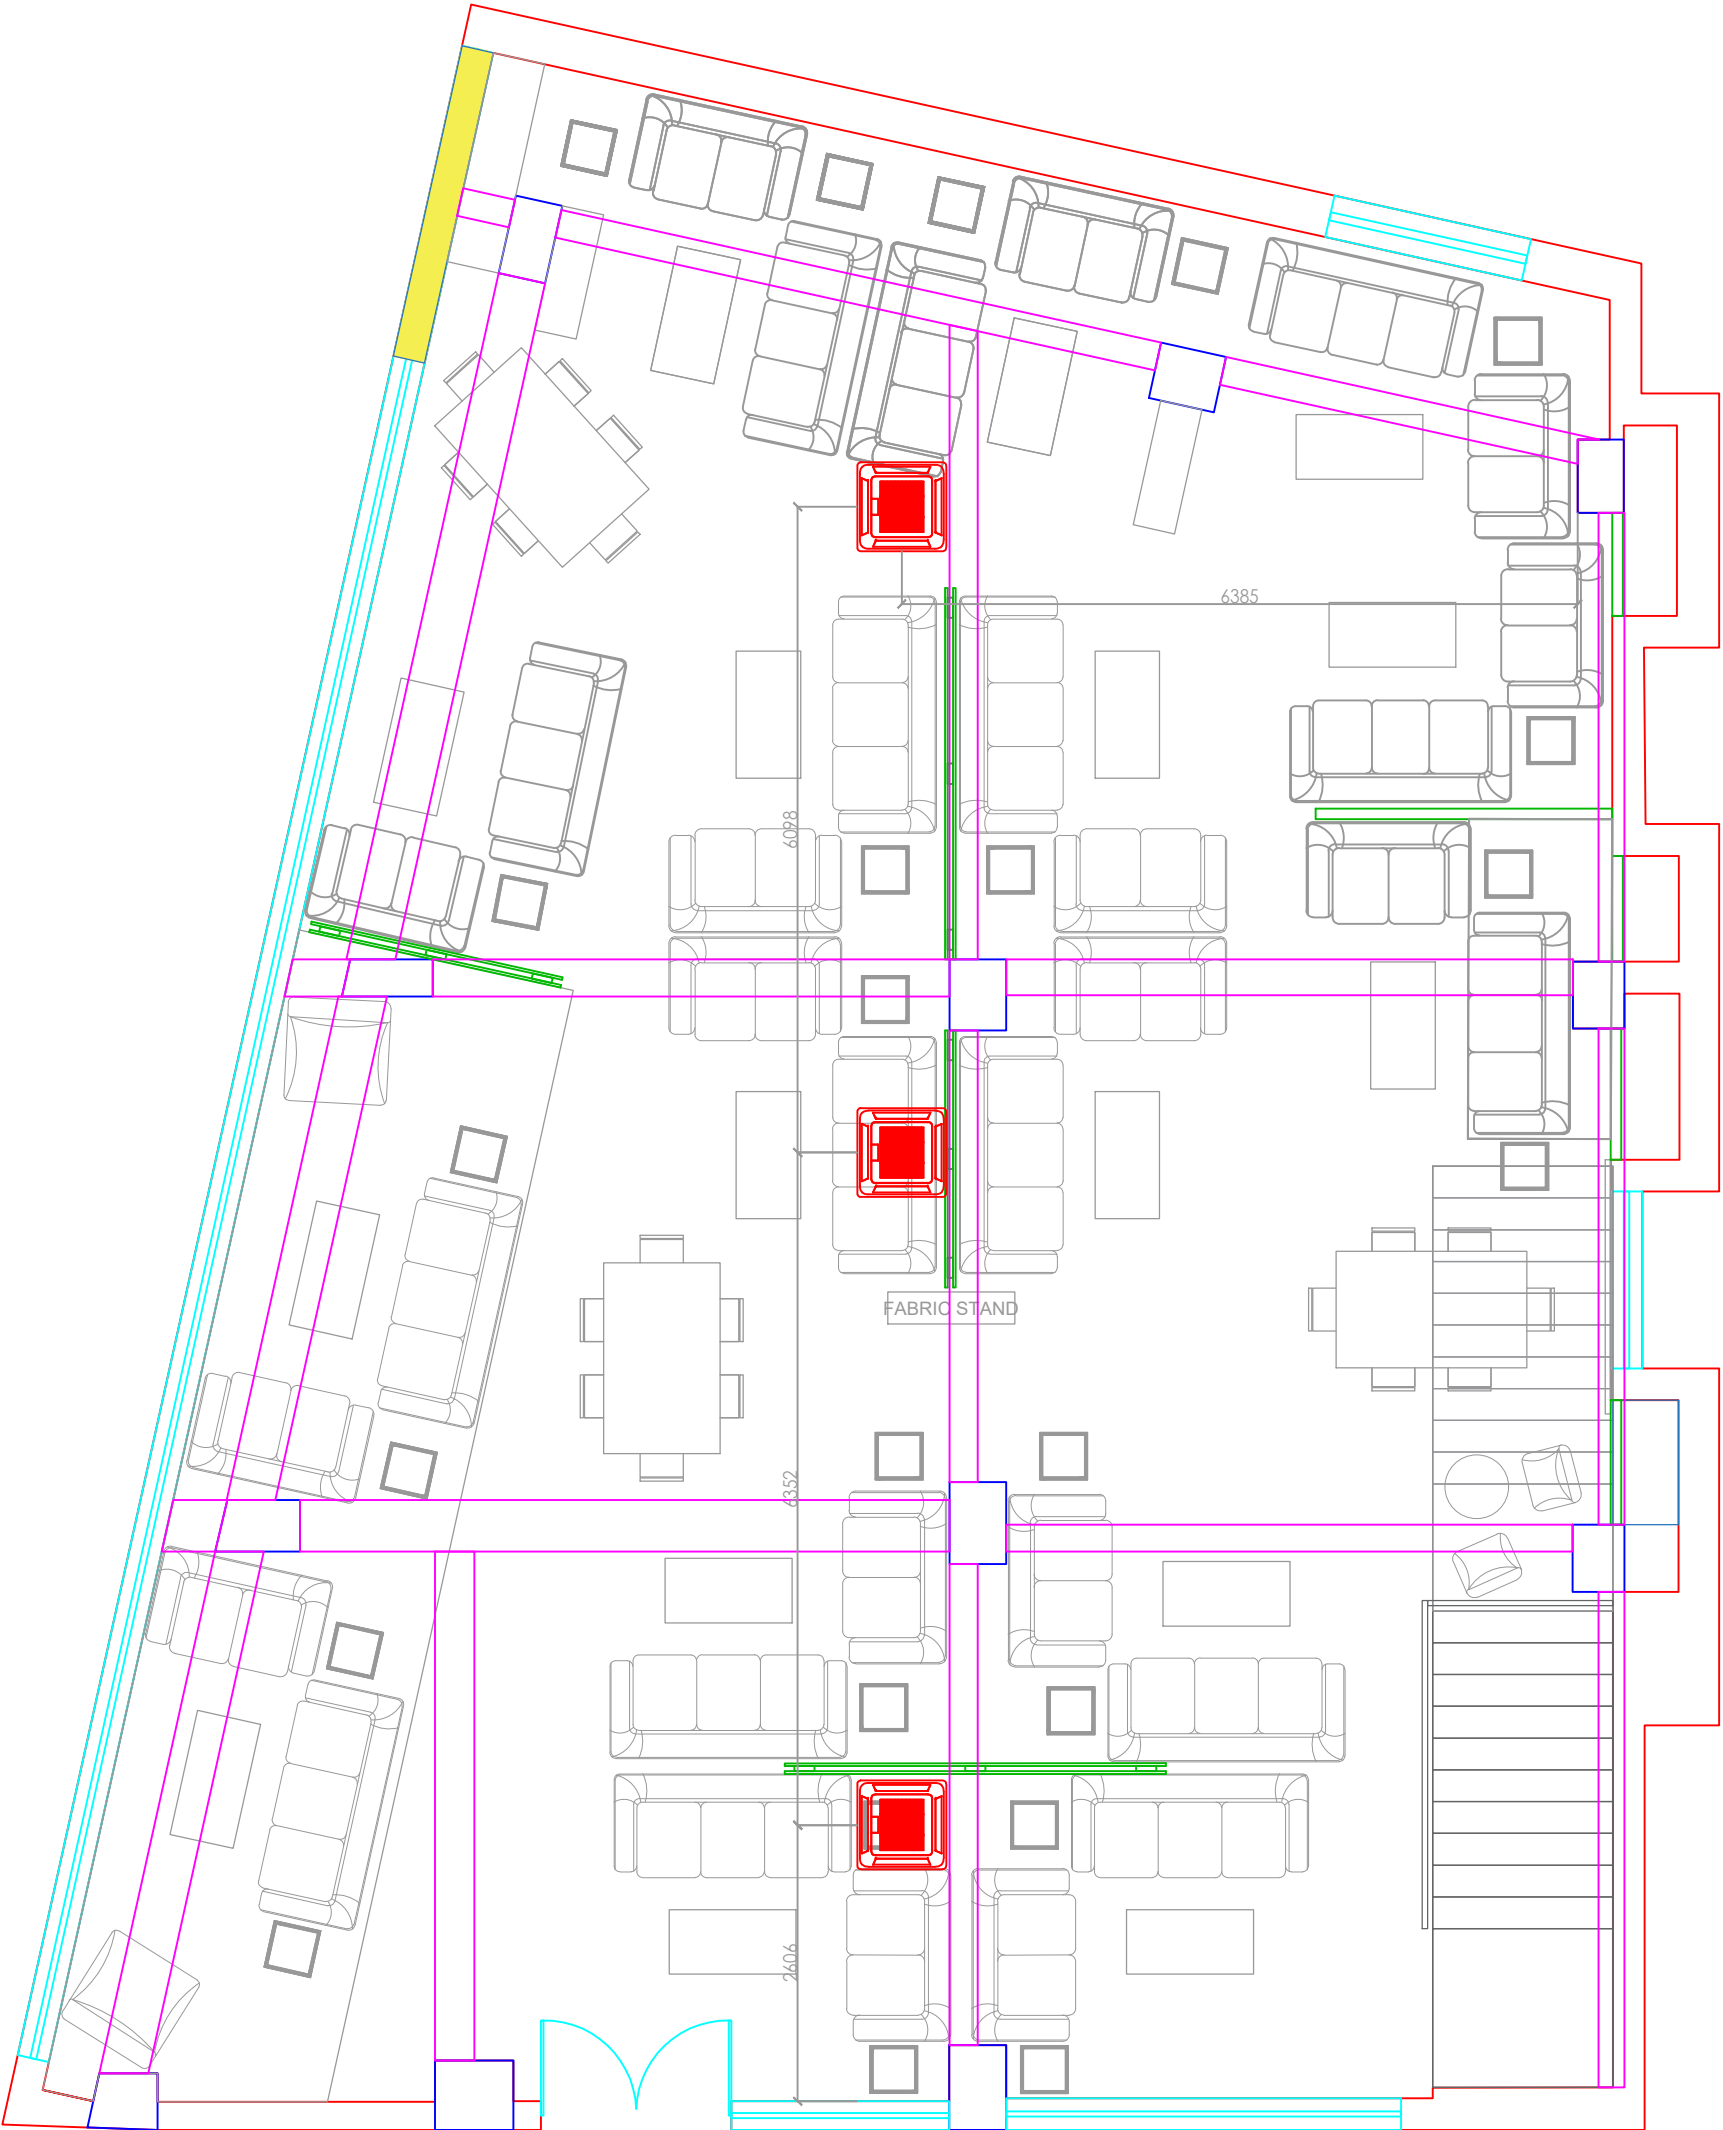


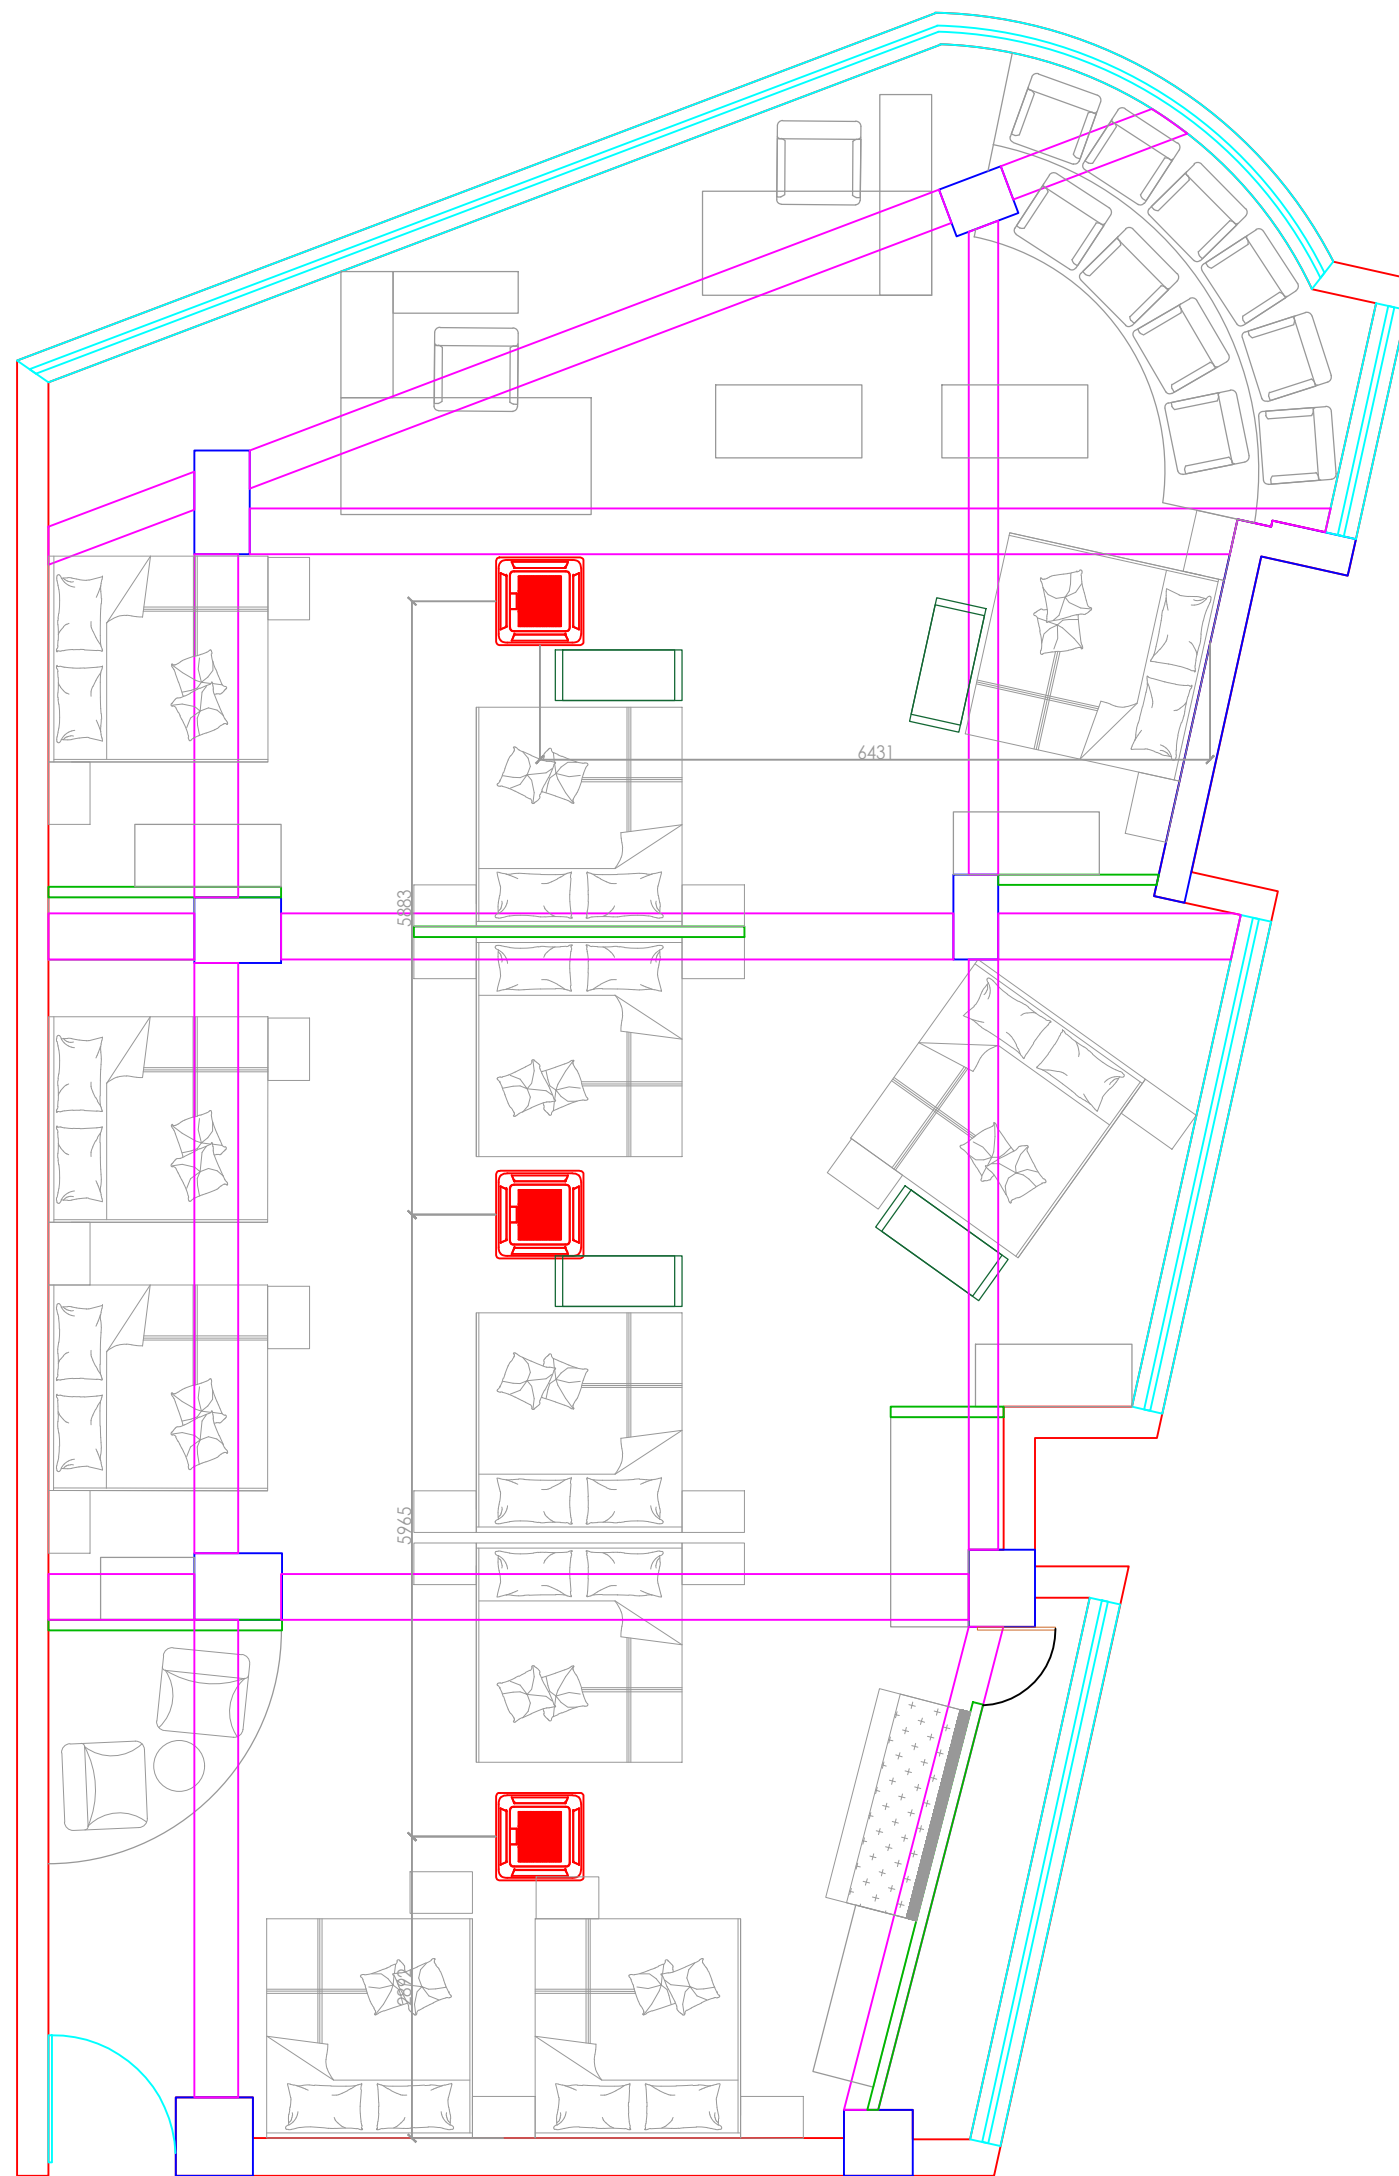

	
DESCRIPTION :	
Site Name : Guwahati	
Layout : Second Floor Bed Section AC Layout	
Area: 7175.83 sft	
NOTE : Beds - 11nos. Office table - 02nos	
DIRECTION : 	
FORMAT : A3	
DRAWN BY : Jigar Panchal	
DATE: 19-12-2023	
DATE OF EDIT:	



DESCRIPTION :

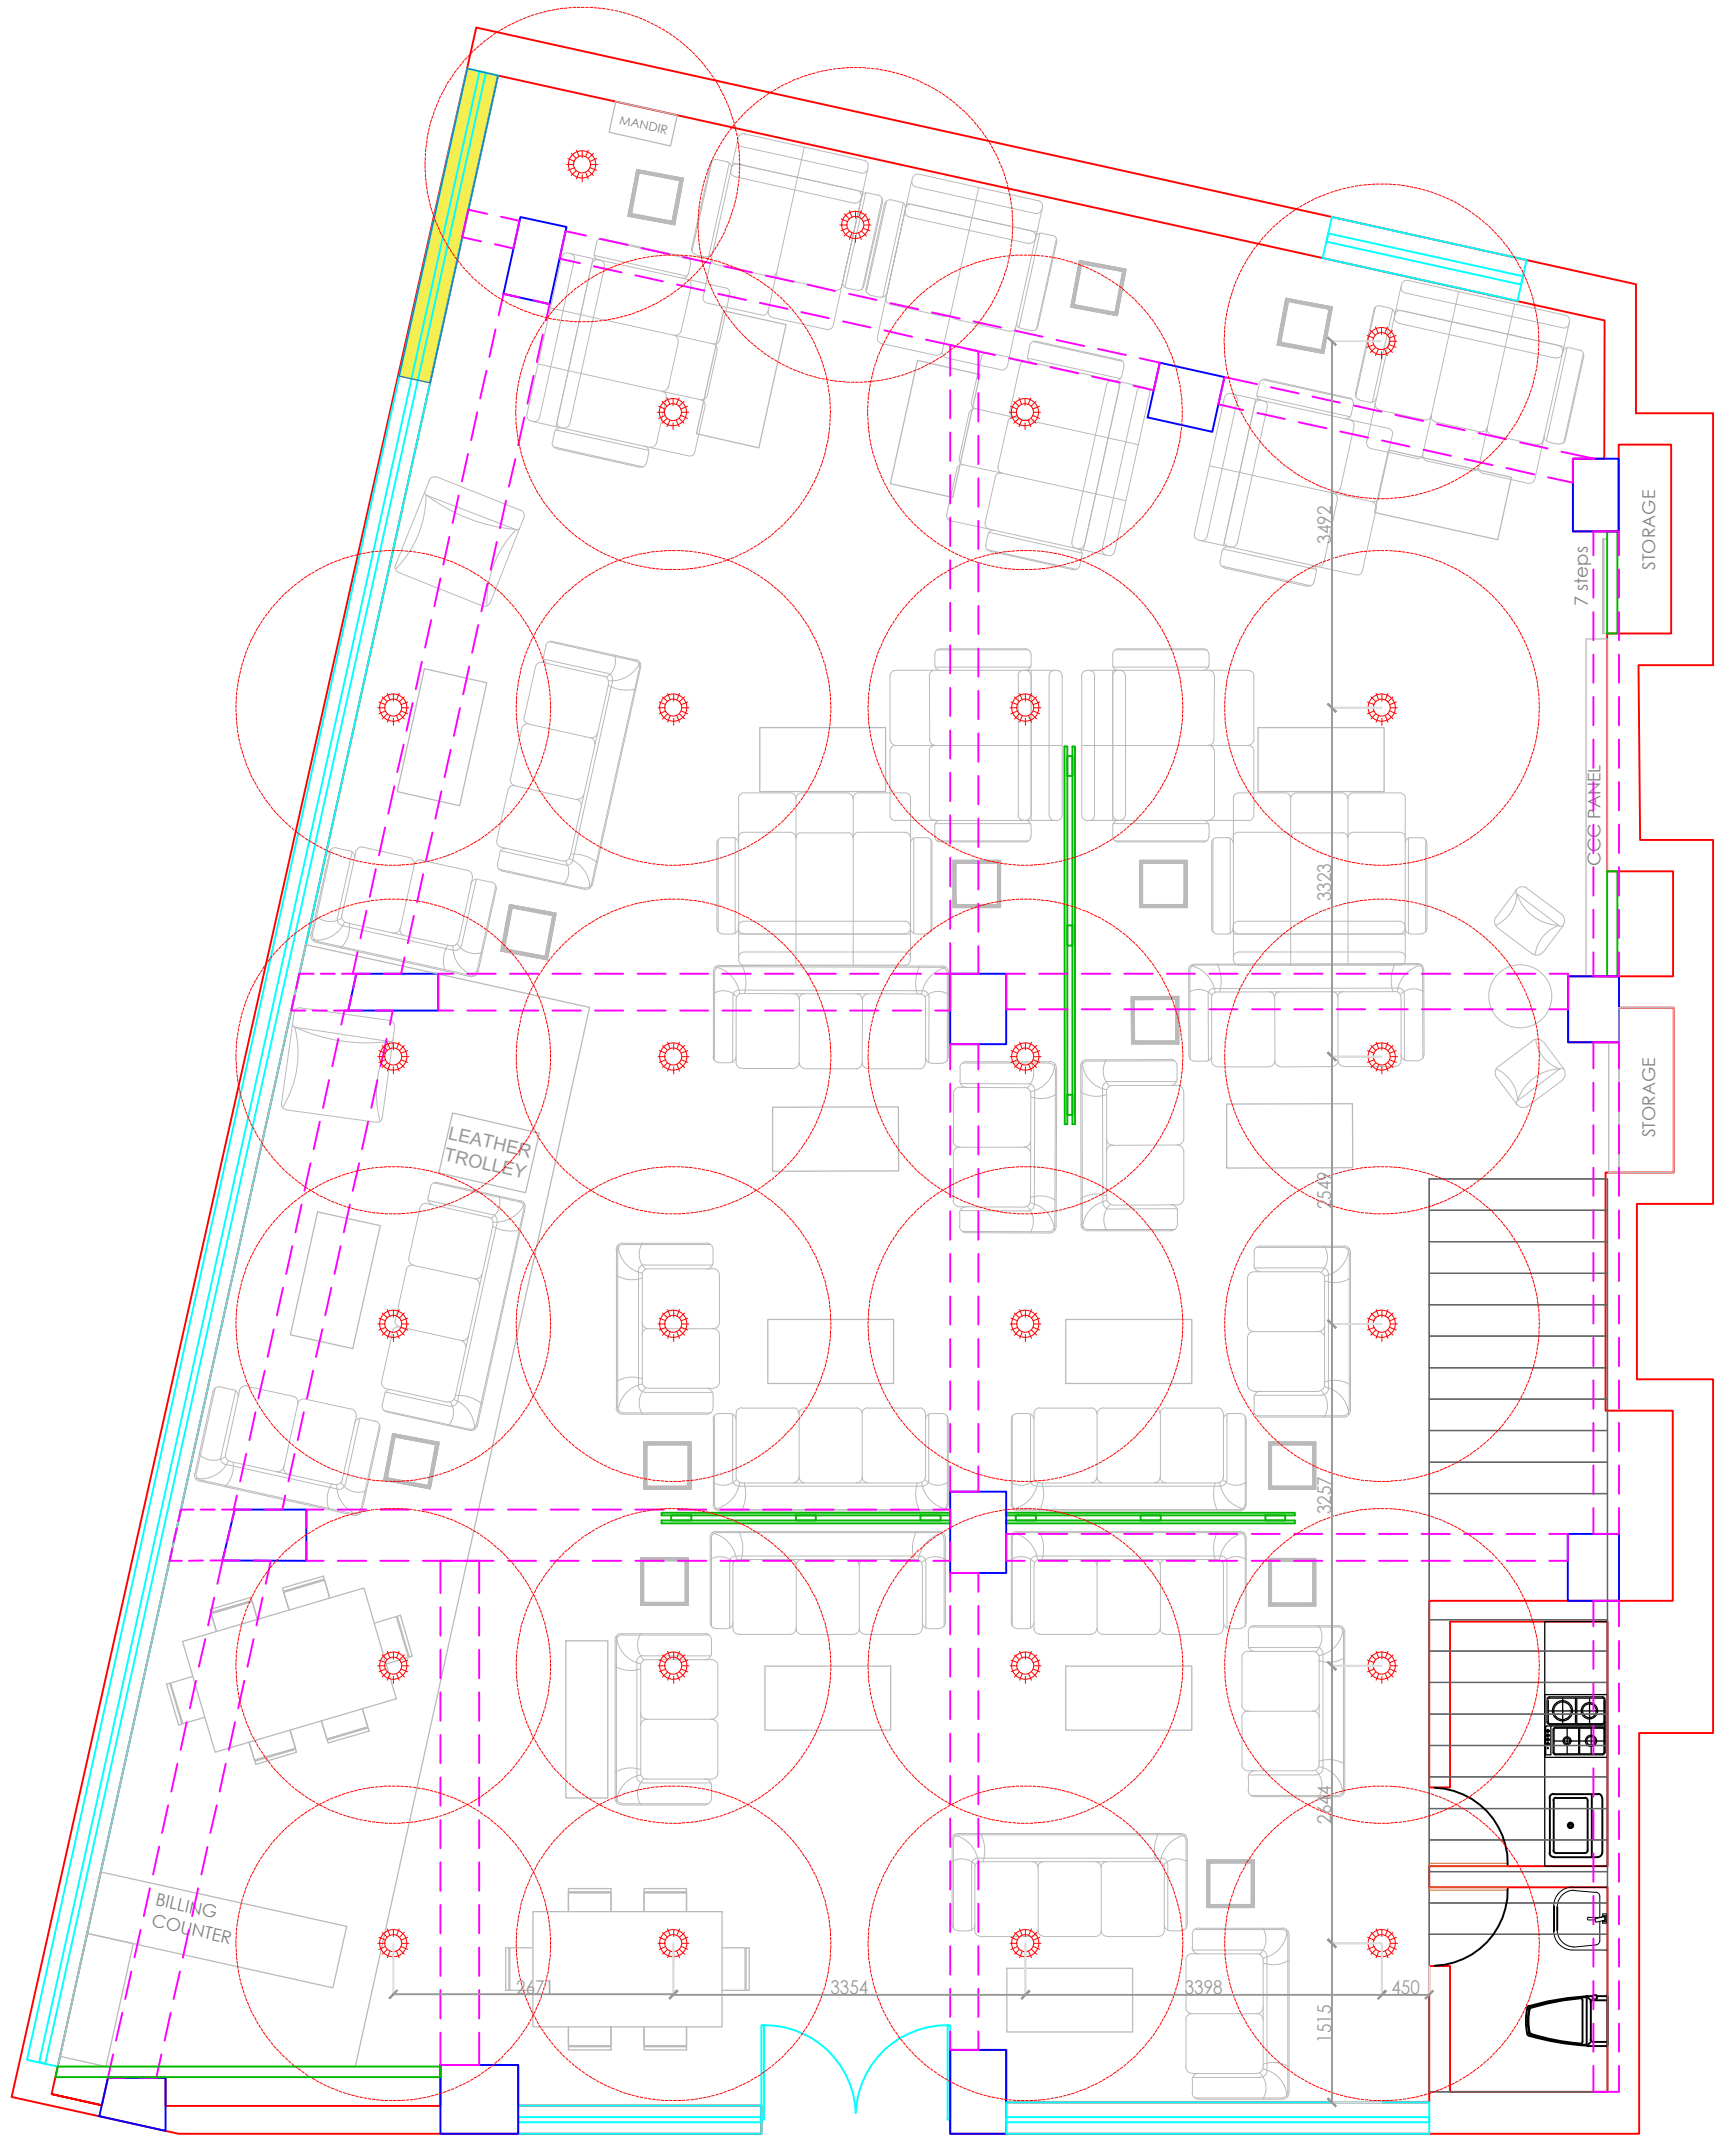


Site Name :
Guwahati

Layout : First floor
Sofa section Sprinkler
Layout

Area:
7175.83 sft

NOTE :
Sofa Sets - 14nos.
Dining Set - 02nos.

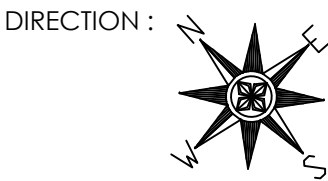

FORMAT : A3
DRAWN BY : Jigar Panchal
DATE: 19-12-2023
DATE OF EDIT:



DESCRIPTION :

Site Name :
Guwahati

Layout : Second floor
Sofa section Sprinkler
Layout

Area:
7175.83 sft

NOTE :
Sofa Sets - 16nos.
Dining Set - 03nos.

DIRECTION :




FORMAT : A3

DRAWN BY : Jigar Panchal

DATE: 19-12-2023

DATE OF EDIT:

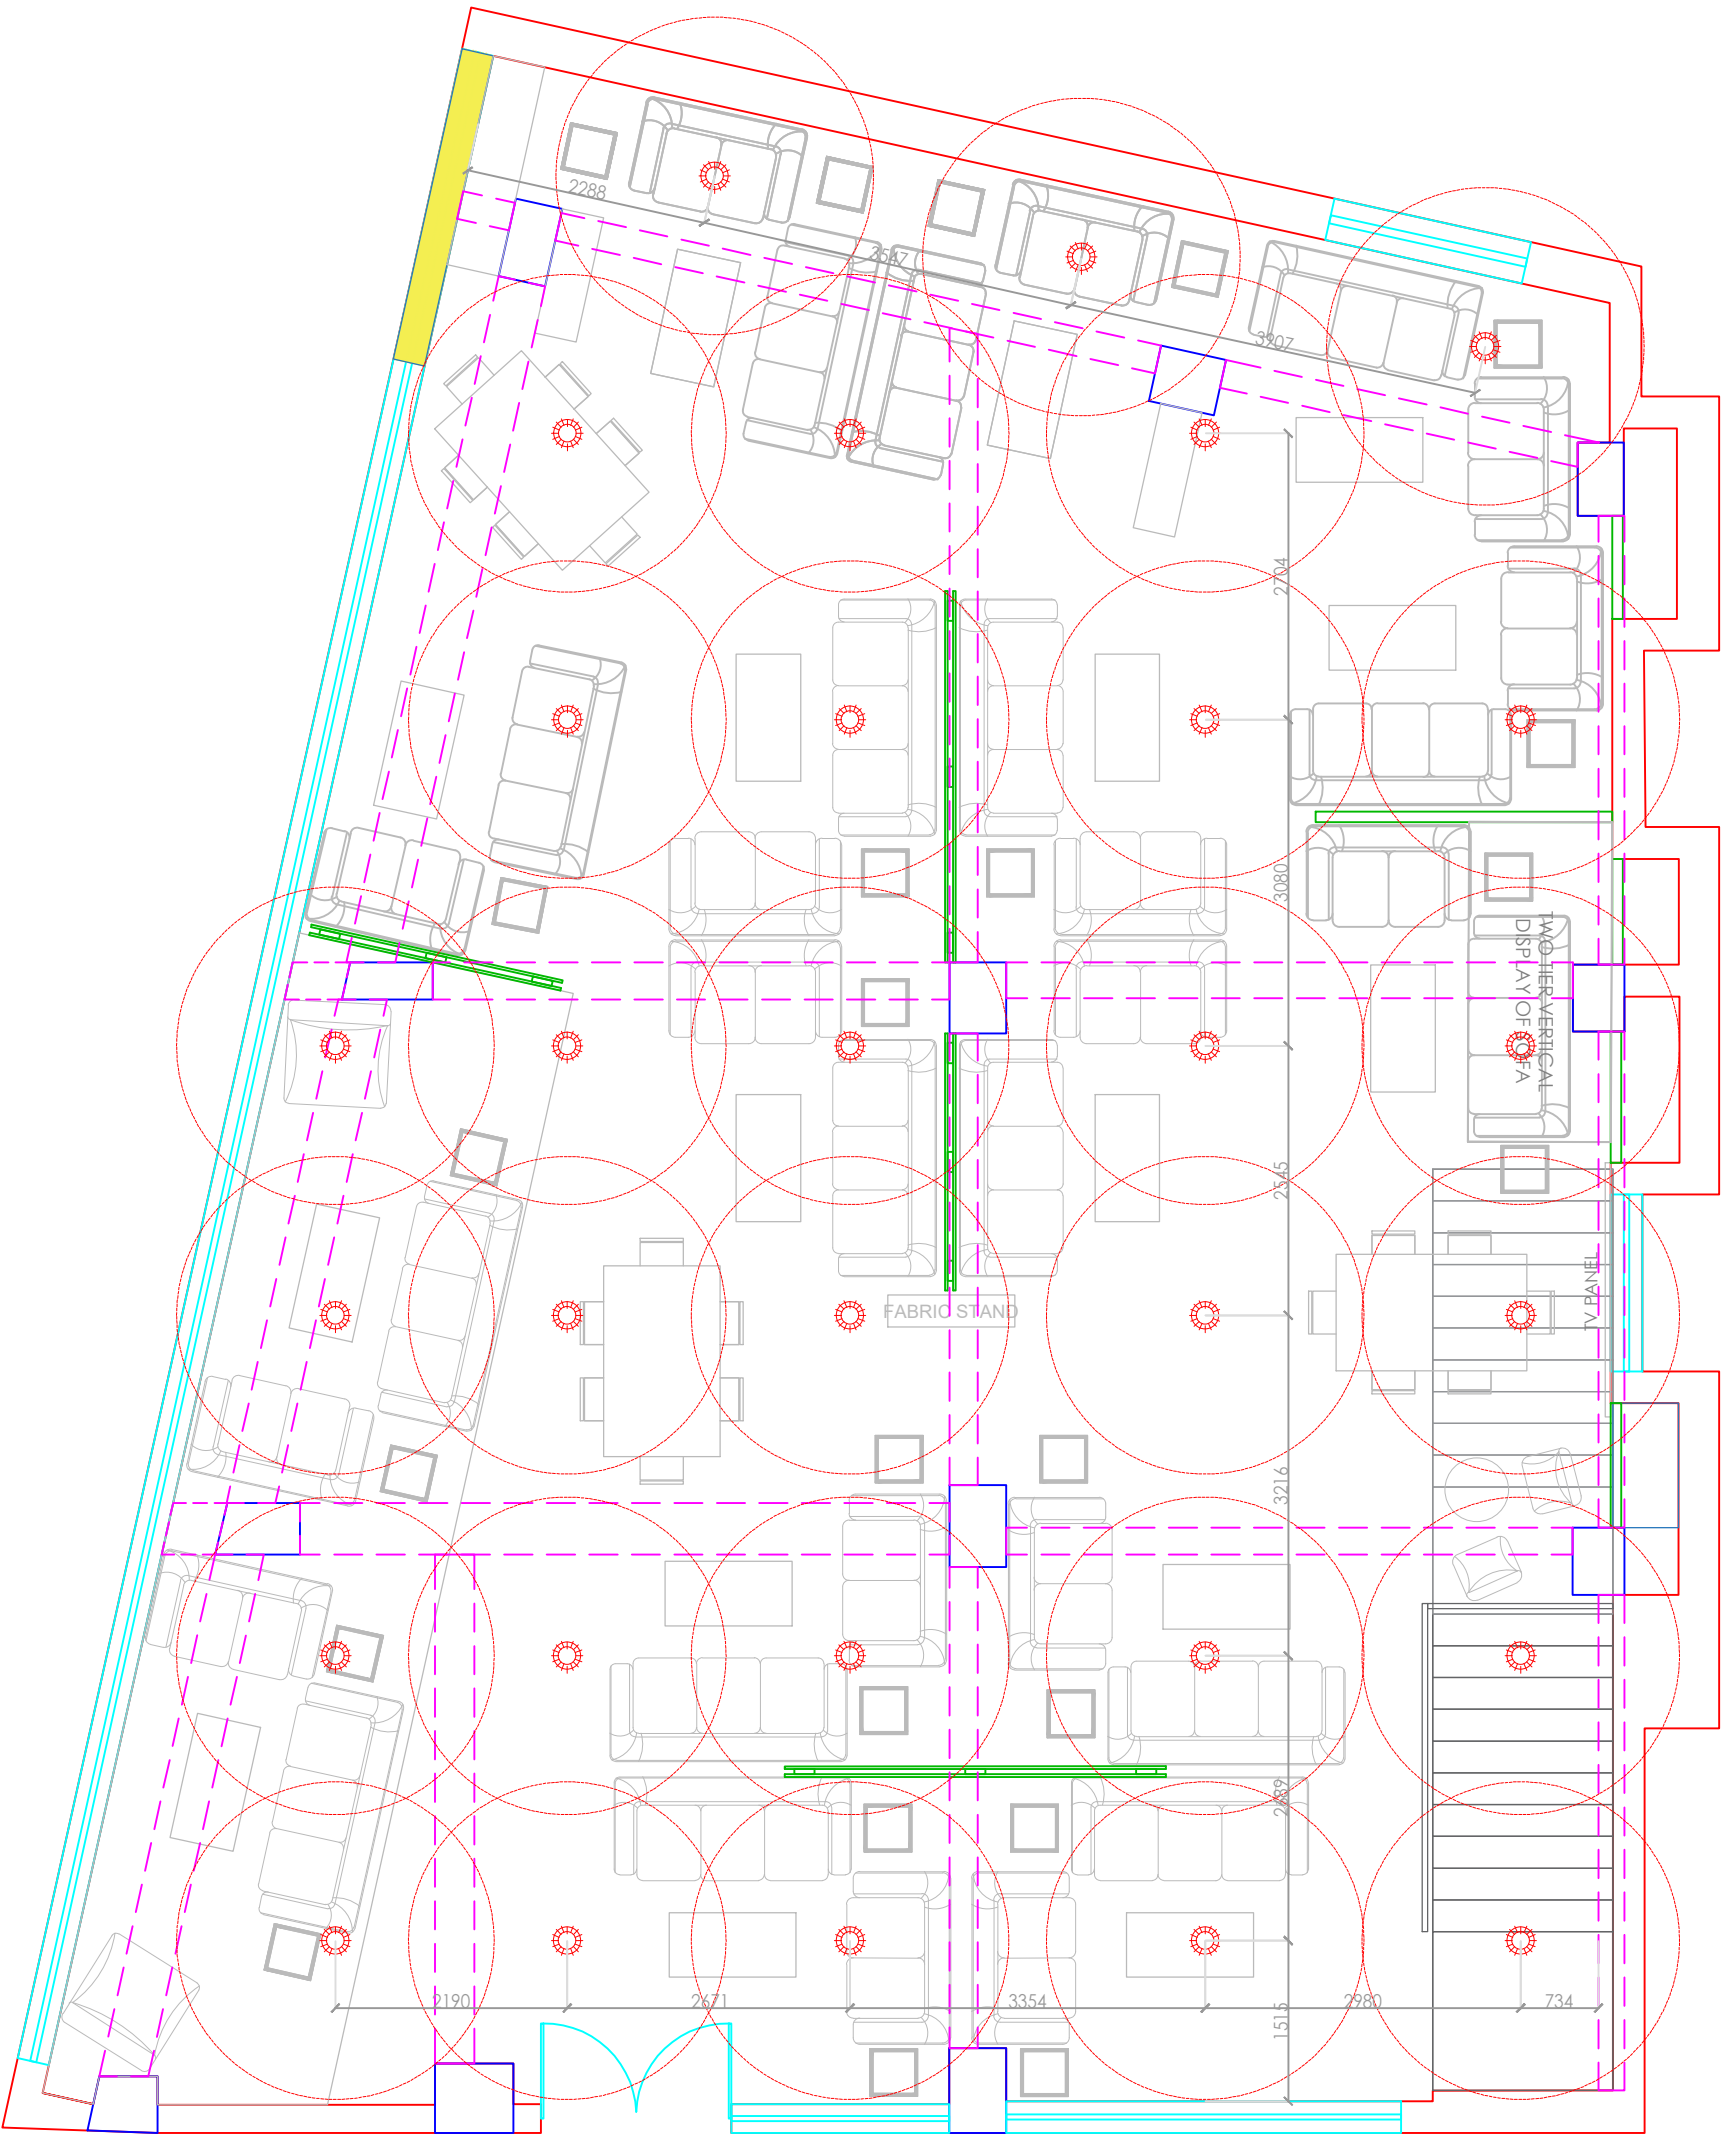




DESCRIPTION :

Site Name :
Guwahati


Layout : Second Floor
Bed Section Sprinkler
Layout


Area:
7175.83 sft

NOTE :
Beds - 11nos.
Office table - 02nos

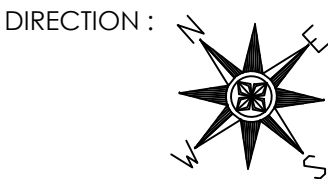

FORMAT : A3
DRAWN BY : Jigar Panchal
DATE: 19-12-2023
DATE OF EDIT:

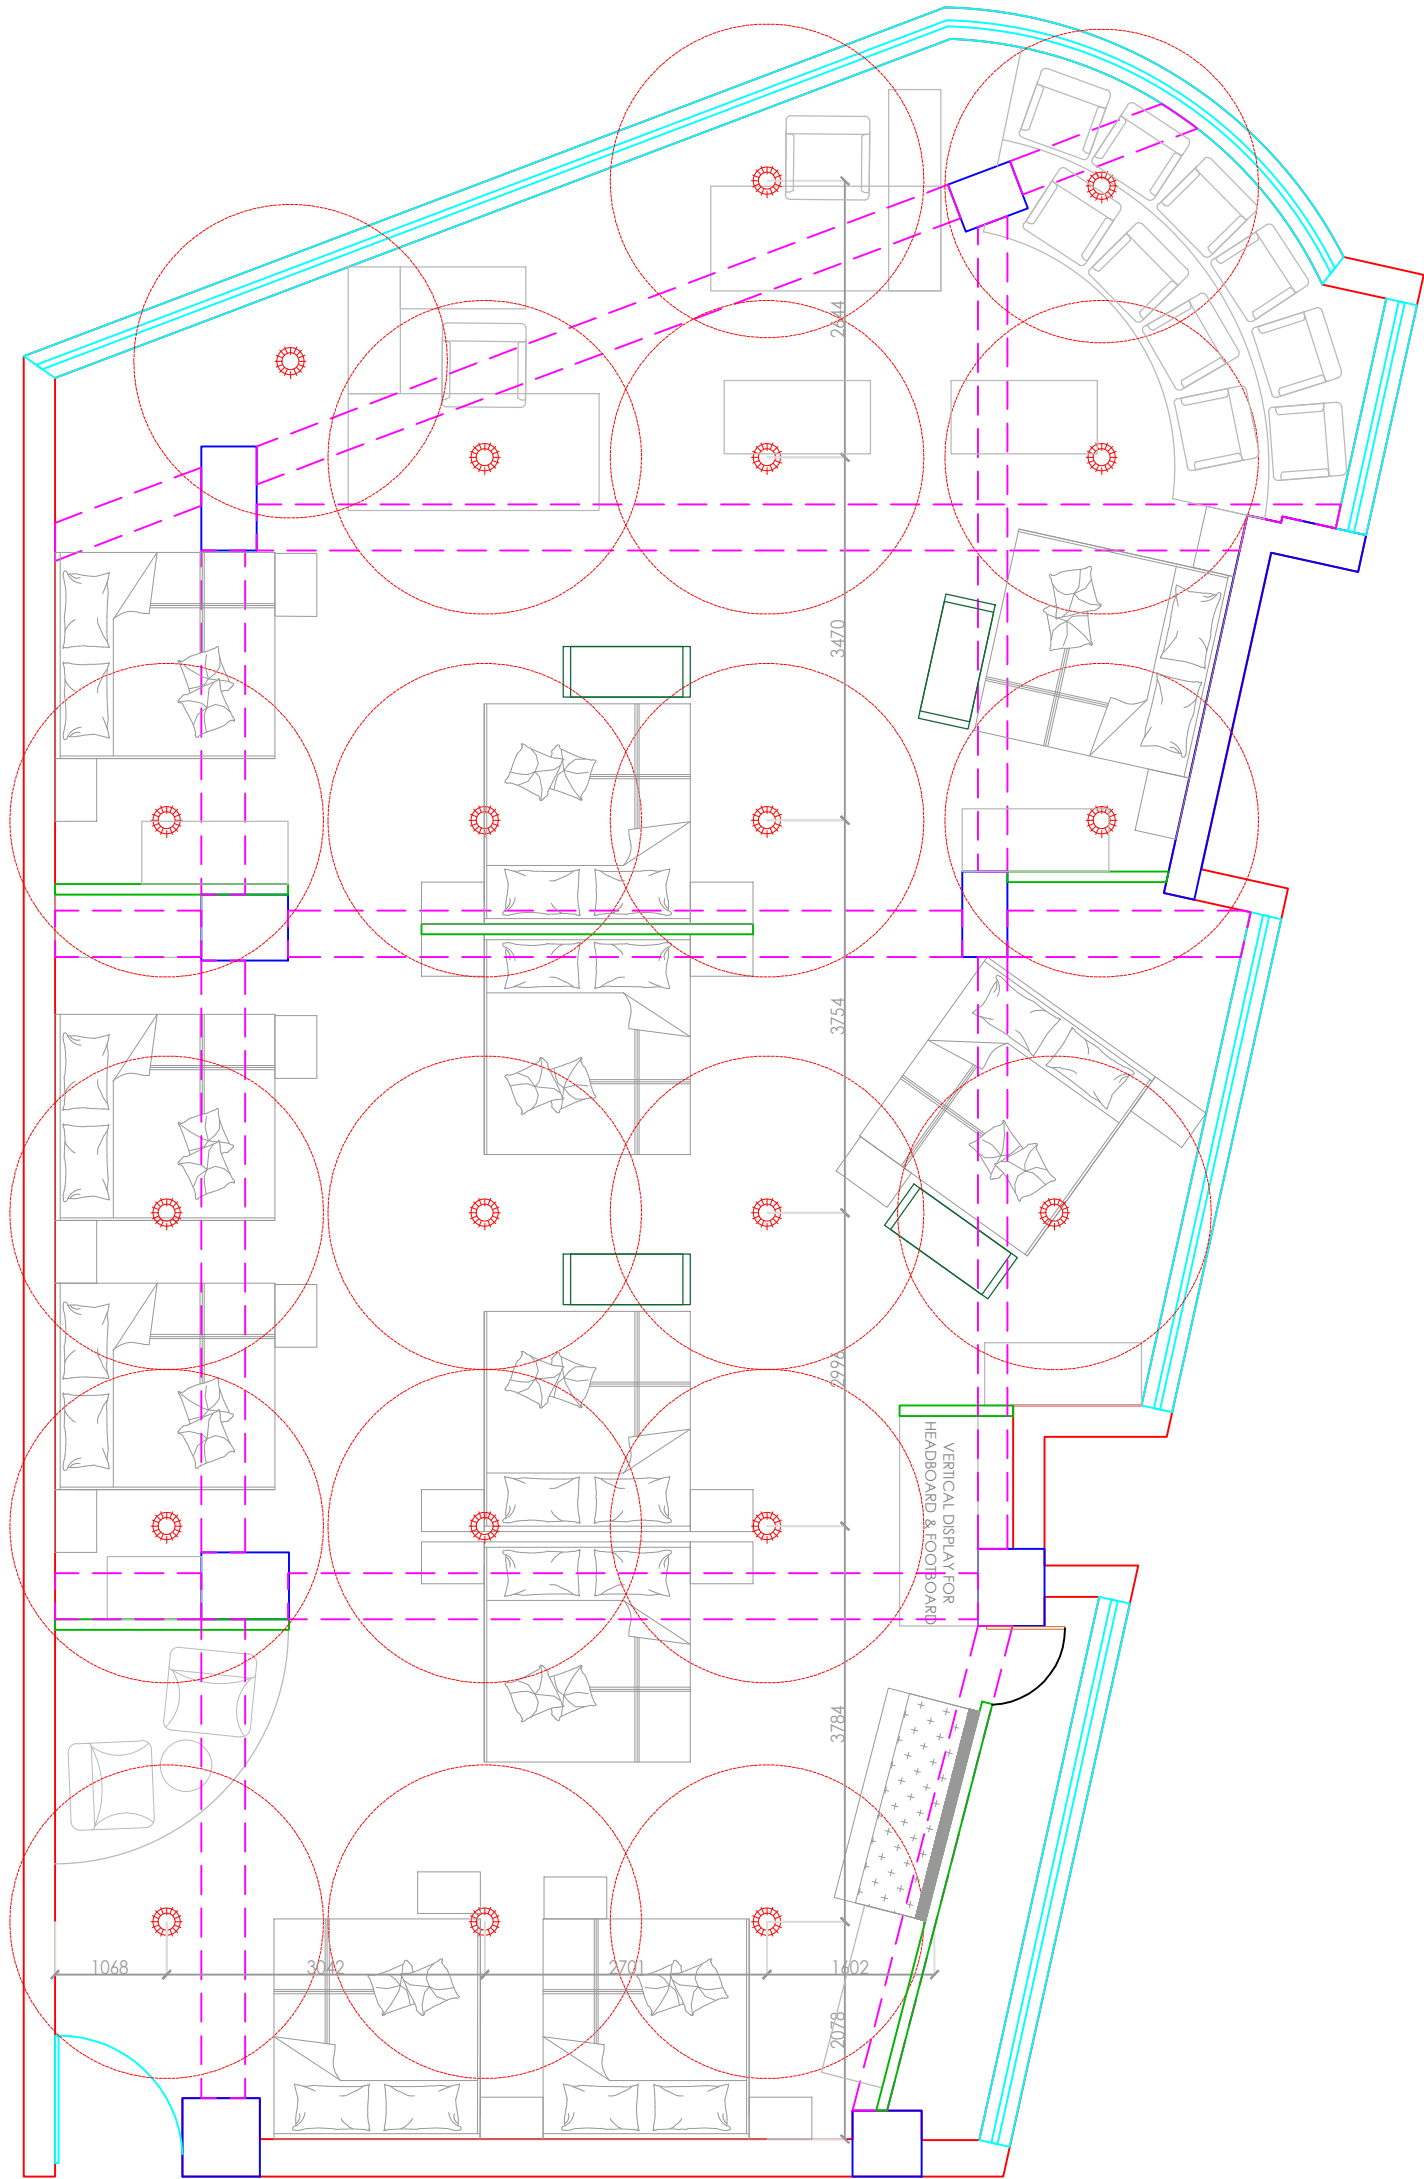

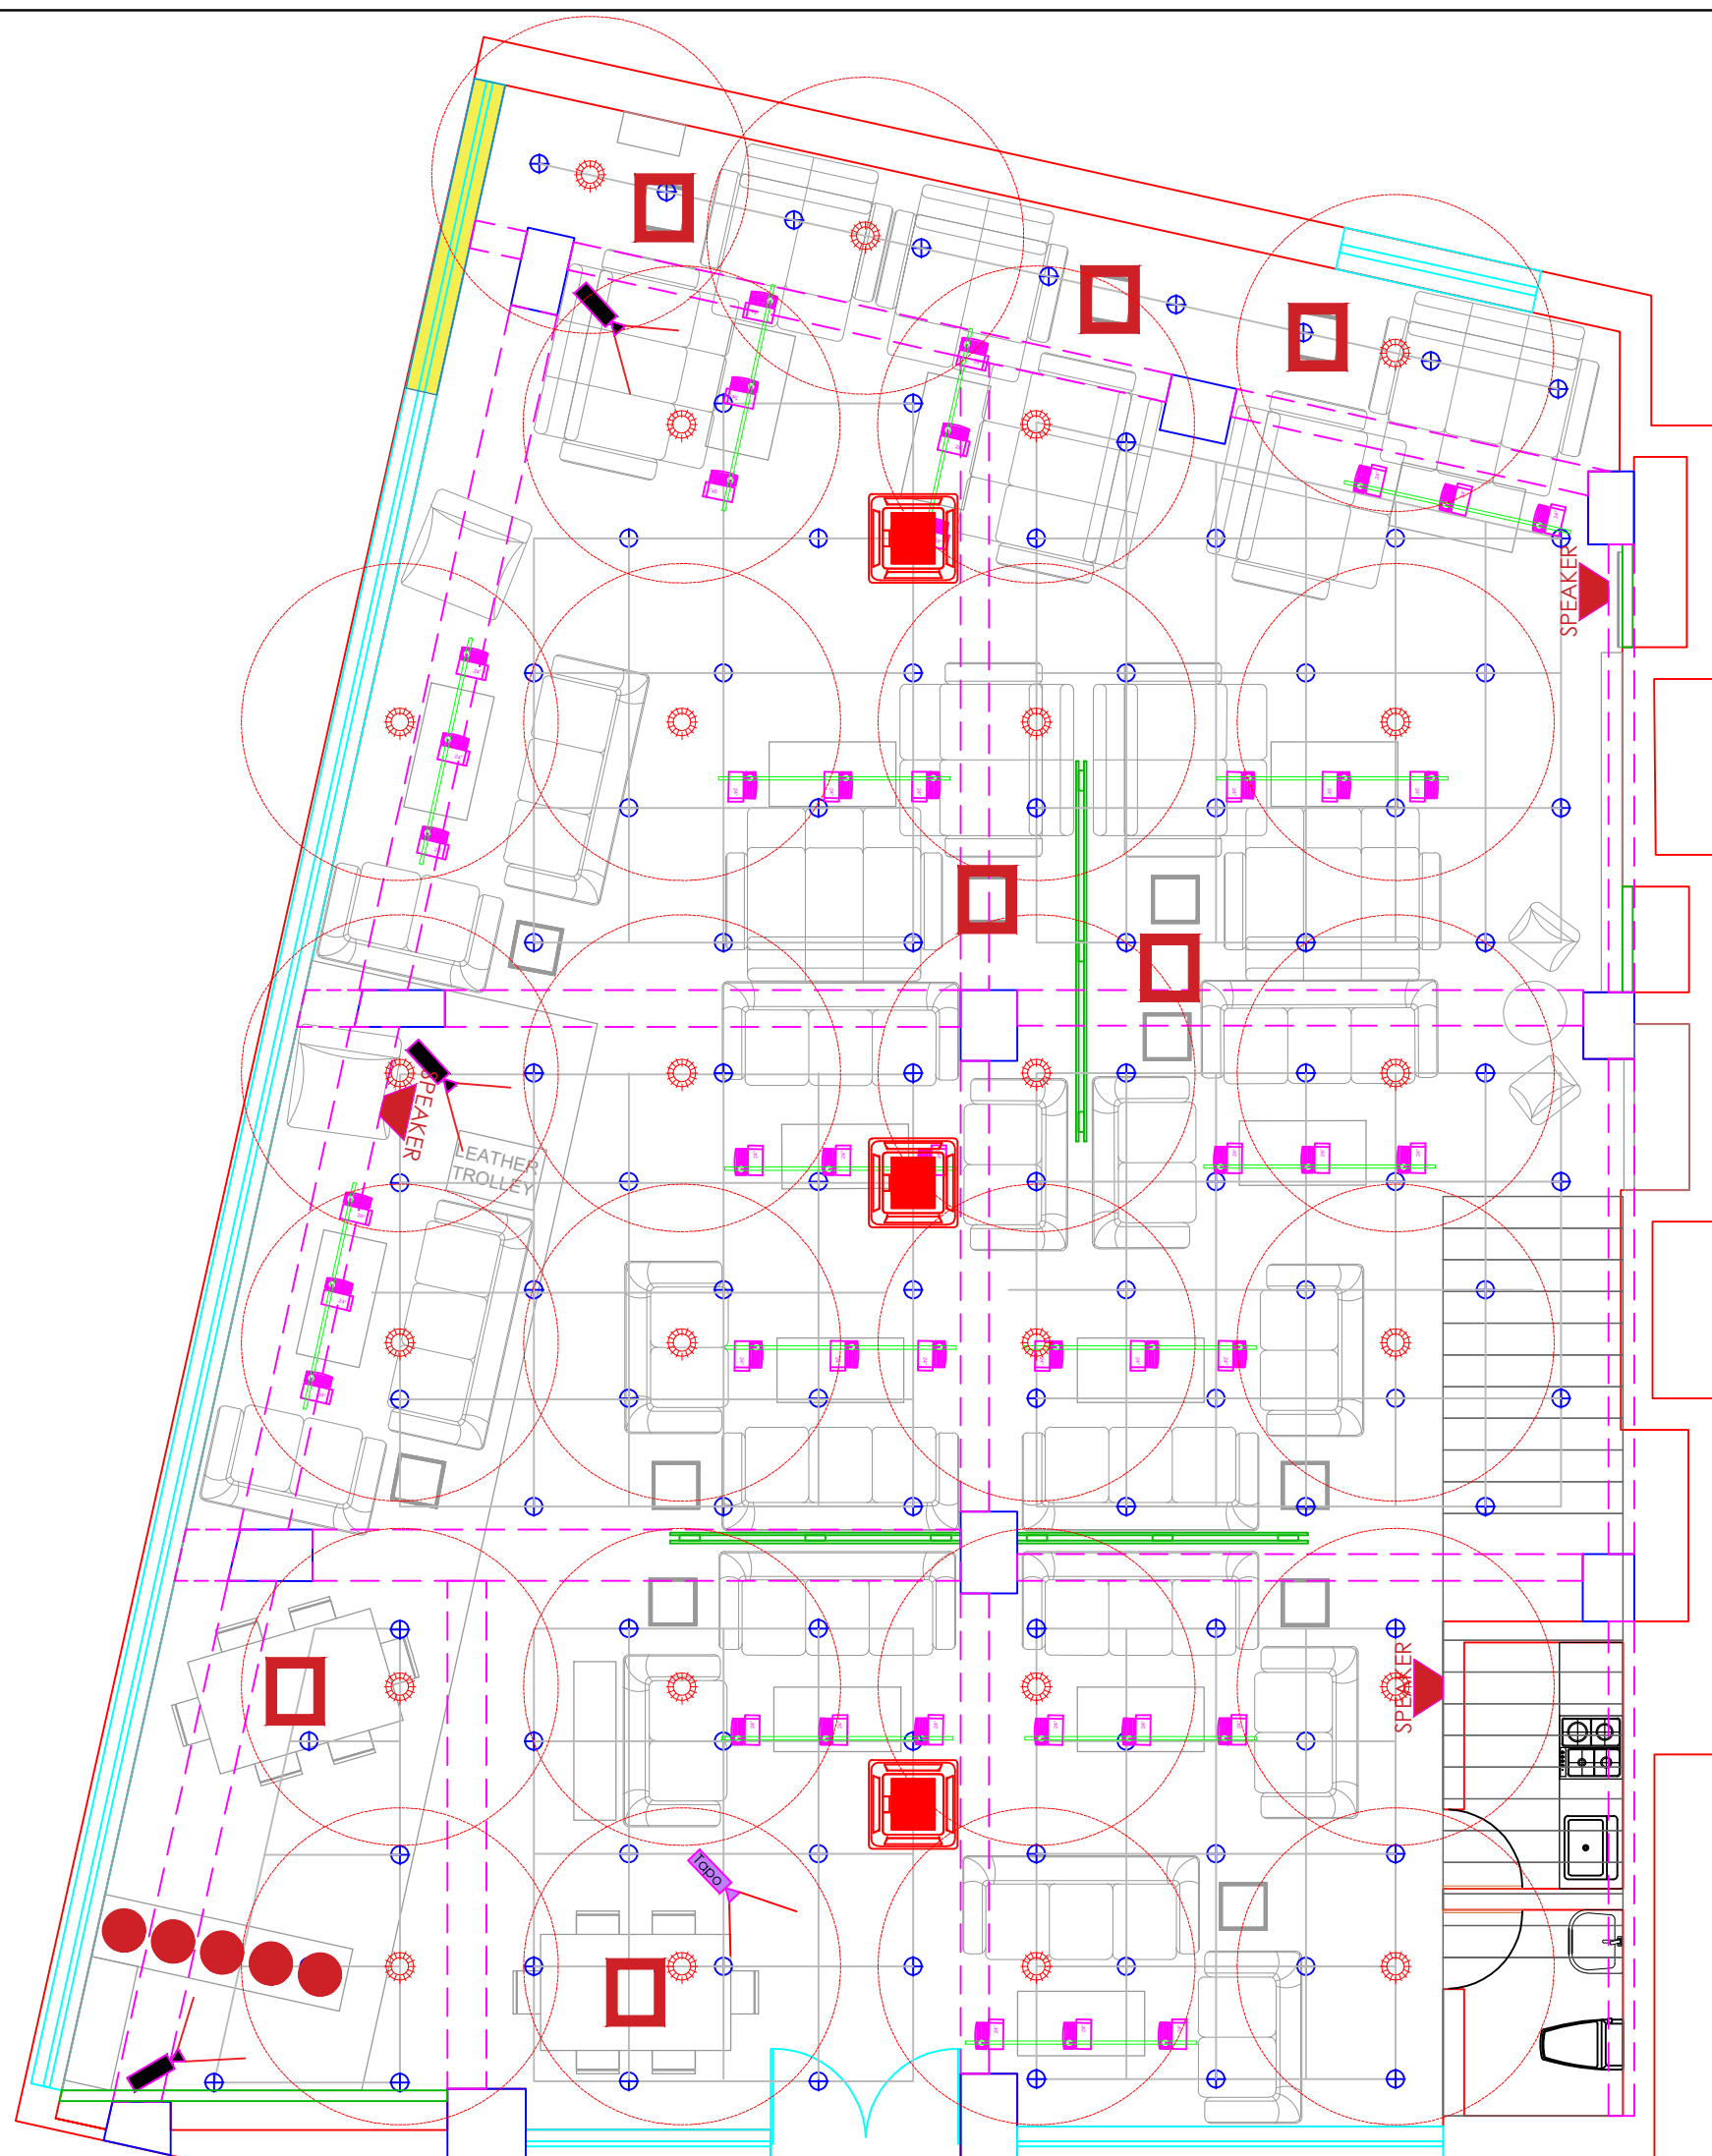

Site Name :	Guwahati
-------------	----------

Layout : First floor
Sofa section
Combined RCP Layout

Area:
7175.83 sft

NOTE :

Sofa Sets - 14nos.
Dining Set - 02nos.

DIRECTION :



FORMAT : A3

DRAWN BY : Jigar Panchal

DATE: 19-12-2023

DATE OF EDIT:



DESCRIPTION :

Site Name :
Guwahati

Layout : Second floor
Sofa section
Combined RCP Layout

Area:
7175.83 sft

NOTE :
Sofa Sets - 16nos.
Dining Set - 03nos.

DIRECTION :




FORMAT : A3

DRAWN BY : Jigar Panchal

DATE: 19-12-2023

DATE OF EDIT:

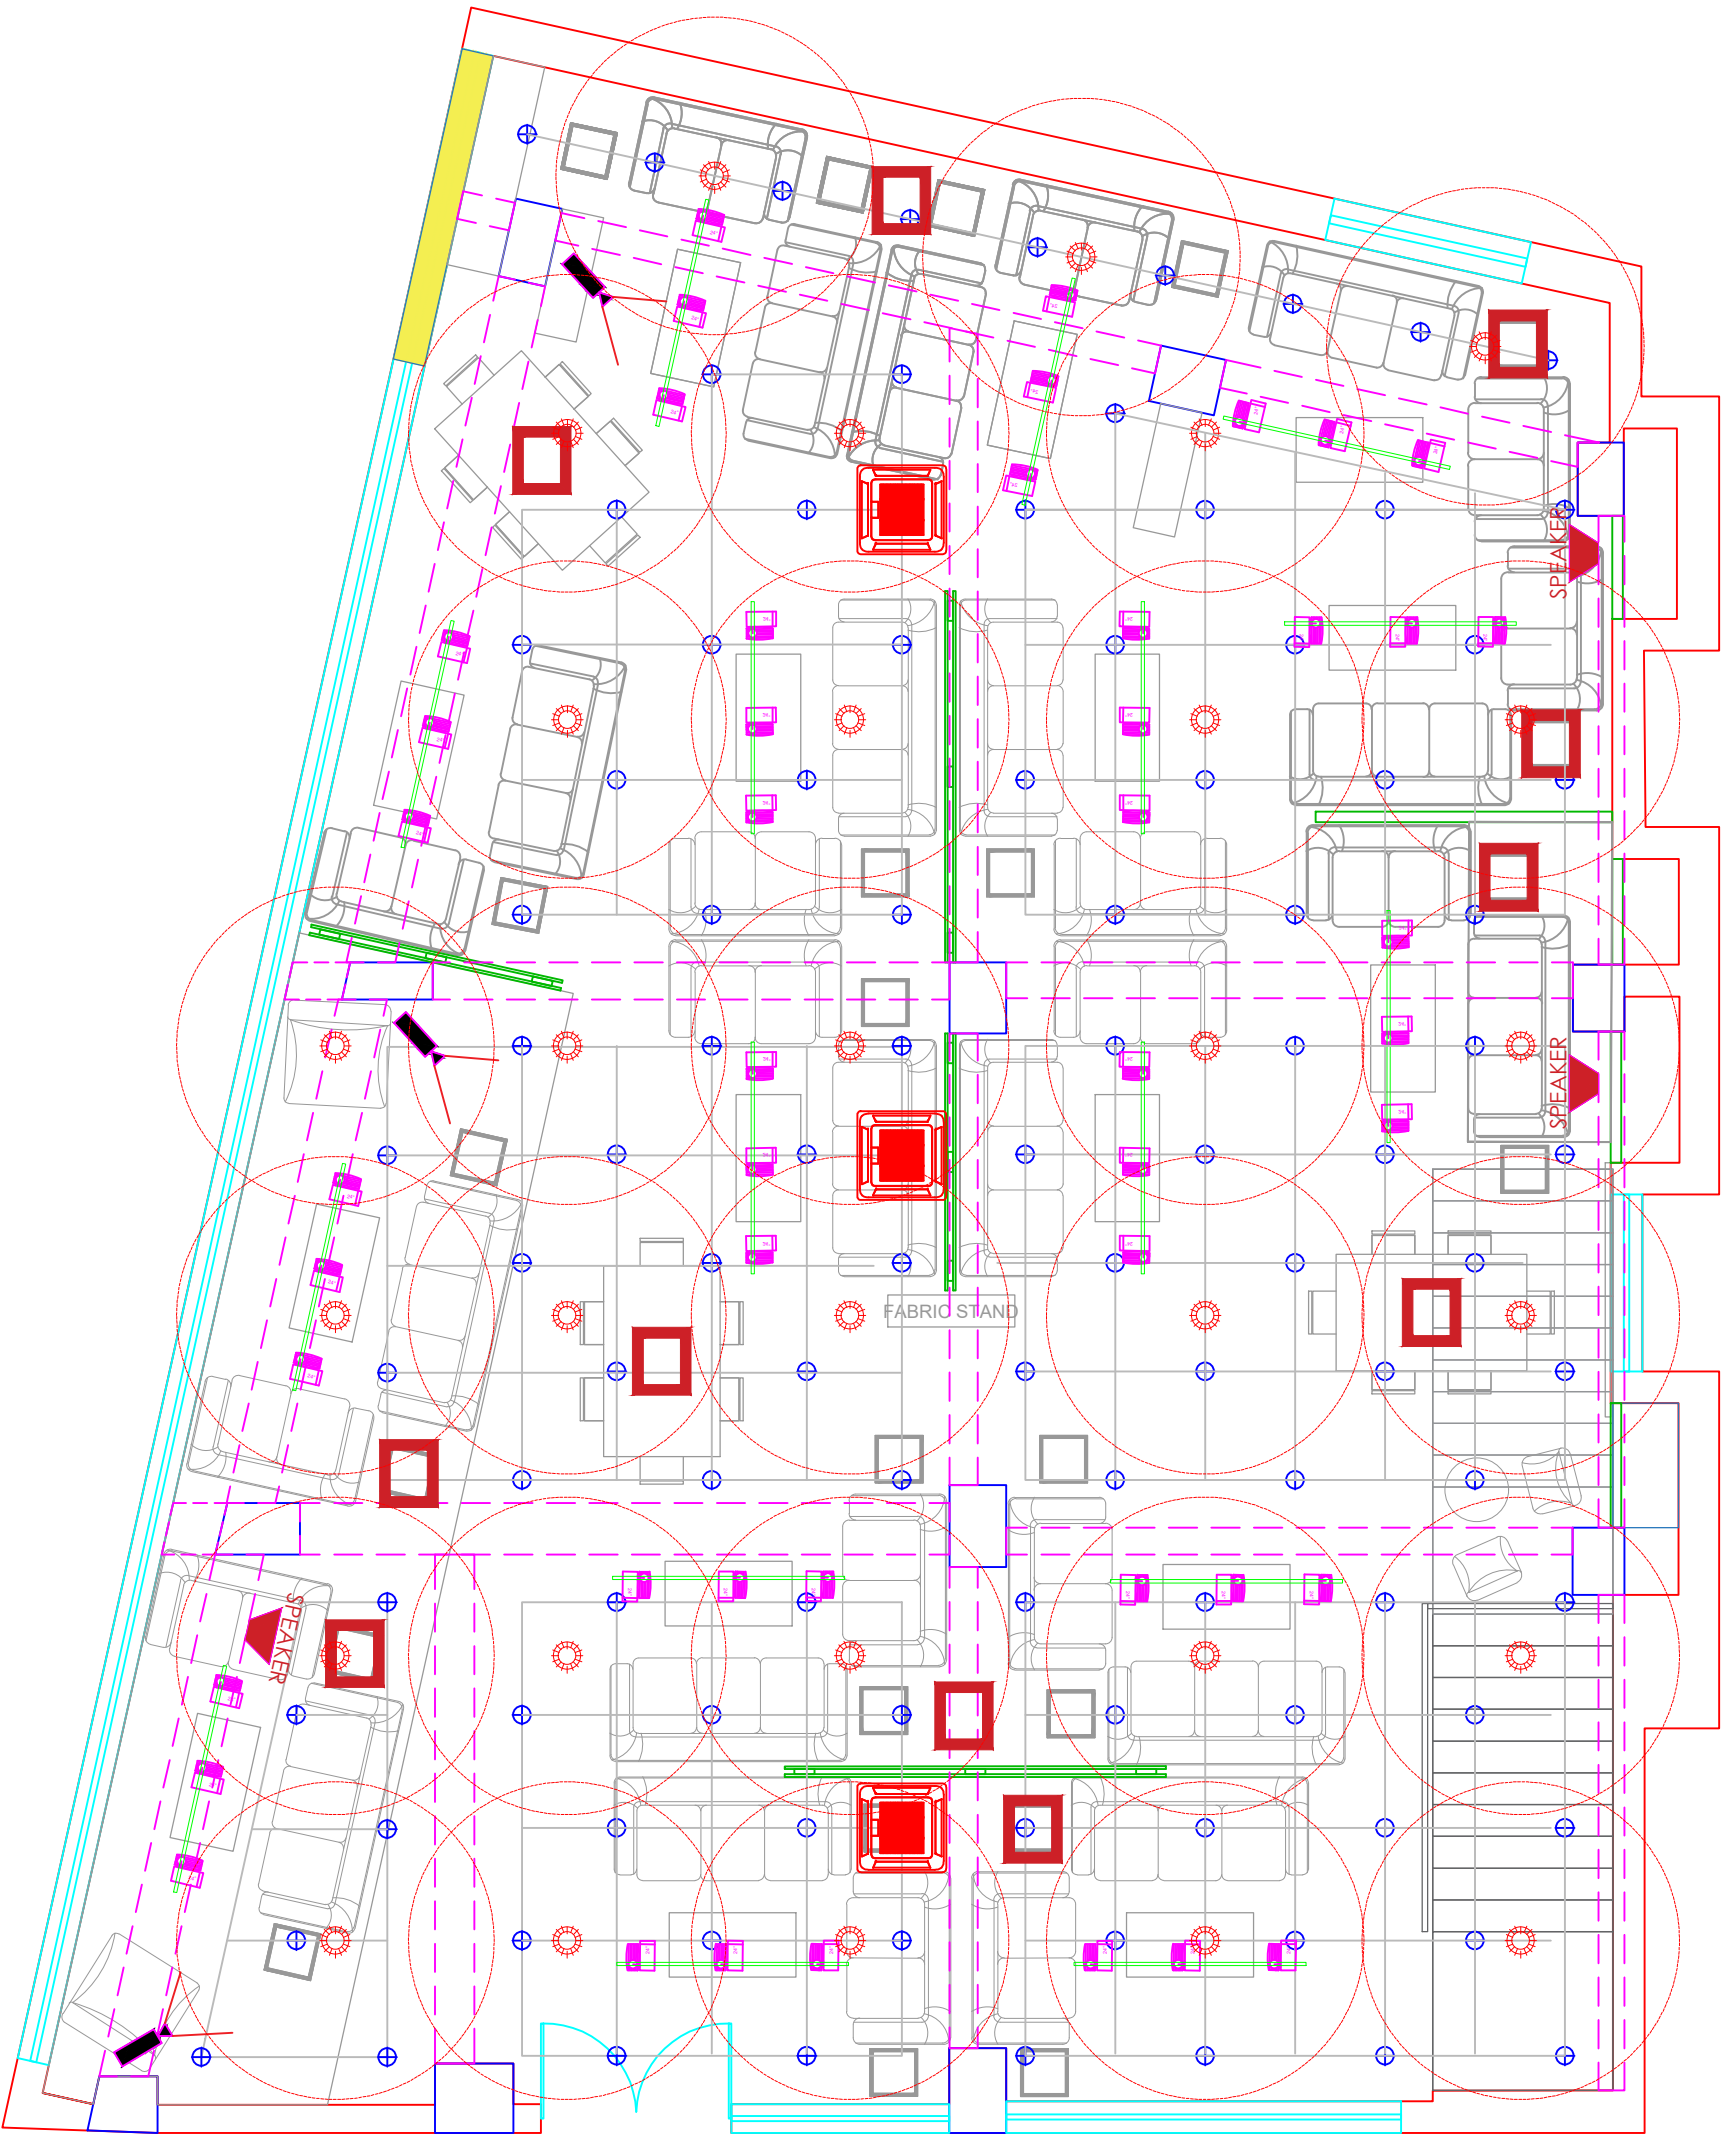



DESCRIPTION :

Site Name :
Guwahati

Layout : Second Floor
Bed Section Combined
RCP Layout

Area:
7175.83 sft

NOTE :
Beds - 11nos.
Office table - 02nos

DIRECTION :




FORMAT : A3

DRAWN BY : Jigar Panchal

DATE: 19-12-2023

DATE OF EDIT:

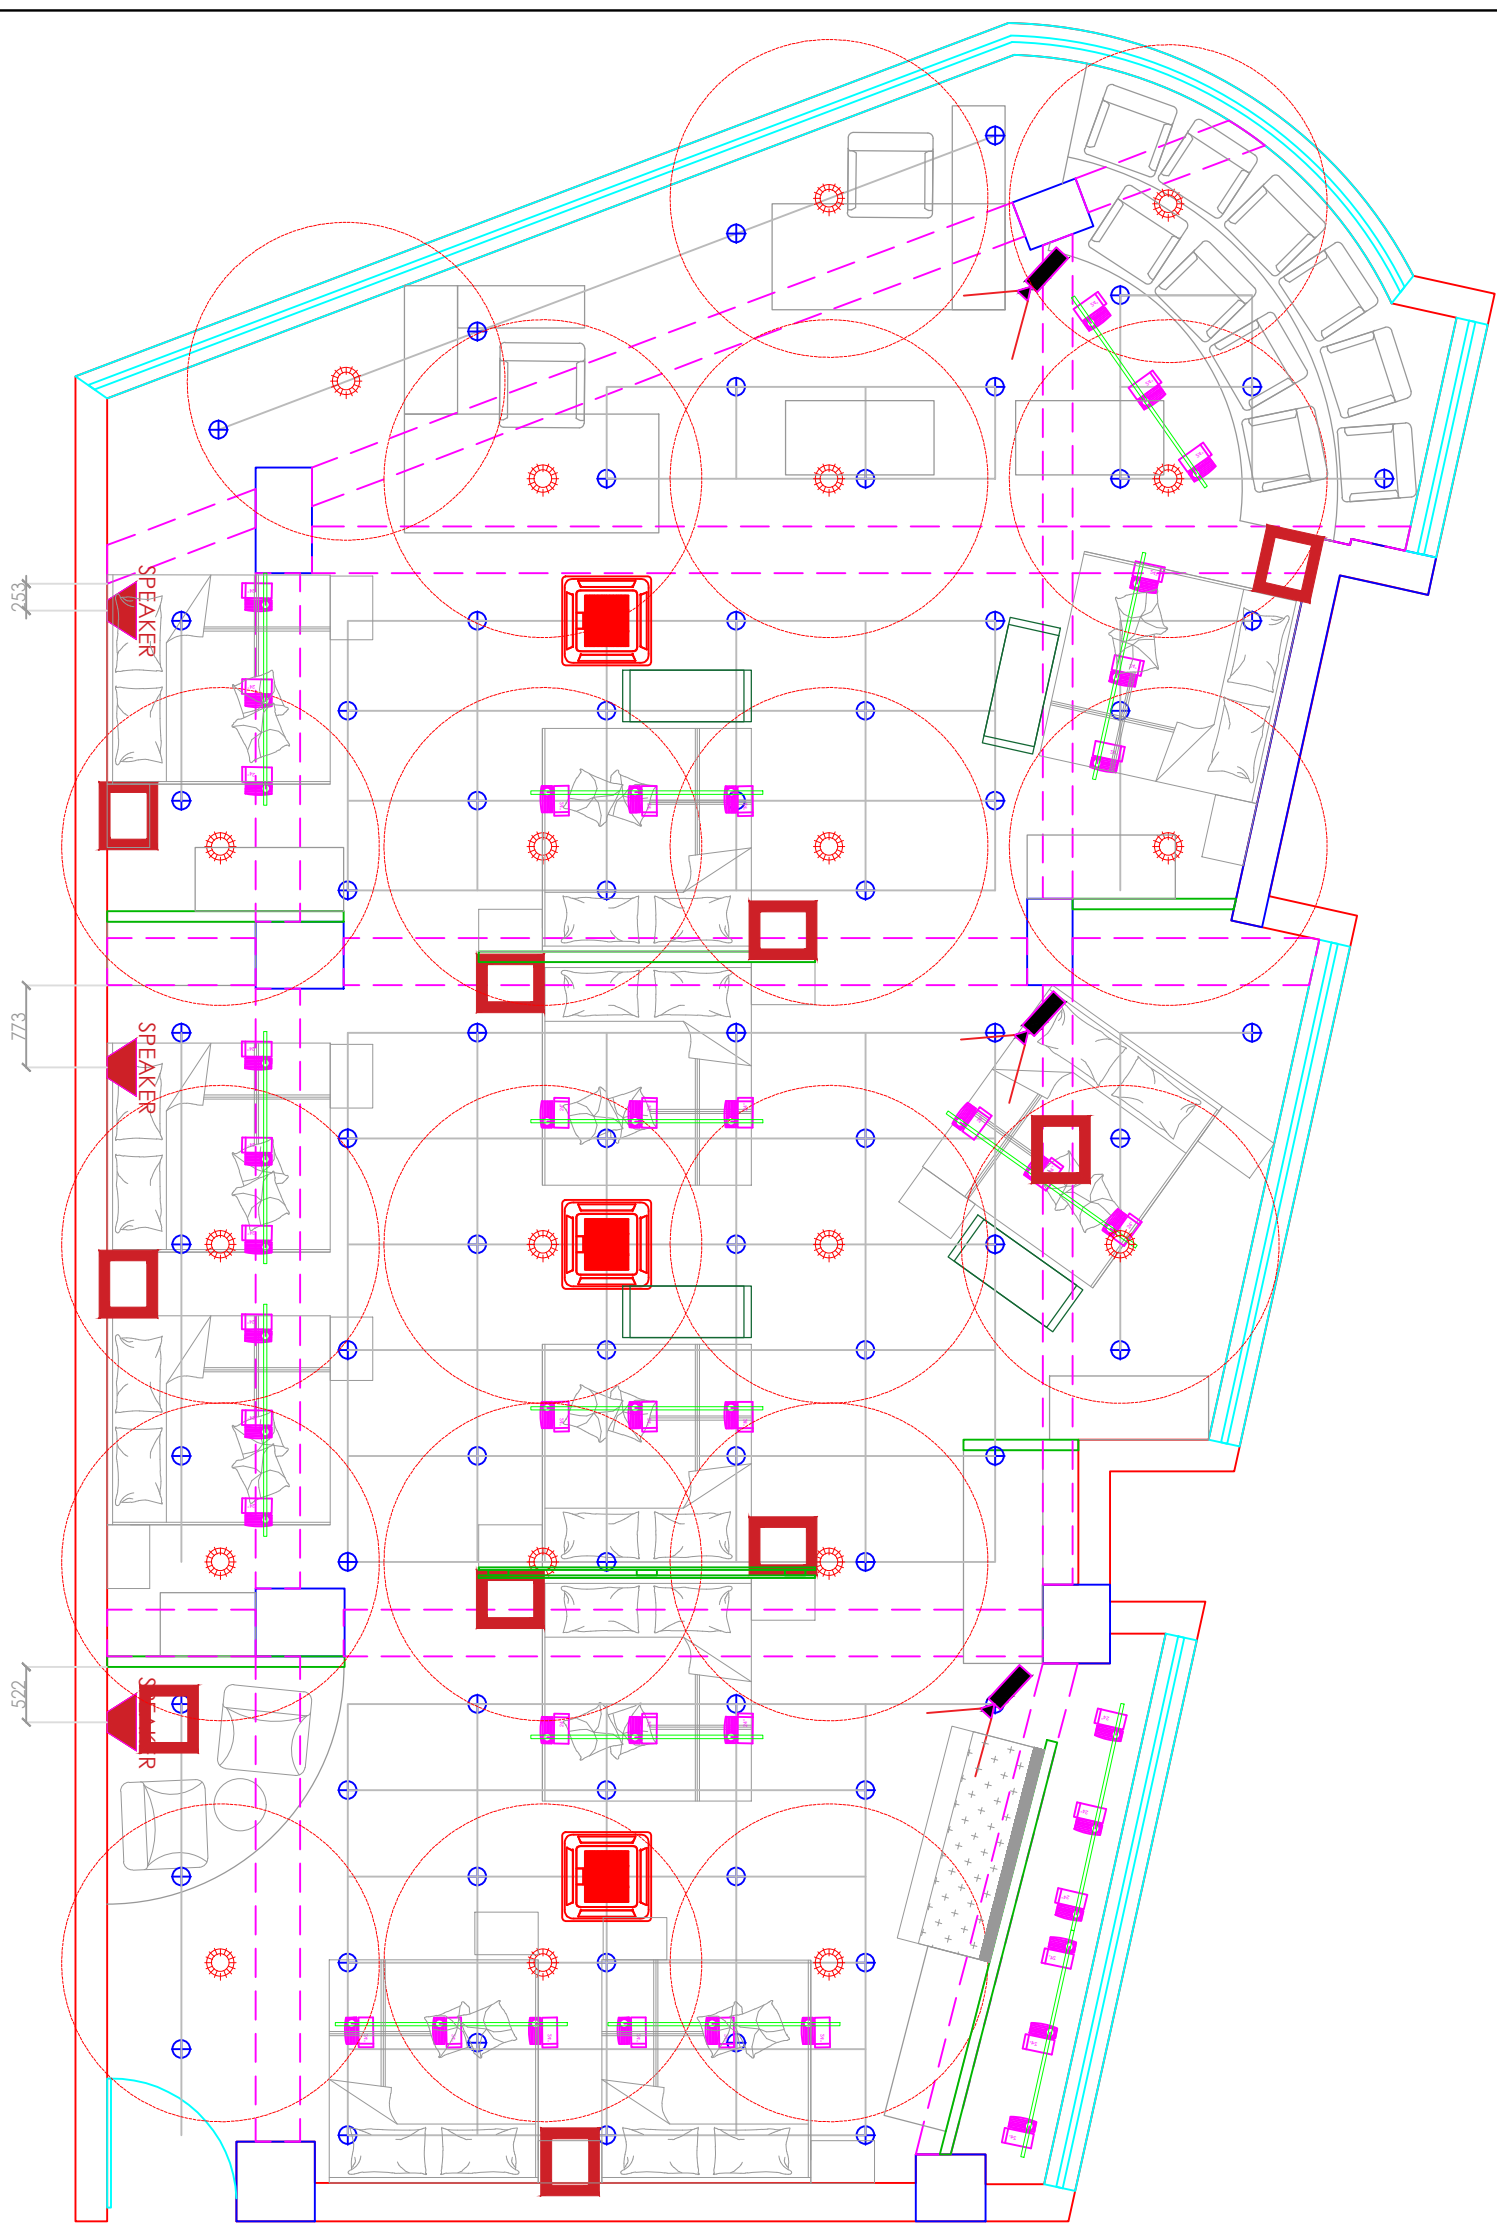




DESCRIPTION :

Site Name :
Guwahati


Layout : First floor
Sofa section Wall
Treatment Layout

Area:
7175.83 sft

NOTE :
Sofa Sets - 14nos.
Dining Set - 02nos.

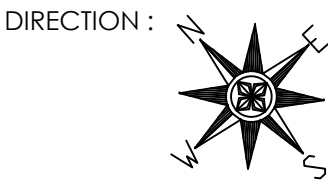

FORMAT : A3
DRAWN BY : Jigar Panchal
DATE: 19-12-2023
DATE OF EDIT:

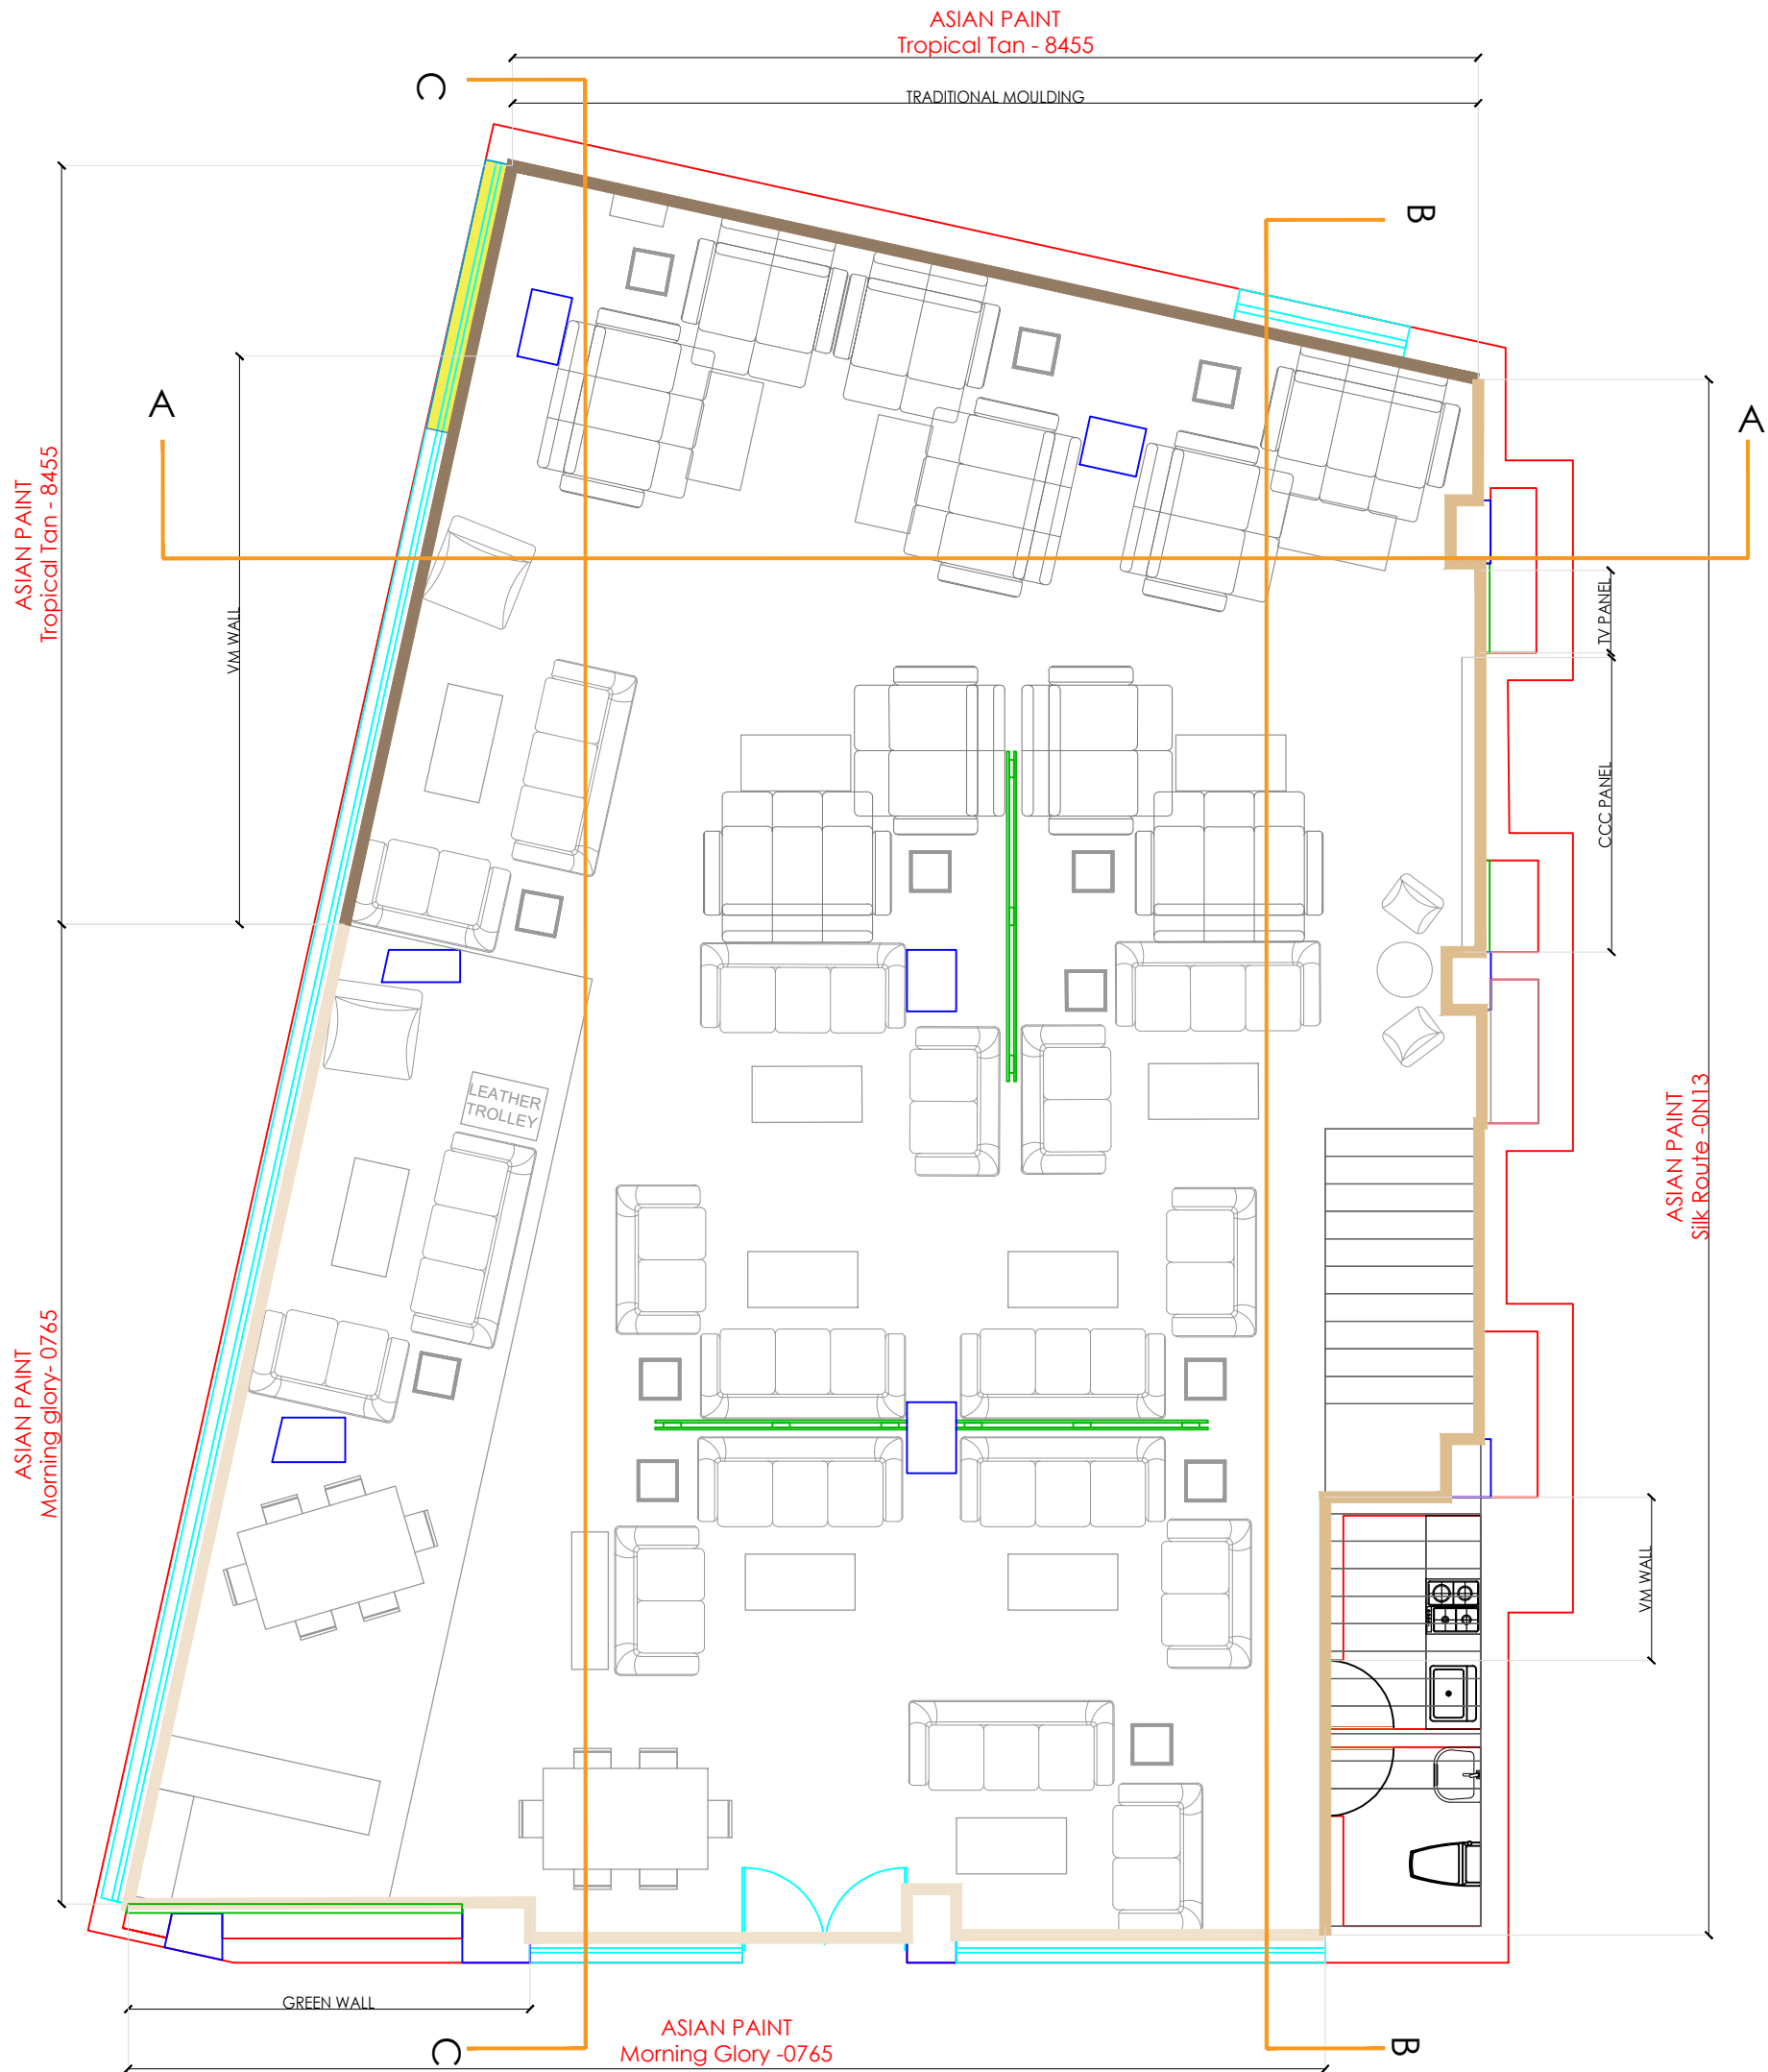




DESCRIPTION :

Site Name :
Guwahati

Layout : Second floor
Sofa section Wall
Treatment Layout

Area:
7175.83 sft

NOTE :
Sofa Sets - 16nos.
Dining Set - 03nos.

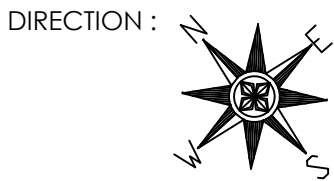



FORMAT : A3



DRAWN BY : Jigar Panchal

DATE: 19-12-2023

DATE OF EDIT:

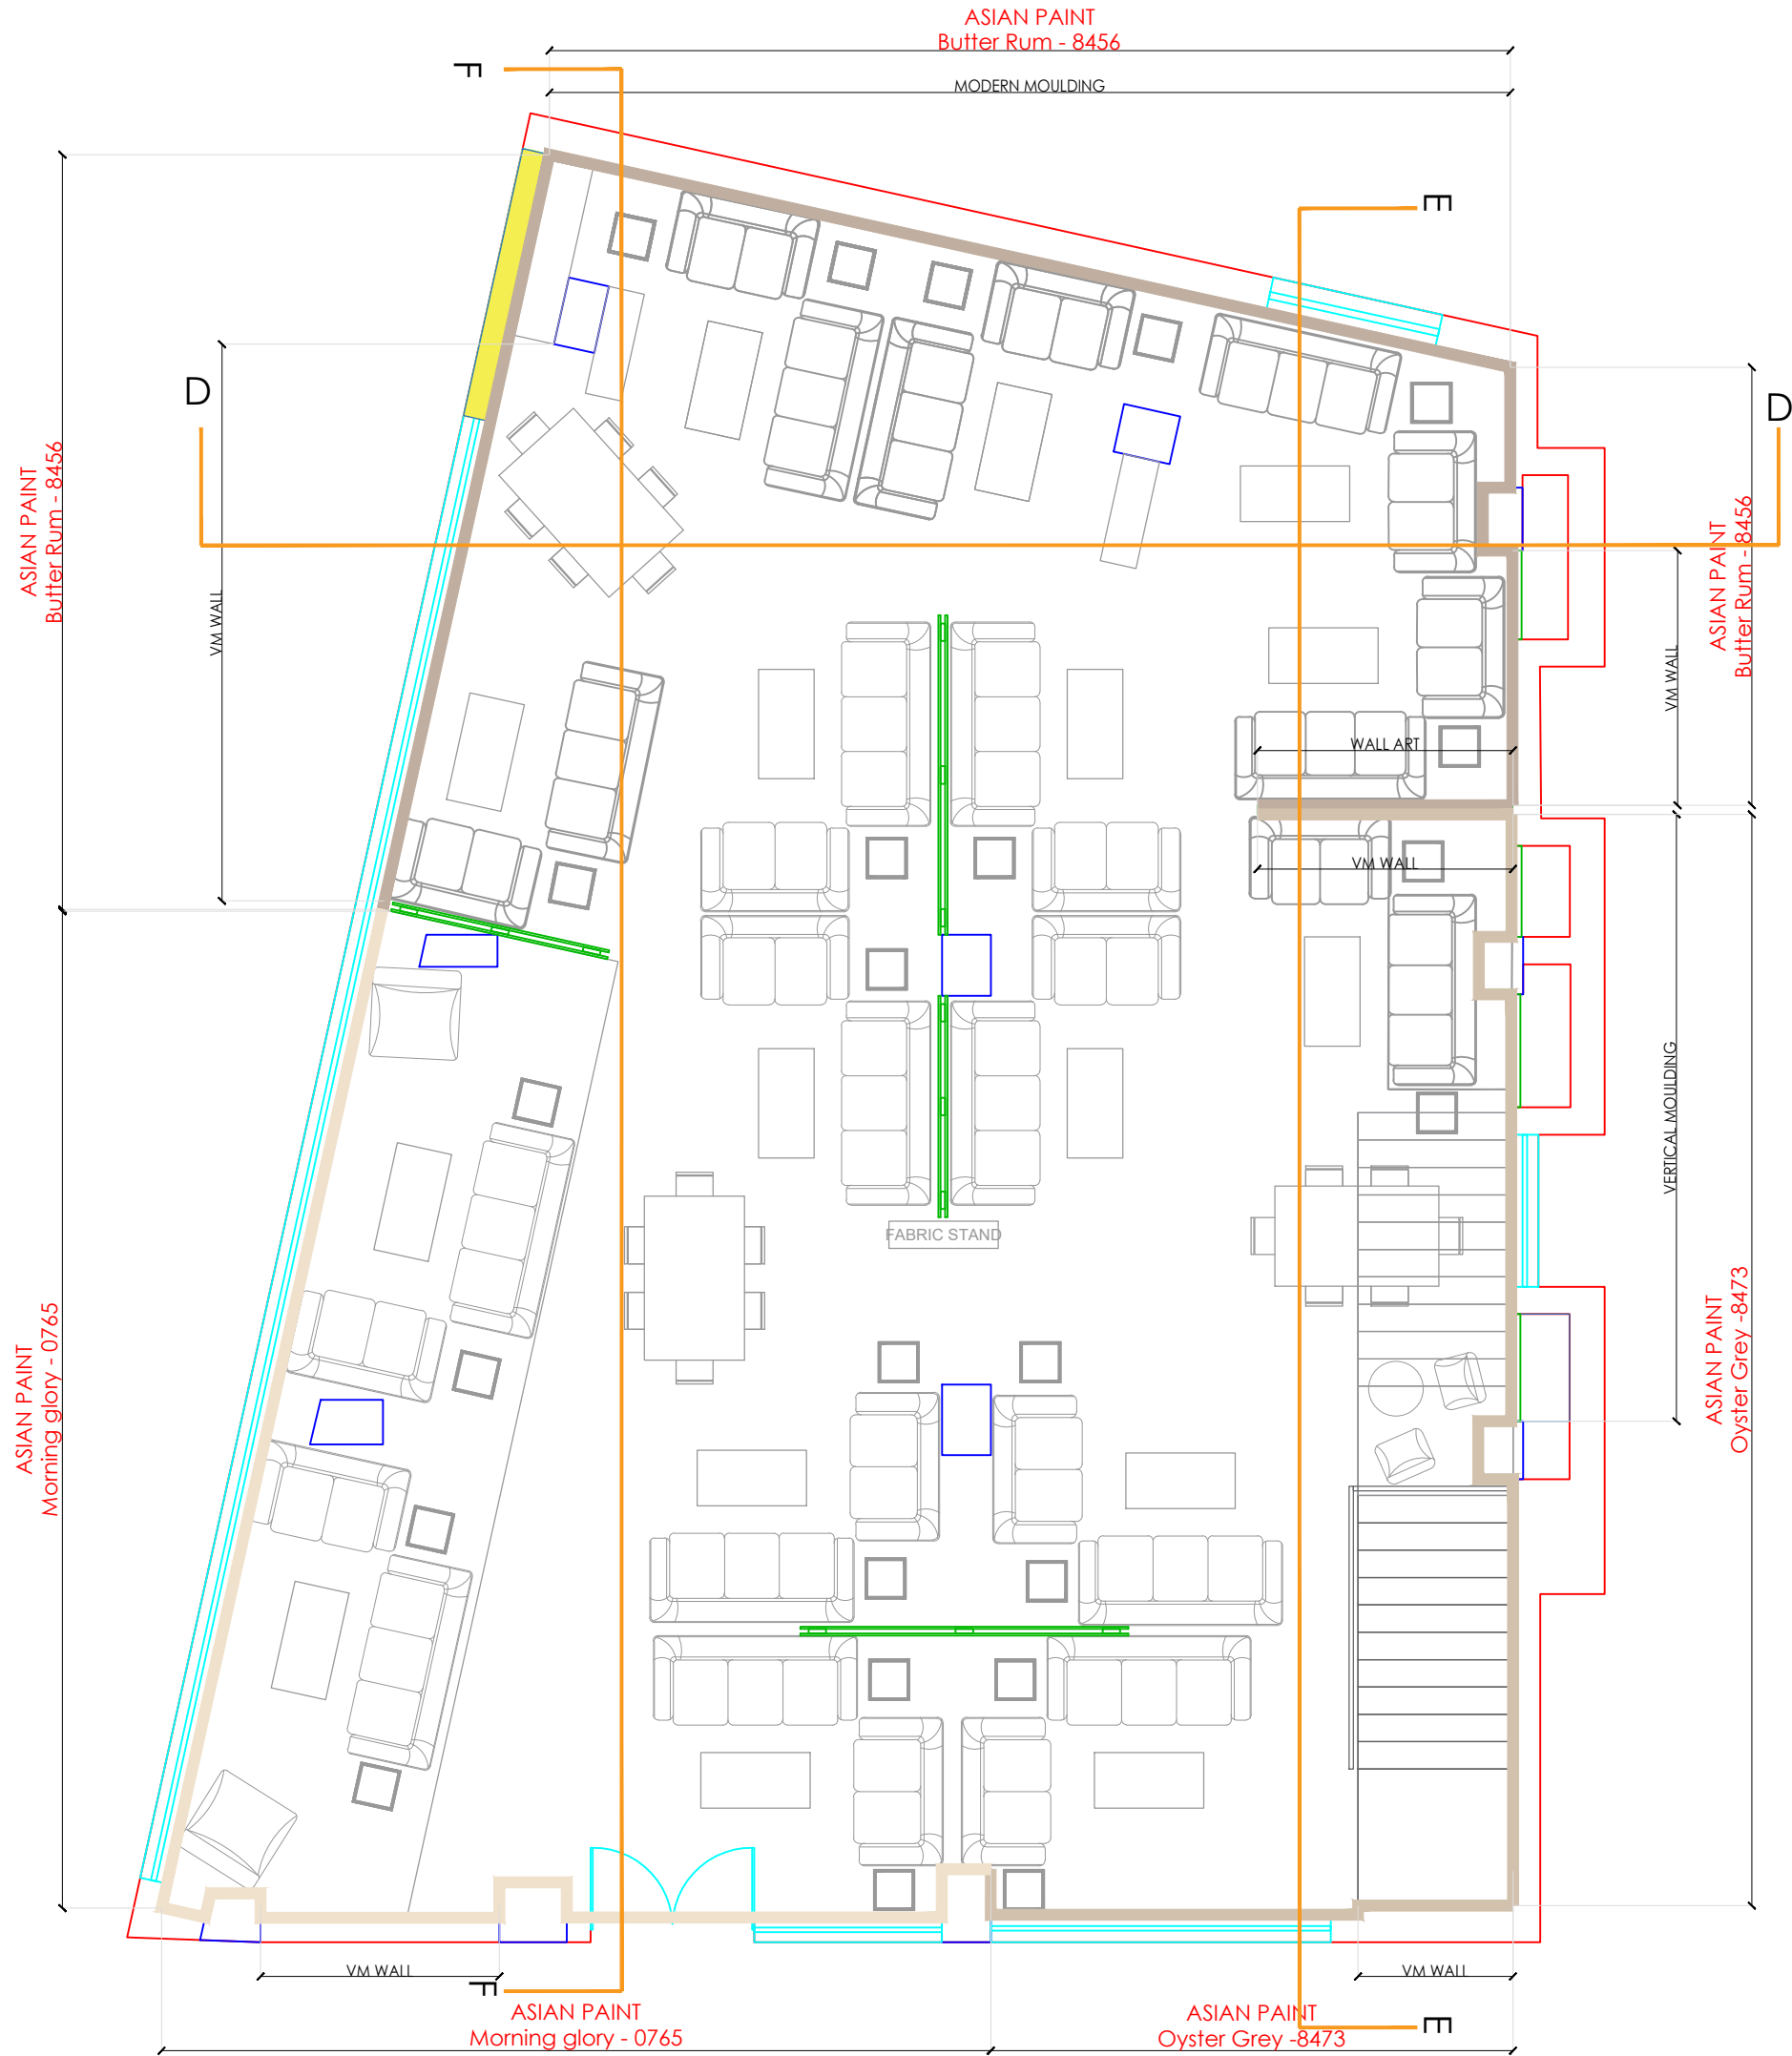

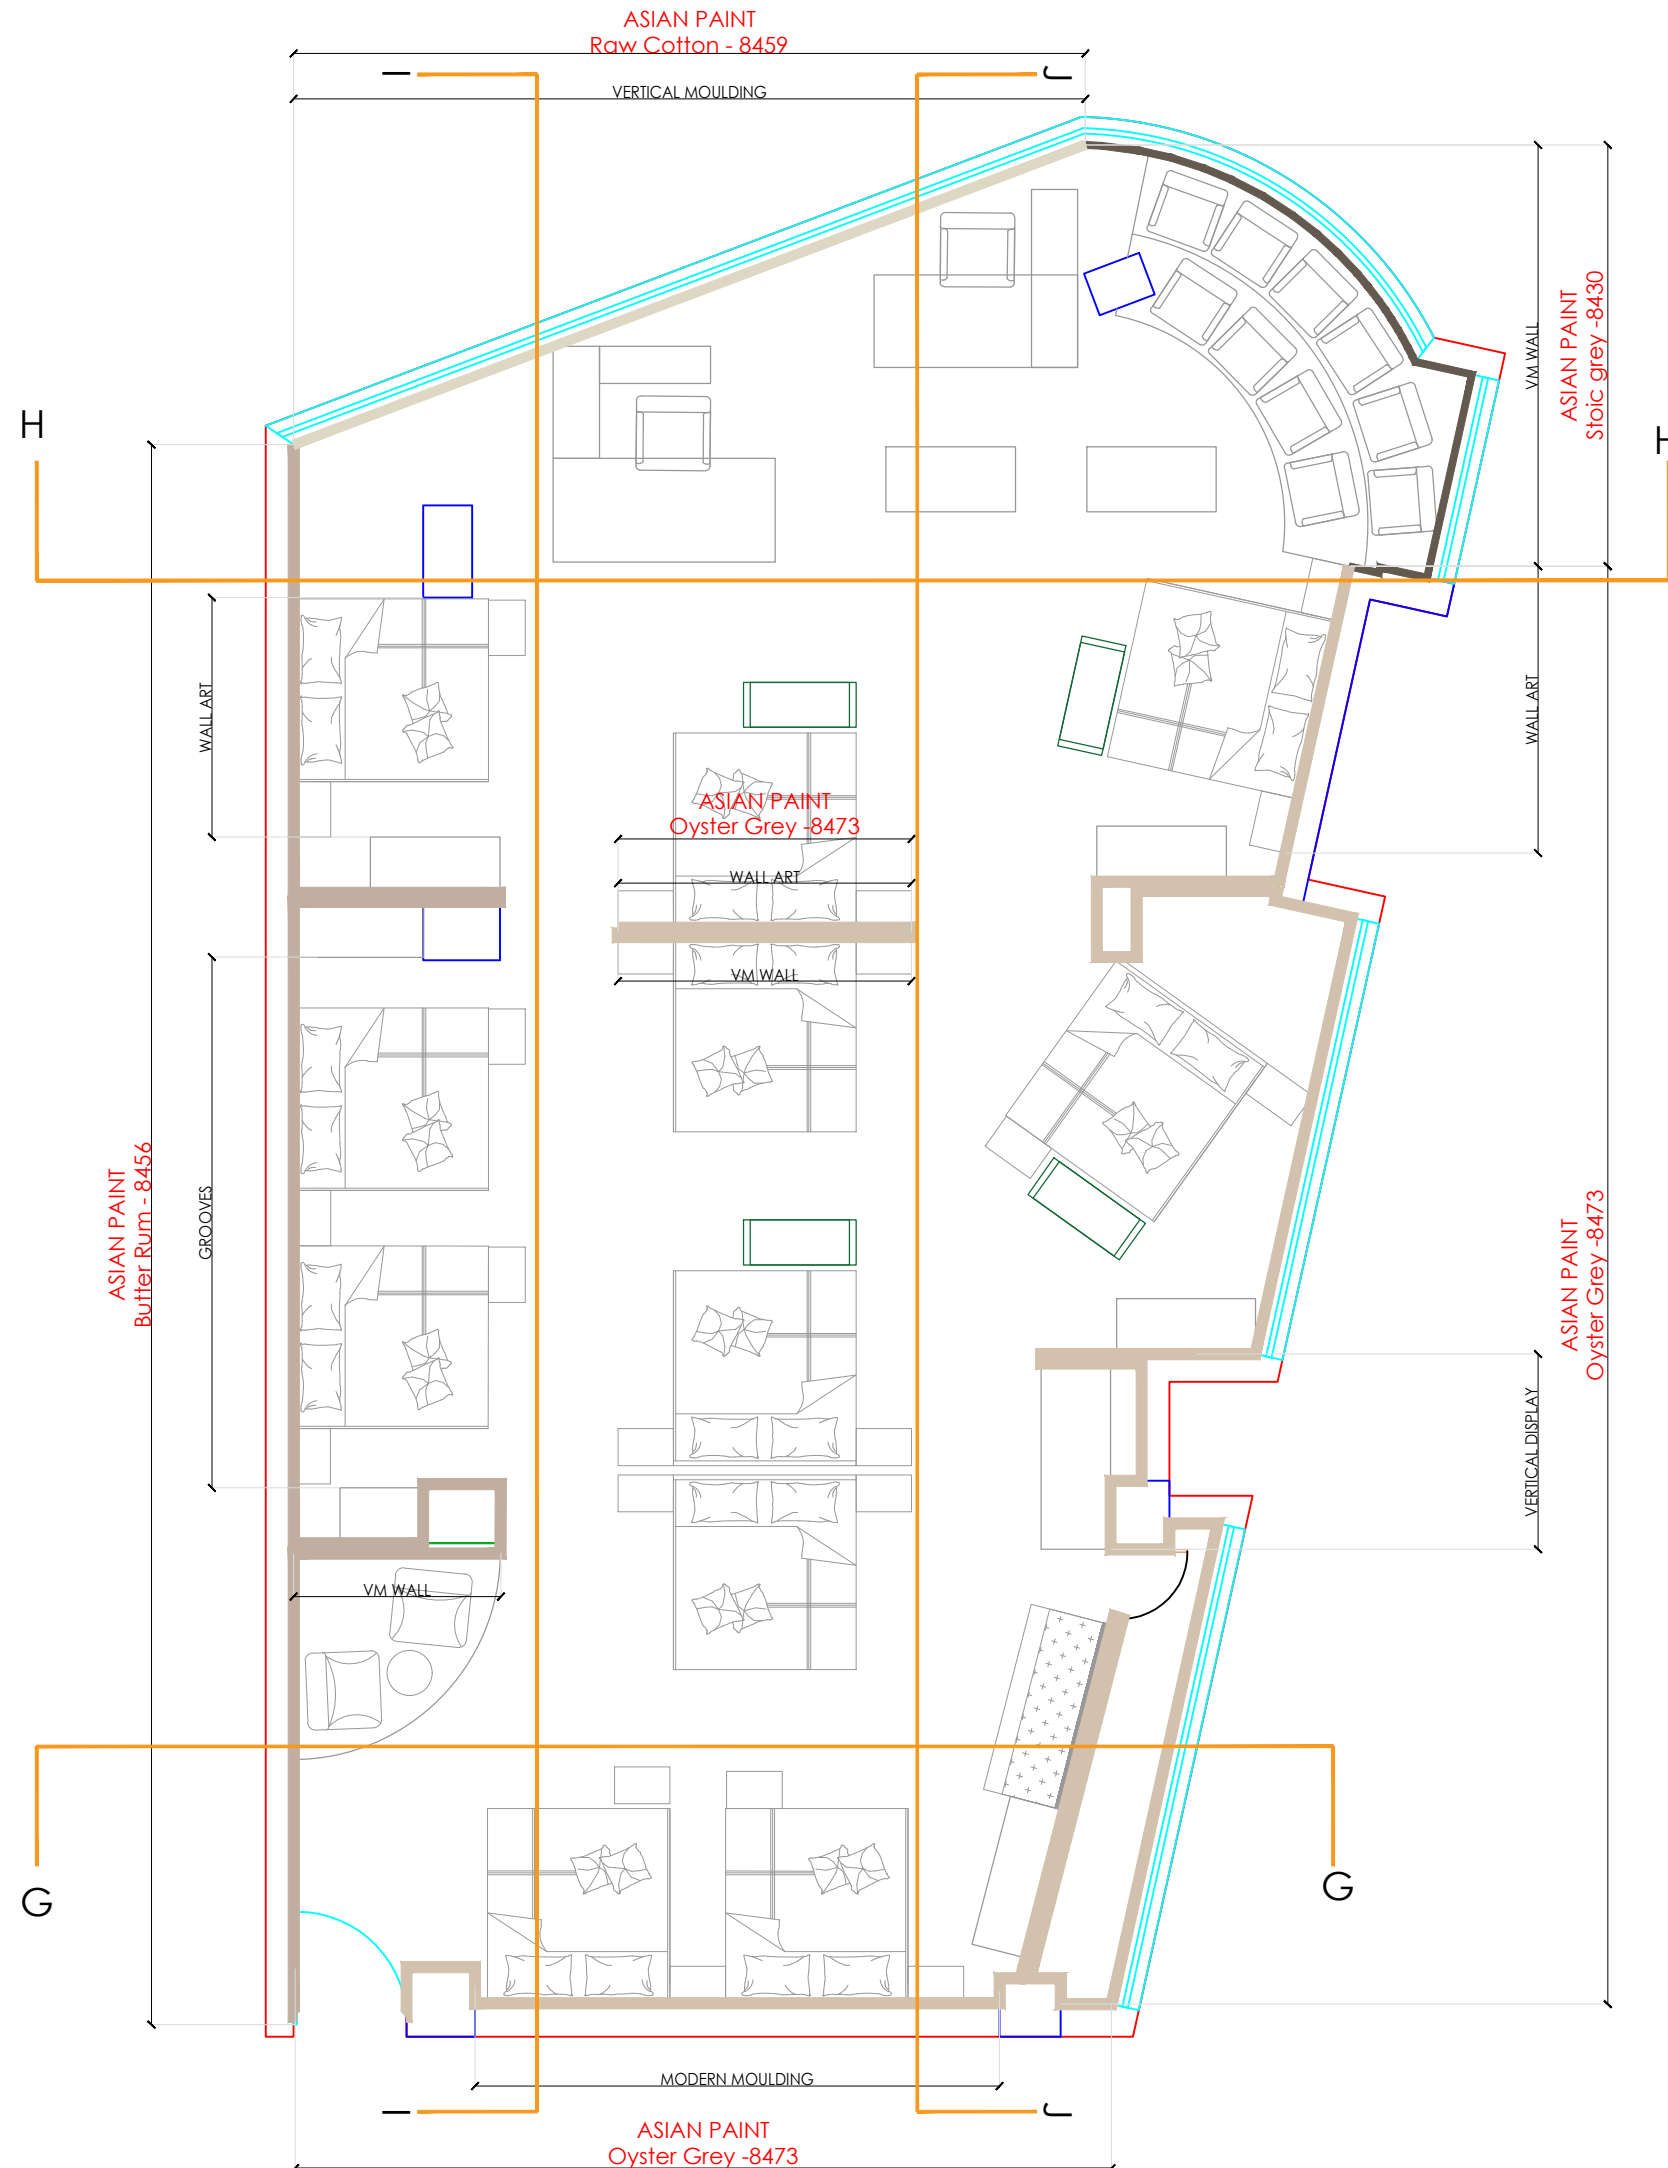

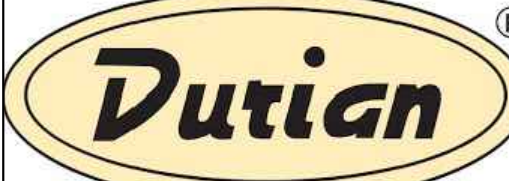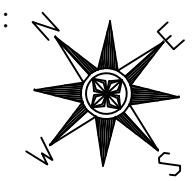
DESCRIPTION :
Site Name : Guwahati
Layout : Second Floor Bed Section VM Hanging Lights Layout
Area: 7175.83 sft
NOTE : Beds - 11nos. Office table - 02nos
DIRECTION : 
FORMAT : A3
DRAWN BY : Jigar Panchal
DATE: 19-12-2023
DATE OF EDIT:




DESCRIPTION :

Site Name :
Guwahati


Layout : Elevation A, B
& C

Area:
7175.83 sft


NOTE :
Sofa Sets - 14nos.
Dining Set - 02nos.

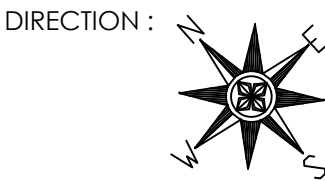


FORMAT : A3
DRAWN BY : Jigar Panchal
DATE: 19-12-2023
DATE OF EDIT:

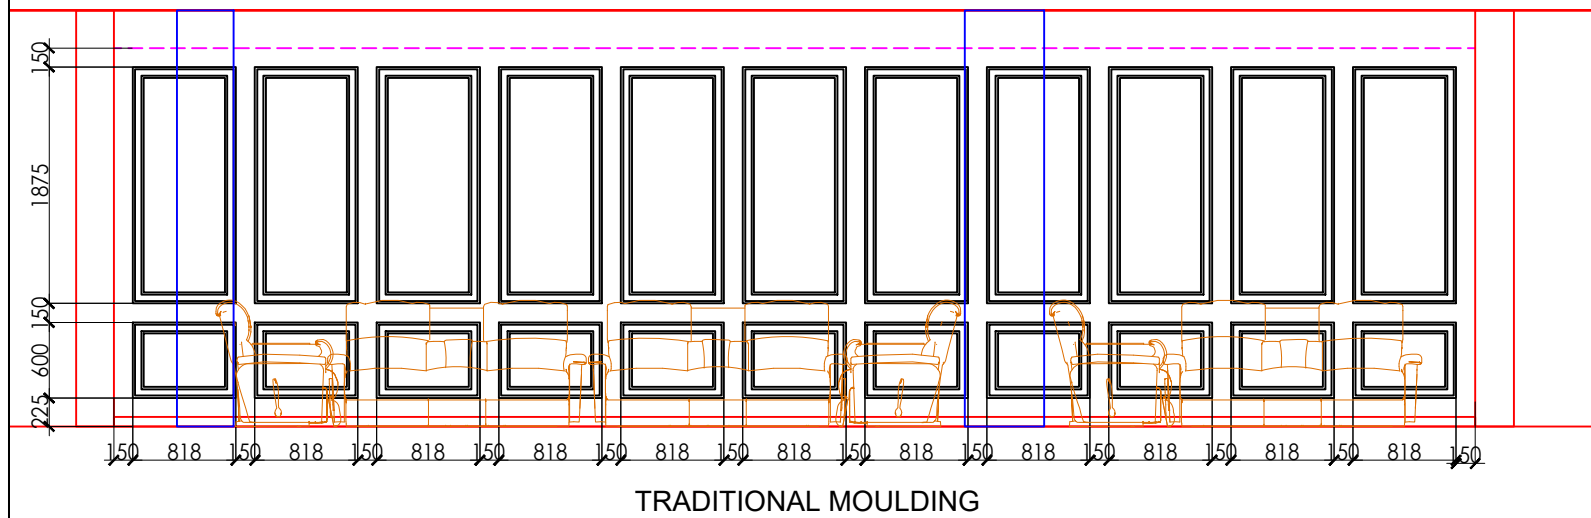

ELEVATION - A

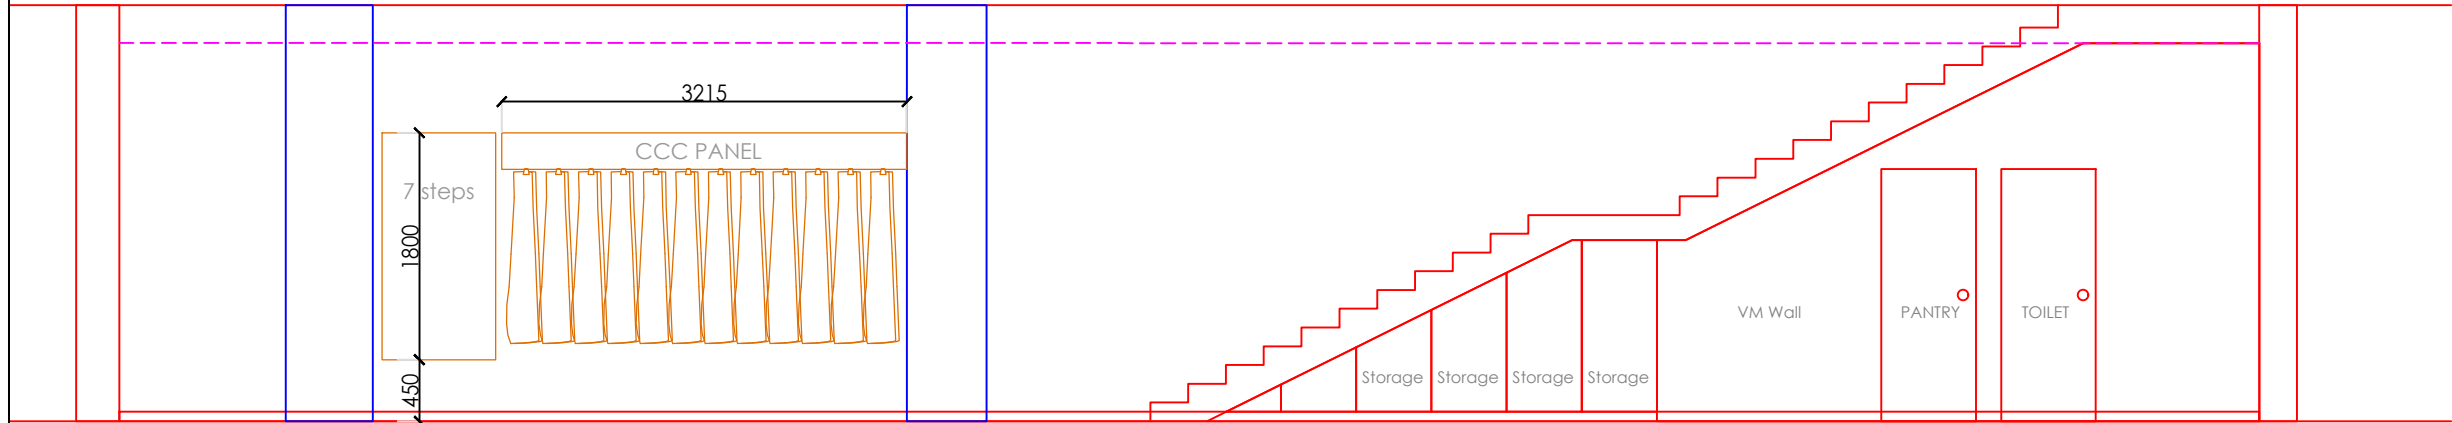


ELEVATION - B

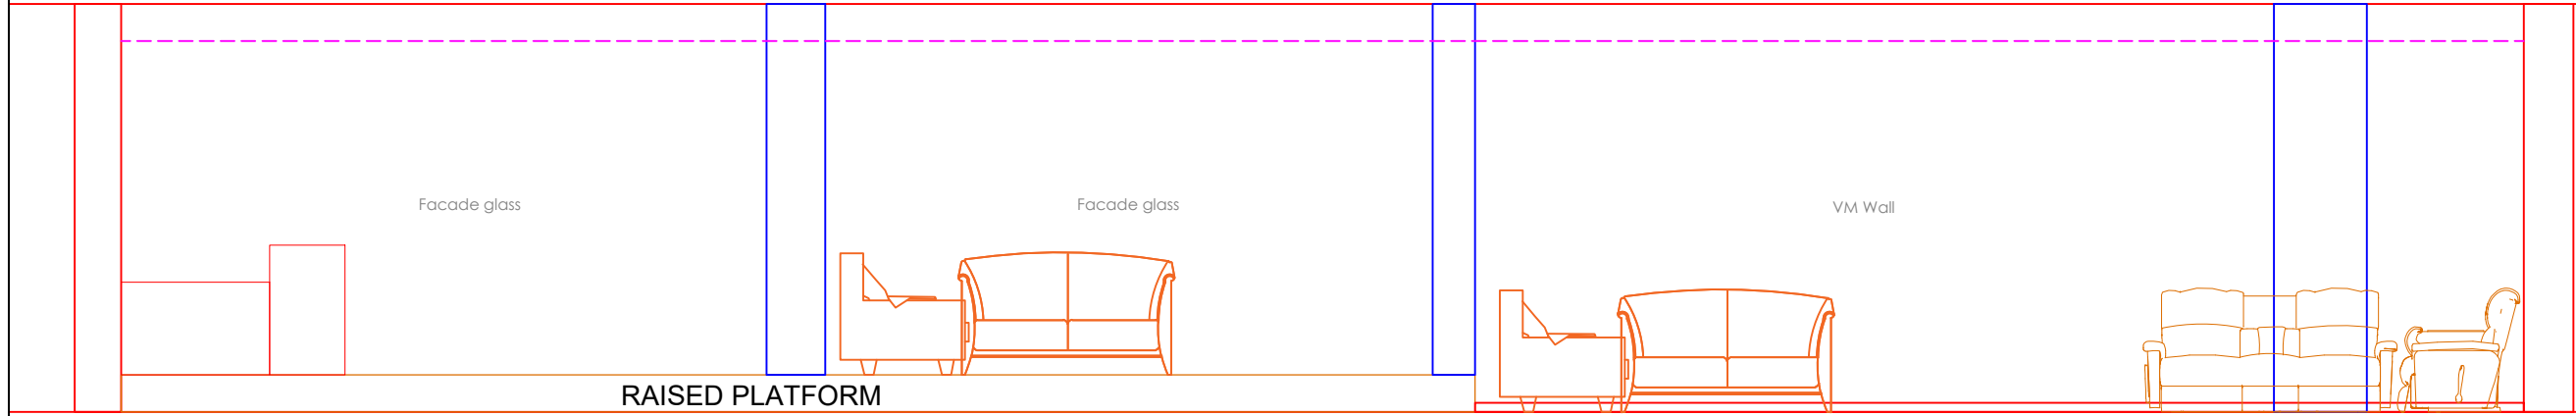

ELEVATION - C




DESCRIPTION :

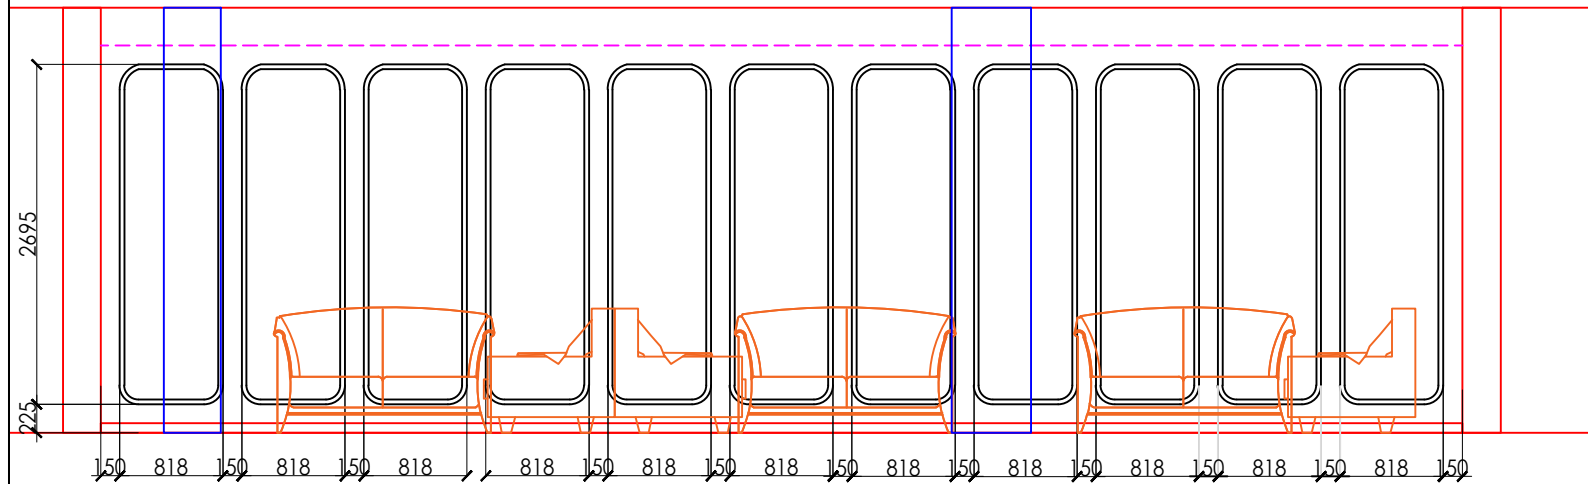


MODERN MOULDING

ELEVATION - D

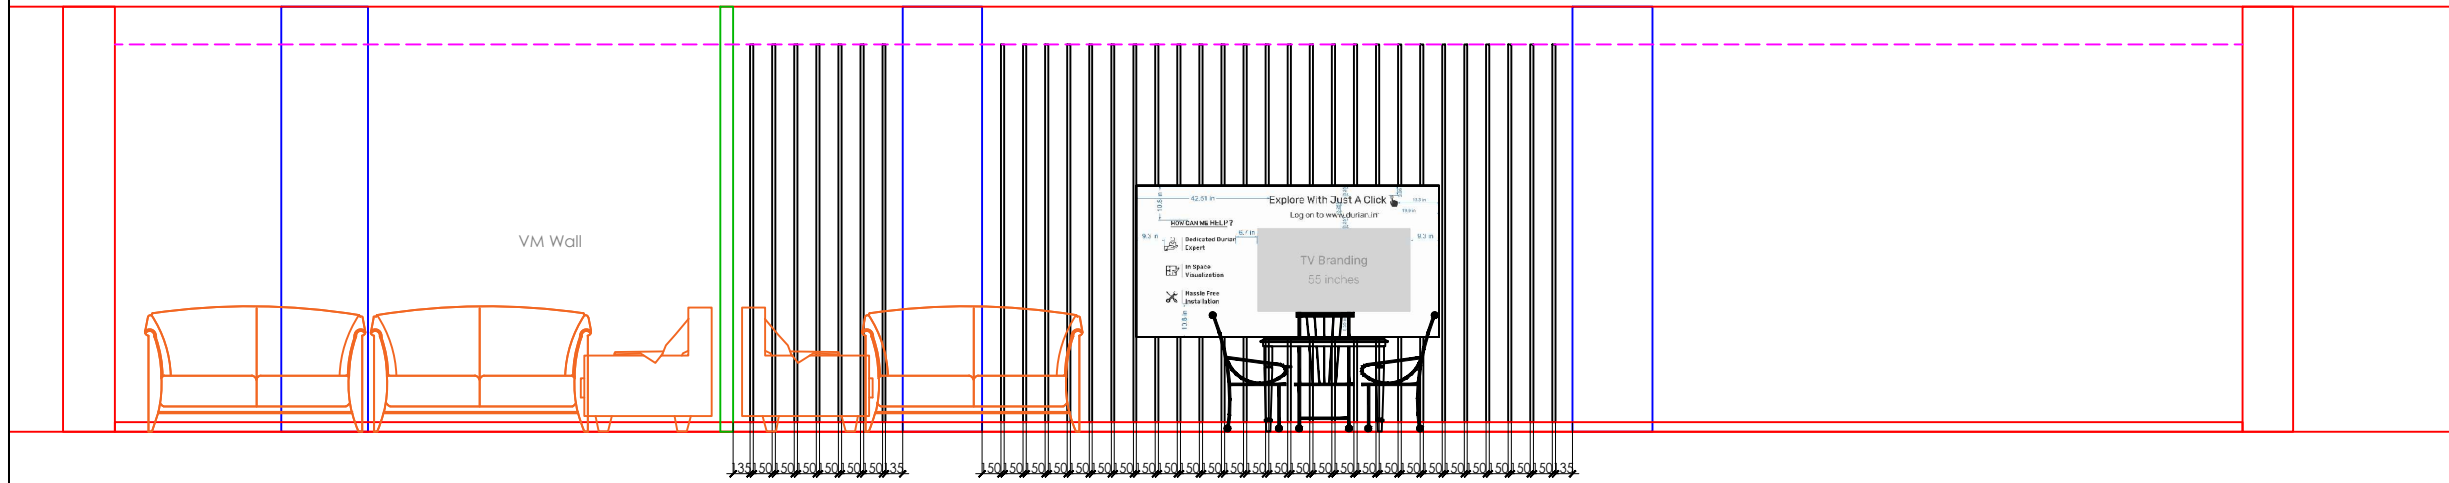

VERTICAL MOULDING

ELEVATION - E

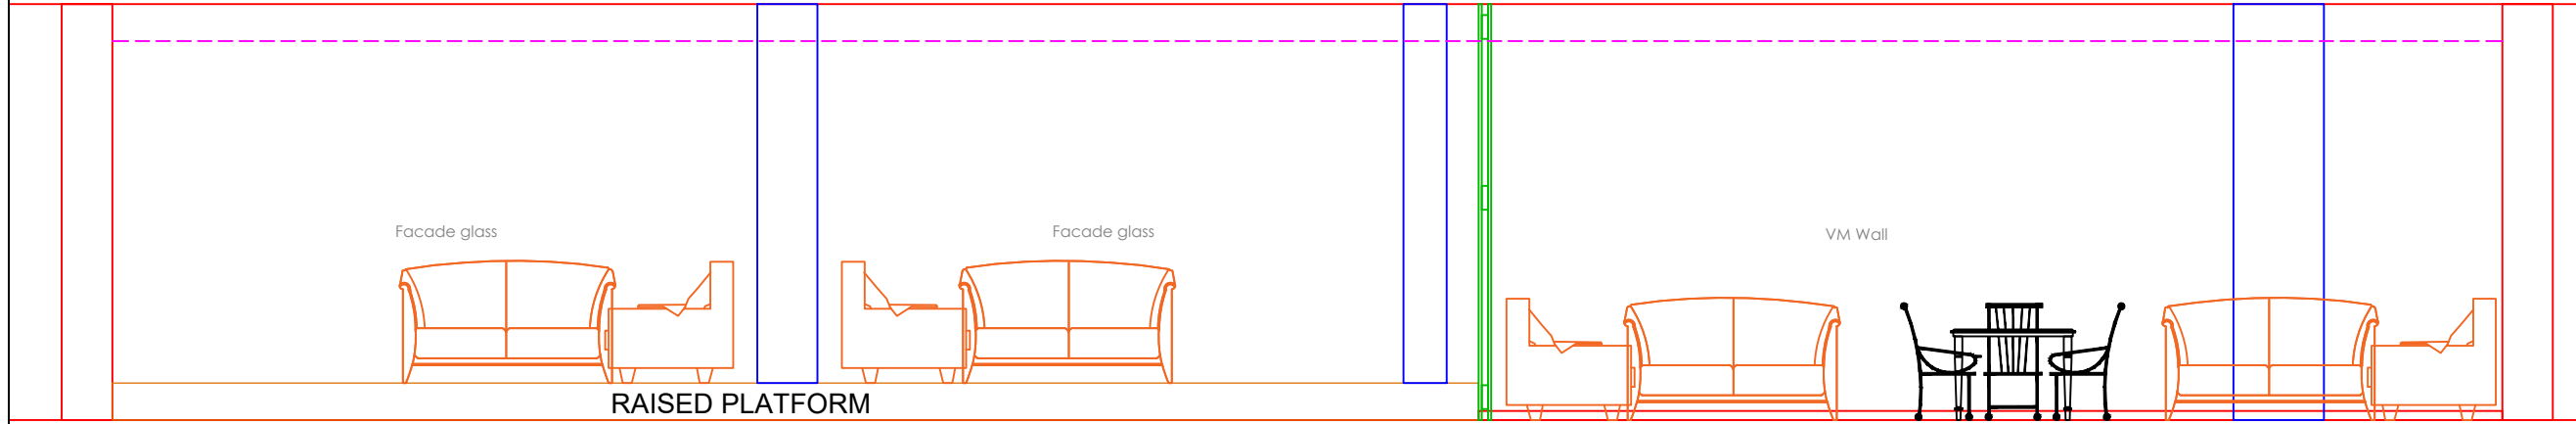

RAISED PLATFORM

ELEVATION - F

Site Name :
Guwahati

Layout : Elevation A, B
& C

Area:
7175.83 sft

NOTE :
Sofa Sets - 14nos.
Dining Set - 02nos.



FORMAT : A3
DRAWN BY : Jigar Panchal
DATE: 19-12-2023
DATE OF EDIT:



DESCRIPTION :

Site Name :
Guwahati

Layout : Elevation G &
H

Area:
7175.83 sft

NOTE :
Sofa Sets - 14nos.
Dining Set - 02nos.

DIRECTION :




FORMAT : A3

DRAWN BY : Jigar Panchal


DATE: 19-12-2023

DATE OF EDIT:

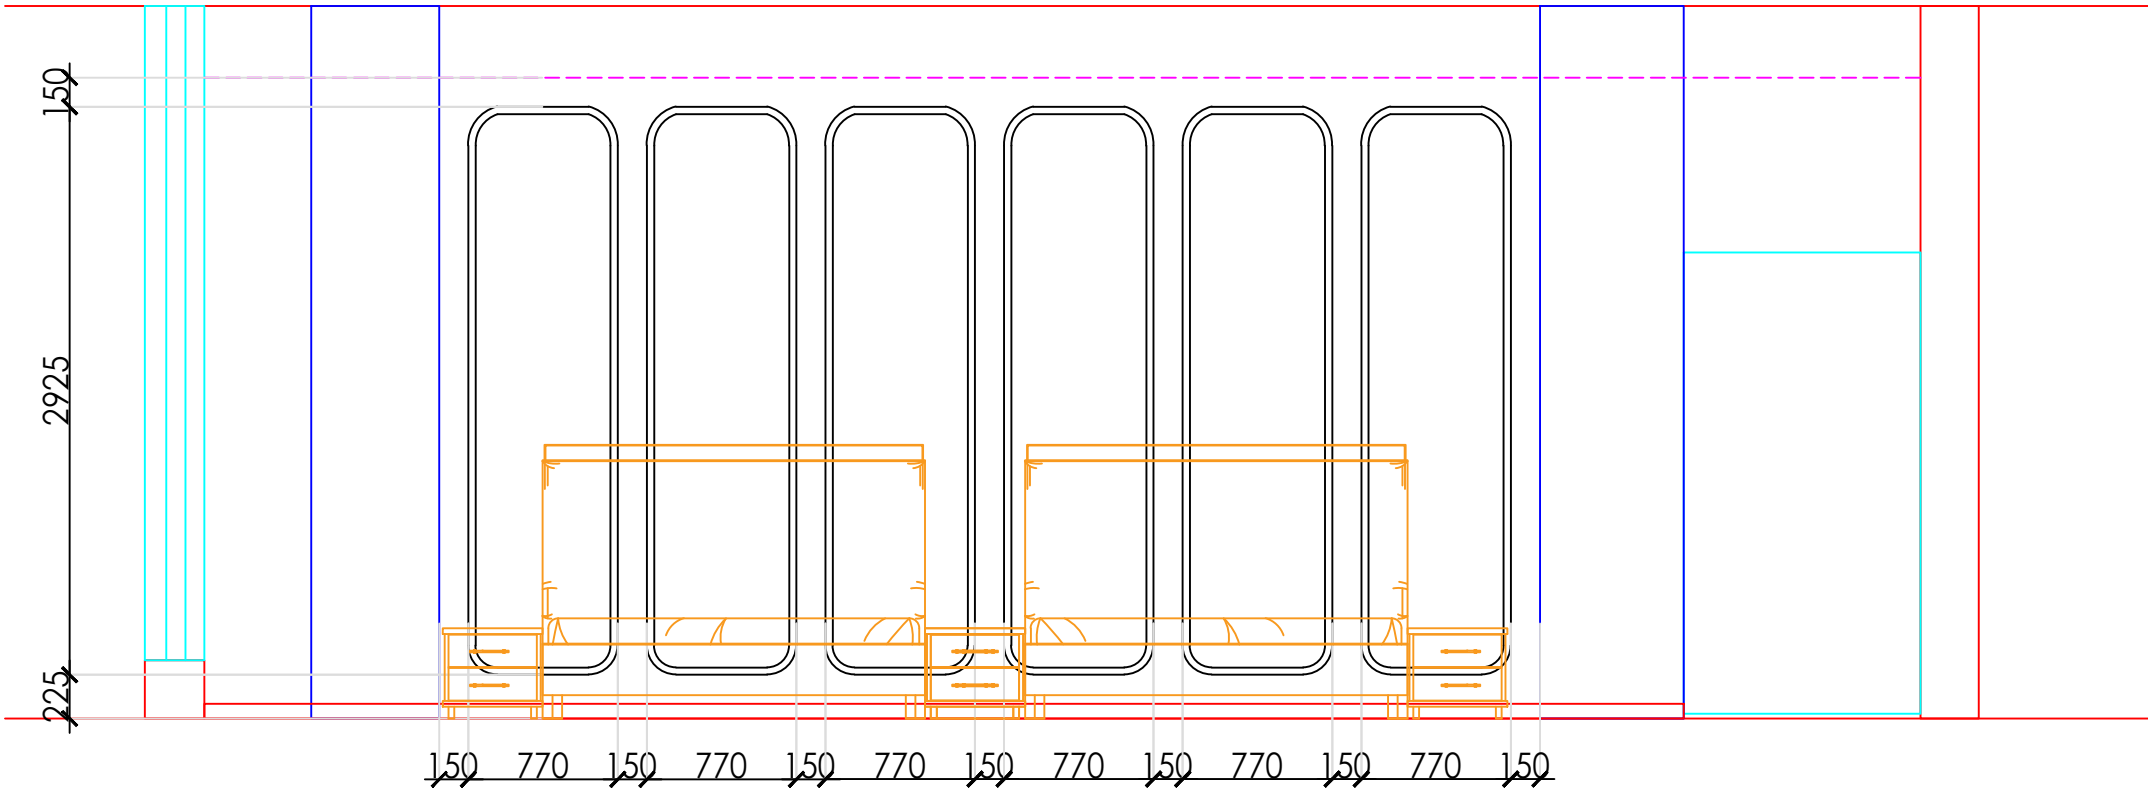

MODERN MOULDING

ELEVATION - G

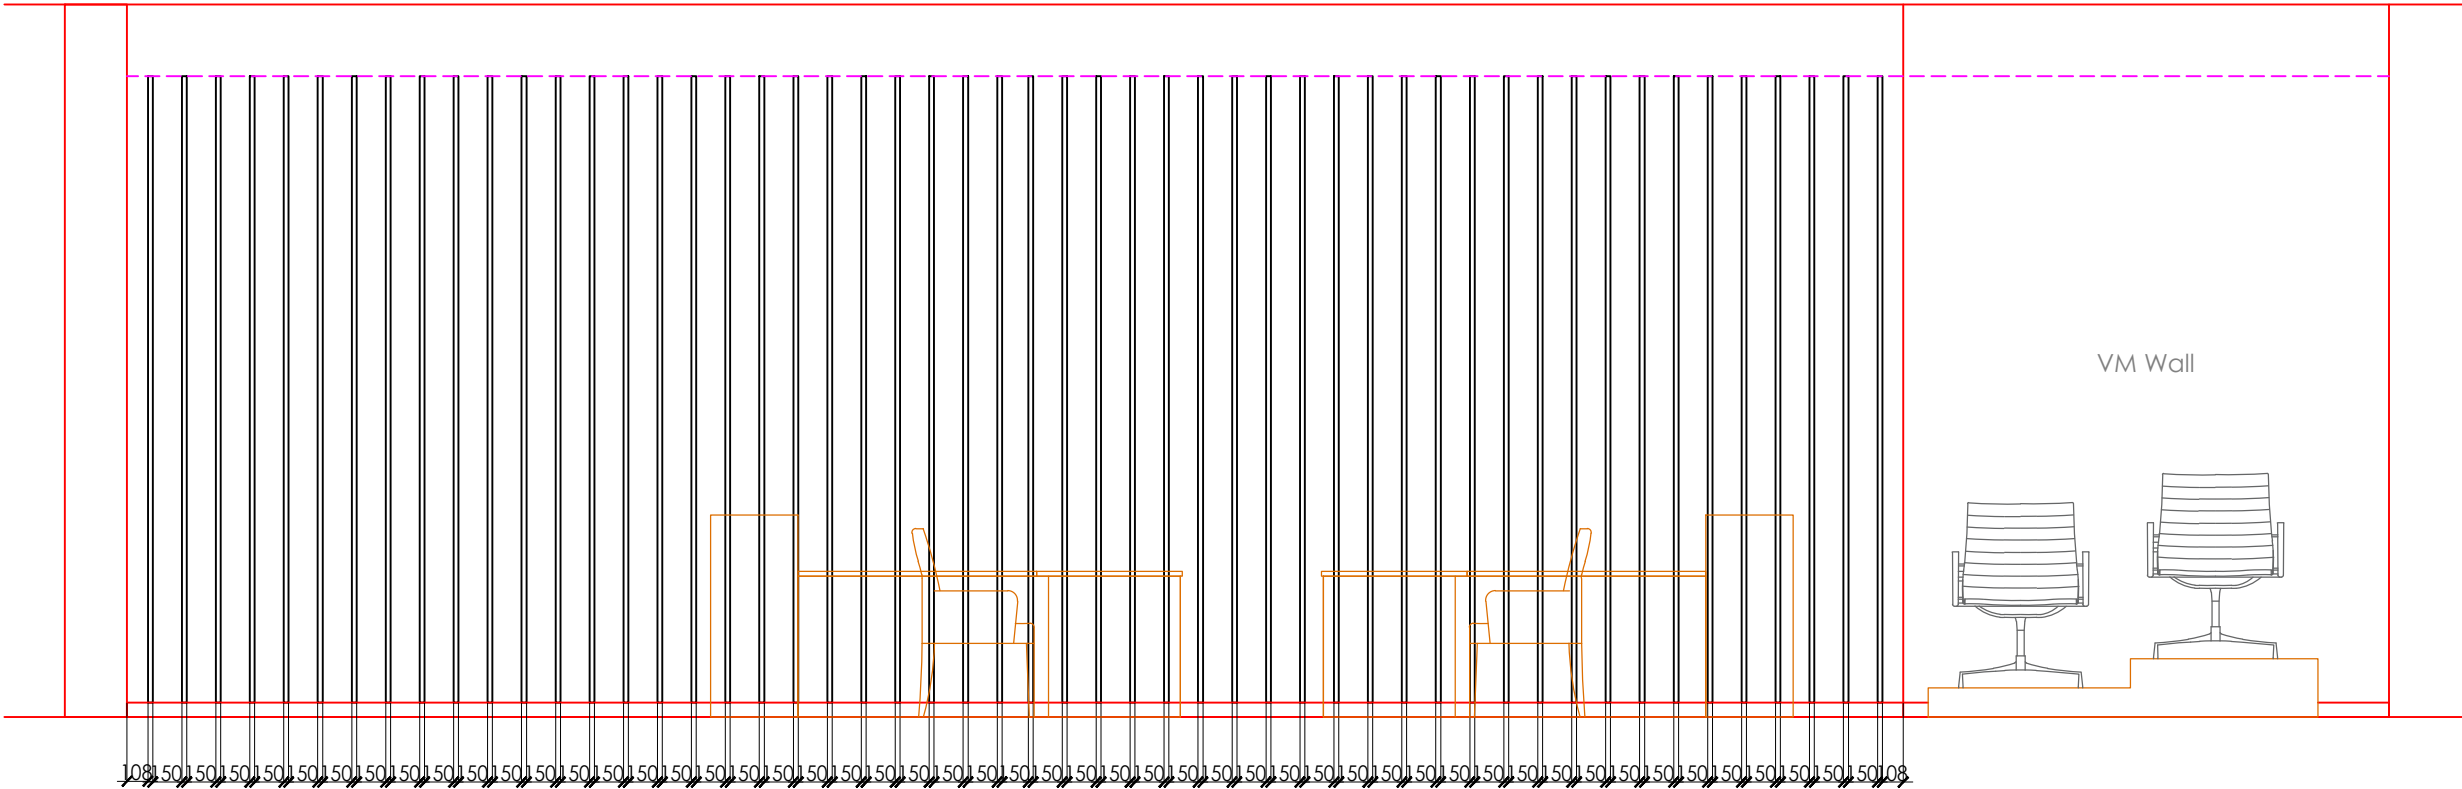


VERTICAL MOULDING

CHAIR LEDGE


ELEVATION - H



DESCRIPTION :

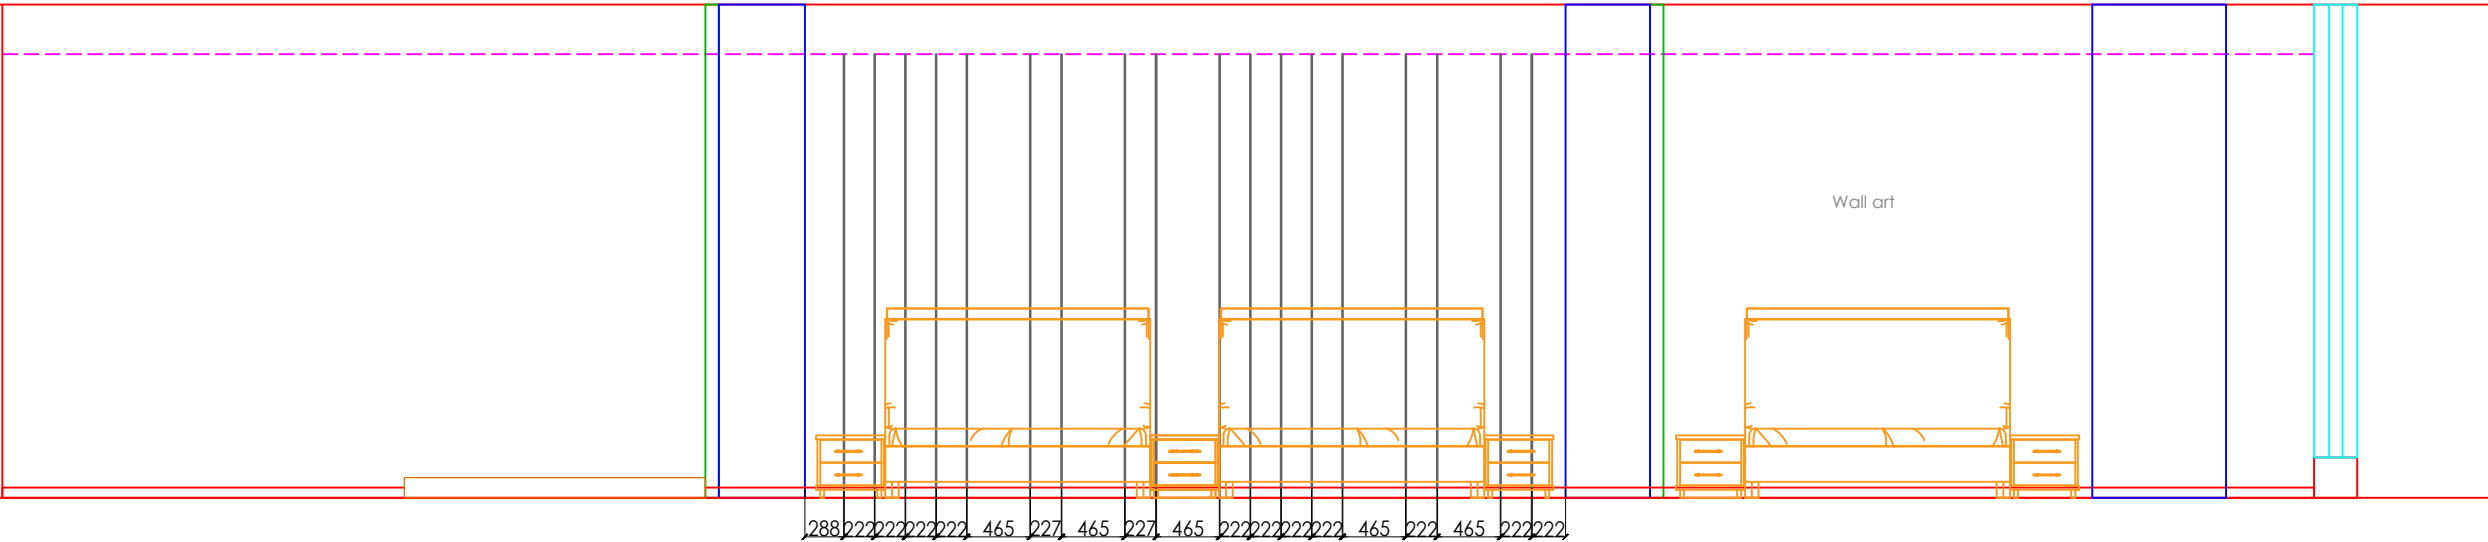

ELEVATION - I

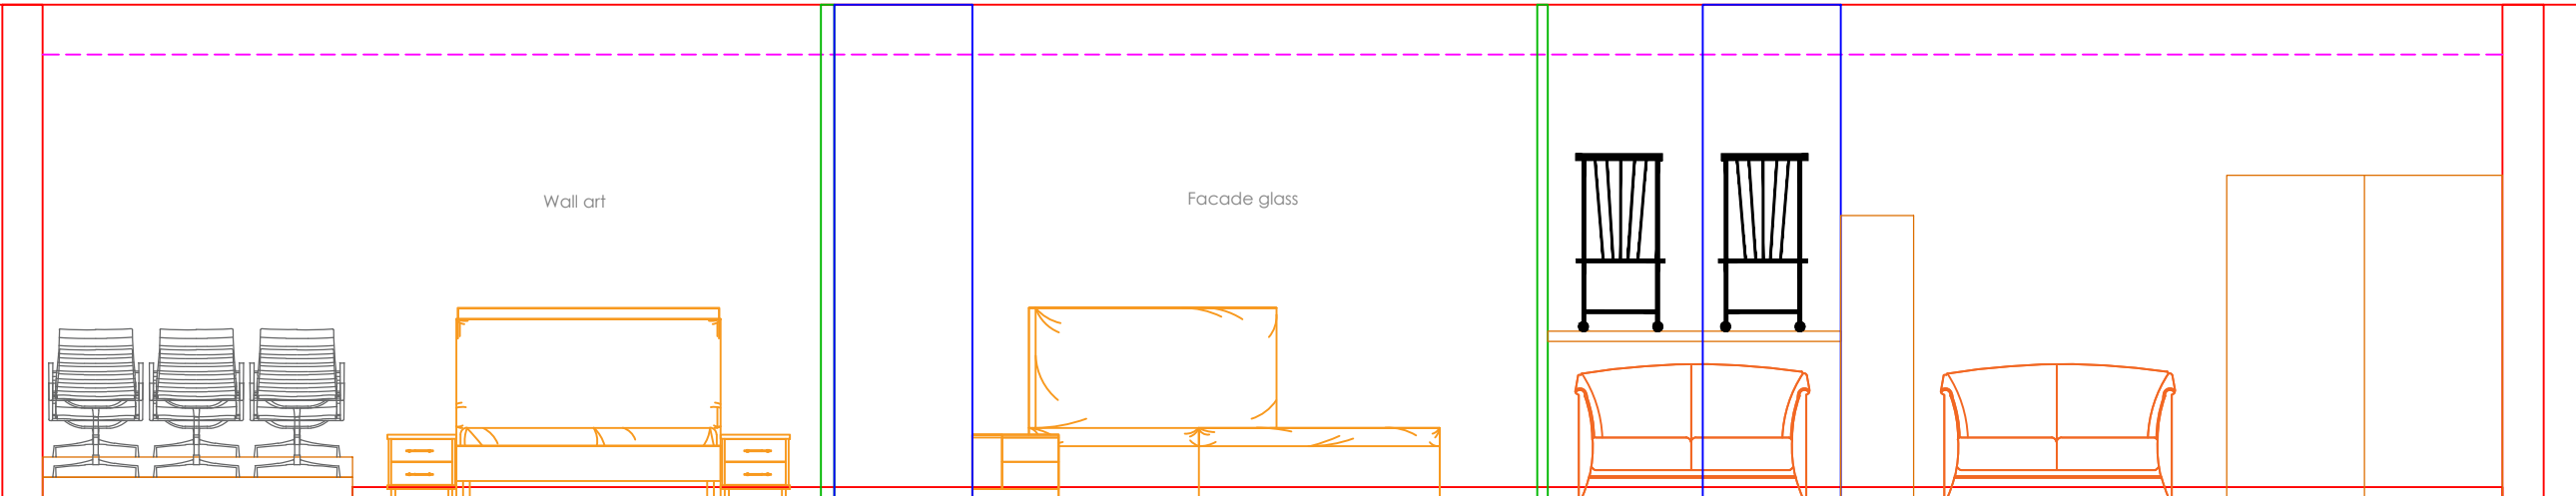


ELEVATION - J

Site Name :
Guwahati

Layout : Elevation I & J

Area:
7175.83 sft

NOTE :
Sofa Sets - 14nos.
Dining Set - 02nos.

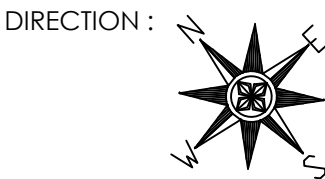

FORMAT : A3
DRAWN BY : Jigar Panchal
DATE: 19-12-2023
DATE OF EDIT:




Layout : Pine partition details

NOTE :
Sofa Sets - 14nos.
Dining Set - 02nos.


FORMAT : A3

DATE: 19-12-2023

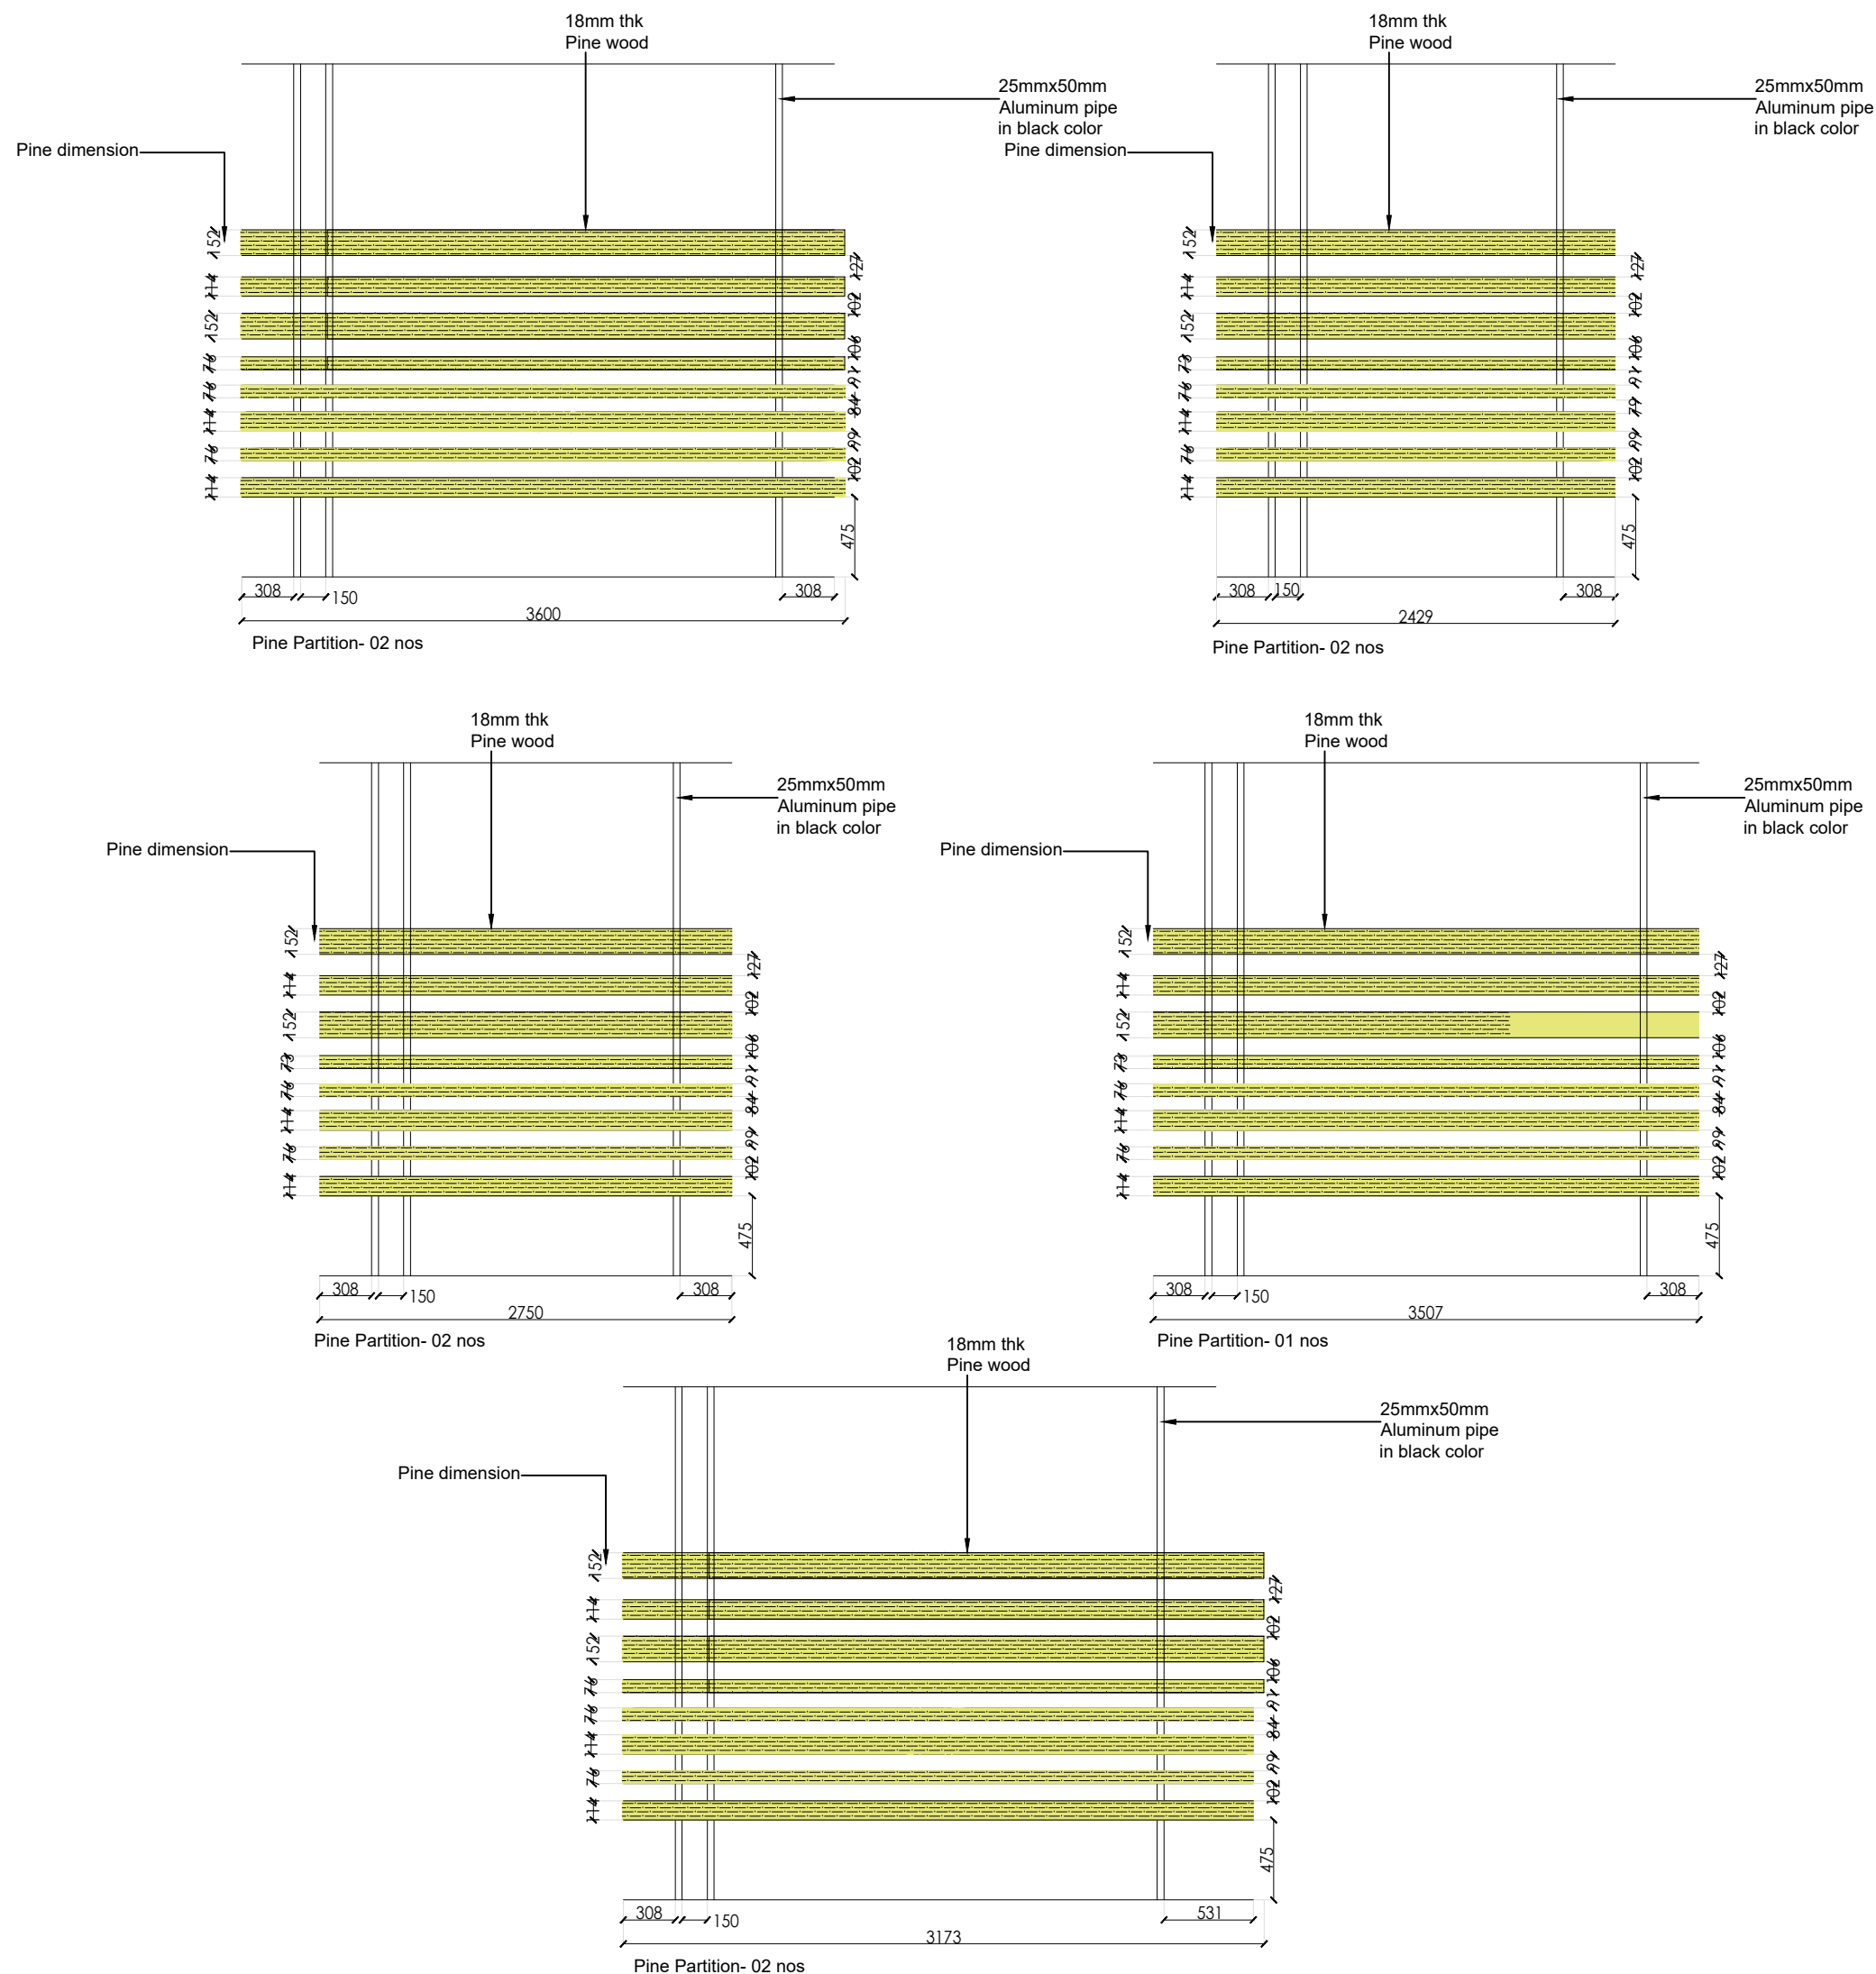



DESCRIPTION :

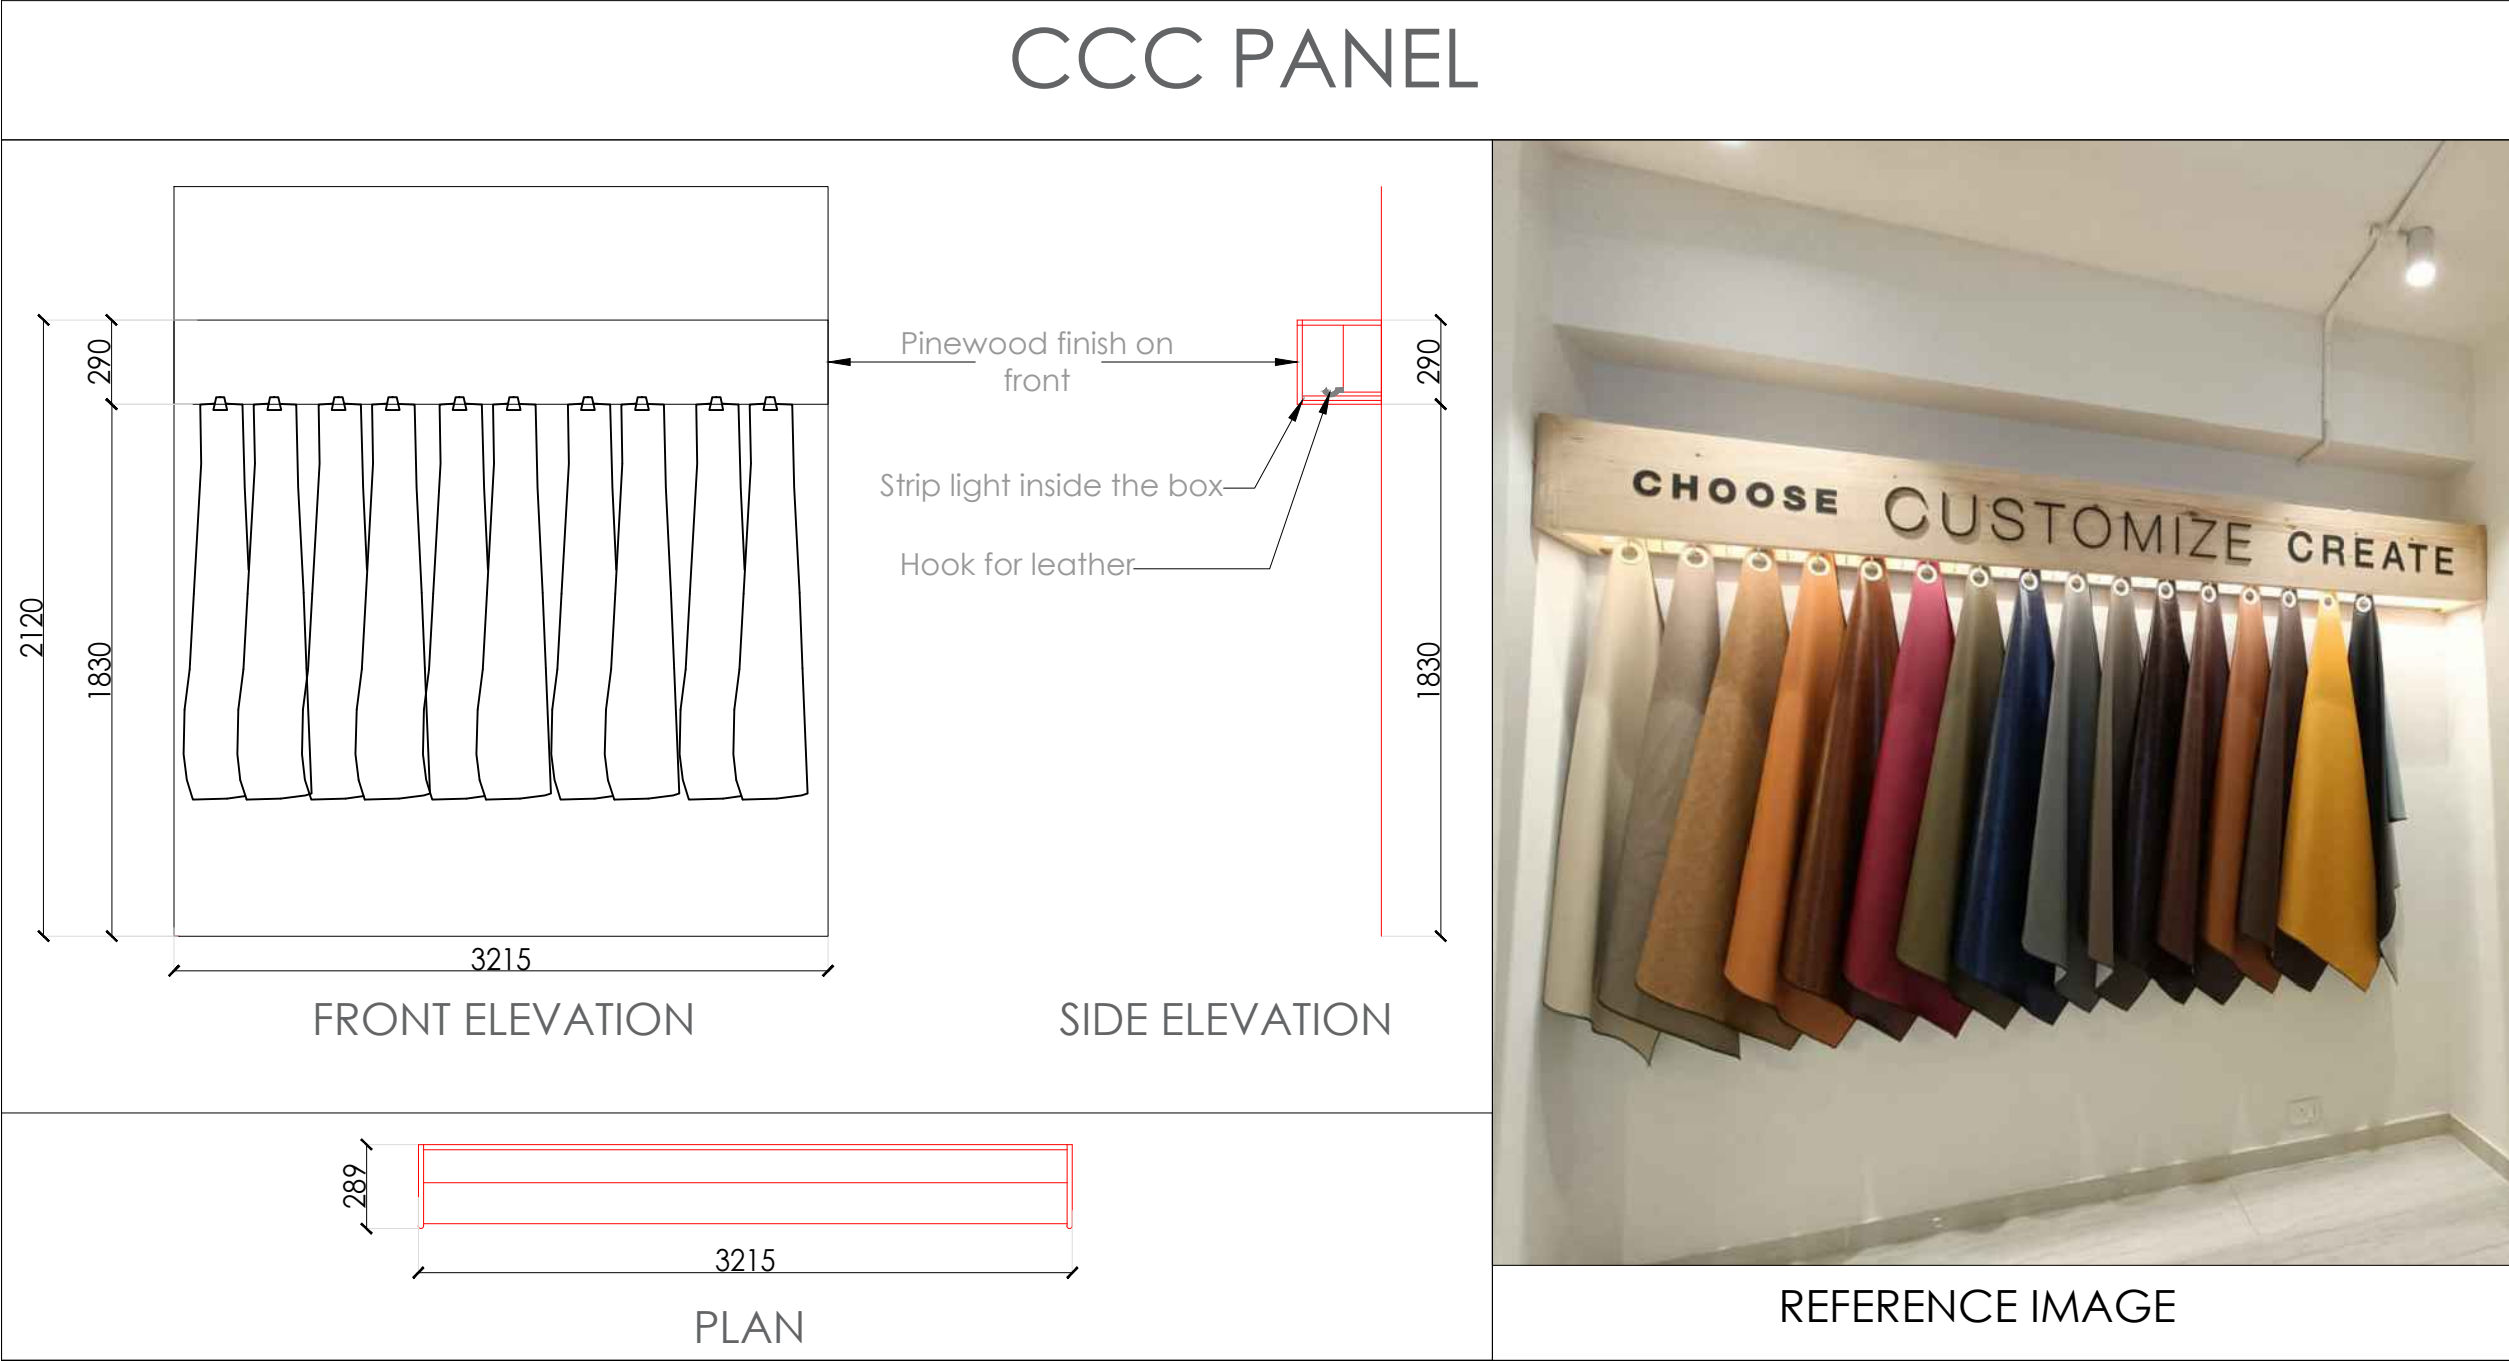


Site Name :
Guwahati

Layout : CCC Panel
details

Area:
7175.83 sft

NOTE :
Sofa Sets - 14nos.
Dining Set - 02nos.

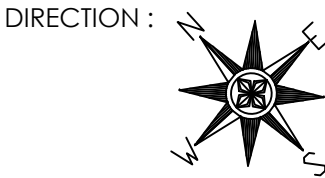

FORMAT : A3
DRAWN BY : Jigar Panchal
DATE: 19-12-2023
DATE OF EDIT:

CHAIR LEDGE STEP UP



DESCRIPTION :

Site Name :
Guwahati

Layout : Chair ledge
details

Area:
7175.83 sft

NOTE :
Sofa Sets - 14nos.
Dining Set - 02nos.

DIRECTION :




FORMAT : A3


DRAWN BY : Jigar Panchal

DATE: 19-12-2023


DATE OF EDIT:

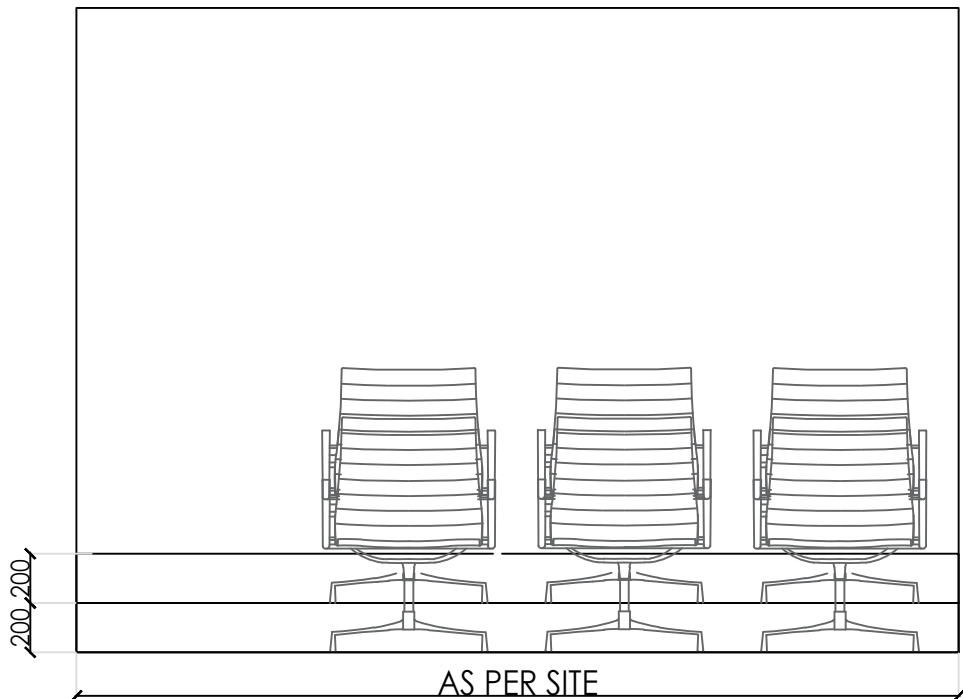

FRONT ELEVATION

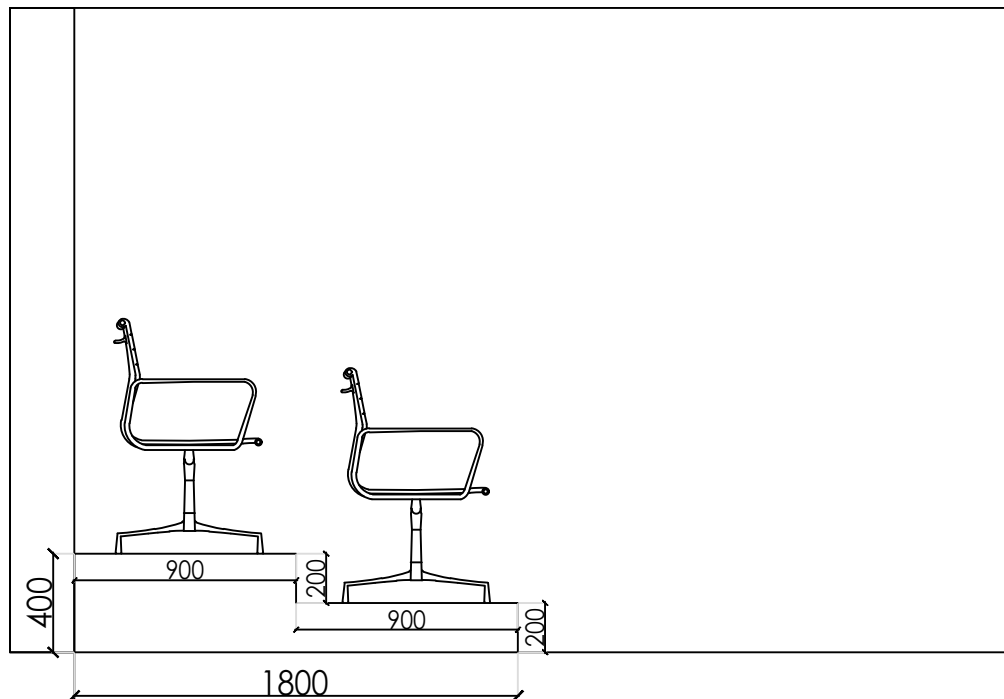

SIDE ELEVATION

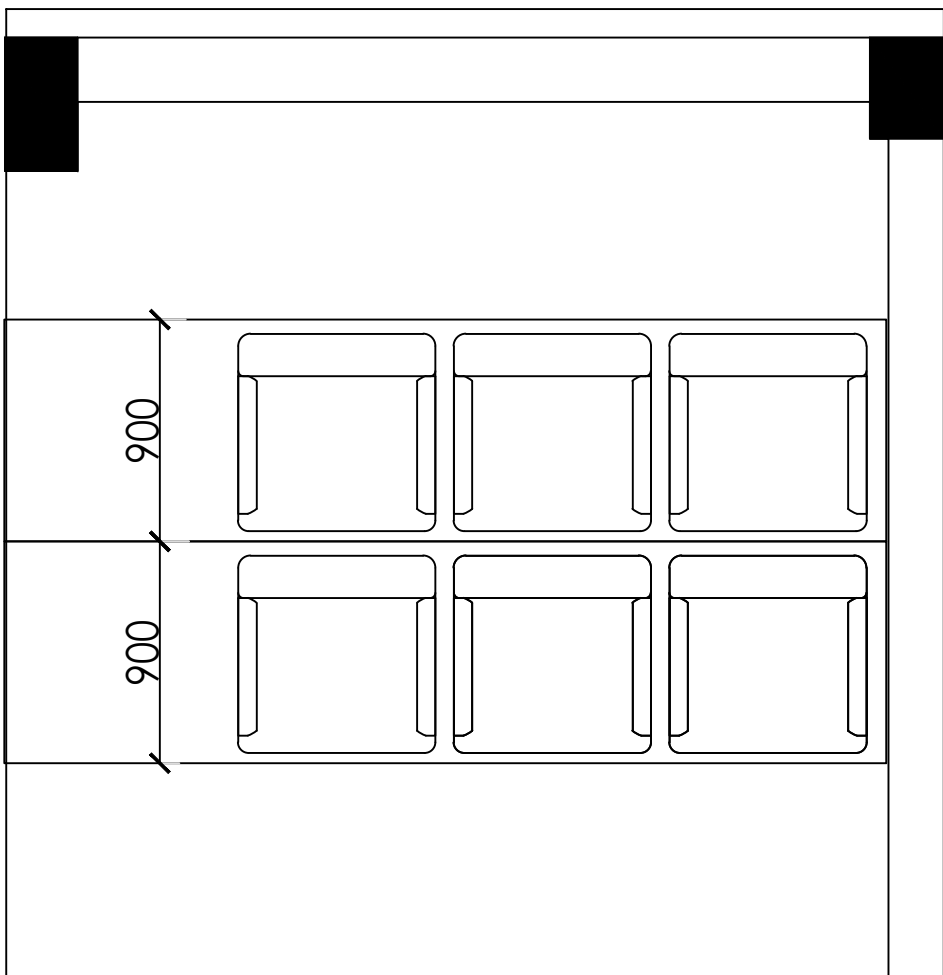

PLAN



REFERENCE IMAGE