


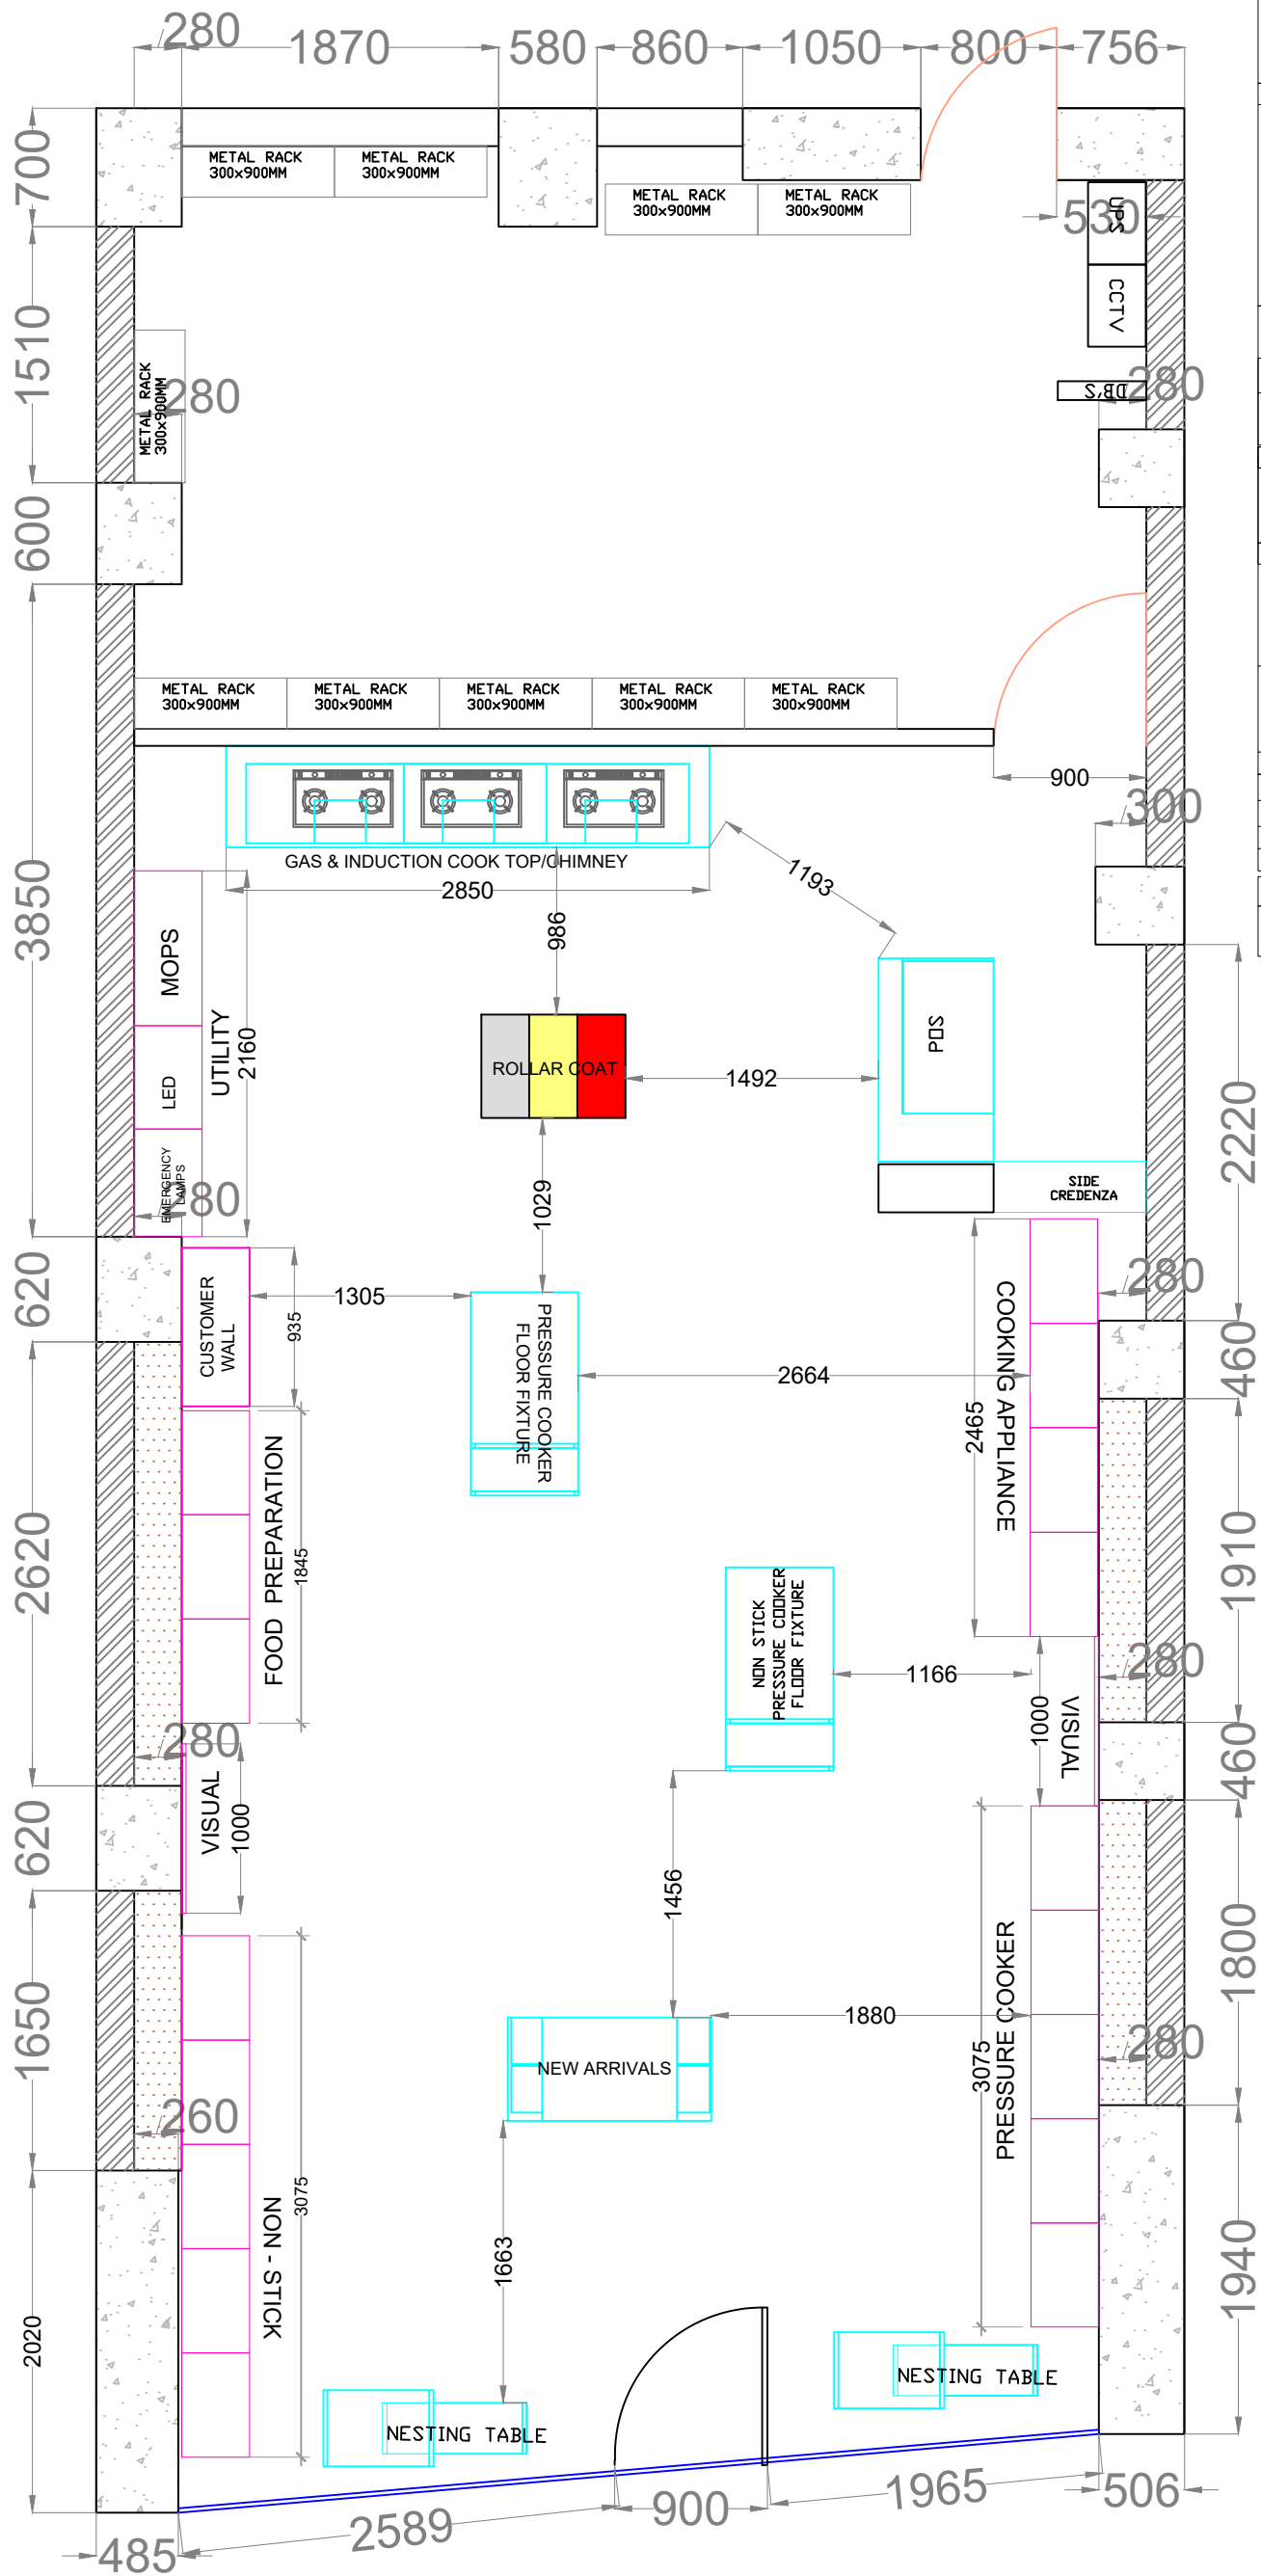

- GENERAL NOTES :**
1. ALL DIMENSIONS ARE MILLIMETER, UNLESS MENTIONED OTHERWISE.
 2. ALL DIMENSIONS TO BE CHECKED AND VERIFIED ON SITE BY CONTRACTORS PRIOR TO COMMENCEMENT OF WORK.
 3. ANY DISCREPANCIES TO BE CLARIFIED IMMEDIATELY, AND CHANGES REQUIRED SHALL BE CONFIRMED FROM THE ARCHITECT.
 4. WRITTEN DIMENSIONS SHOULD BE FOLLOWED.
 5. THIS DRAWING SHALL BE READ IN CONJUNCTION WITH OTHER PERTINENT.

PIGEON

PROJECT :

STORE NAME : ANAD NAGAR
STORE CODE :

DWG TITLE :

FURNITURE LAYOUT

NOTES:

AREA STATEMENT
RETAIL AREA : 632 SQFT
BOH : 218 SQFT
TOTAL AREA : 850 SQFT

TOTAL HIGHT : 3240 MM

CEILING TO FLOORING : 2950

FALSE TO BEAM BOTTOM - 290MM

DRAWN BY : POOJASHREE PS

CHECKED BY : Mr. PRASHANTH

APPROVED BY : Mr.MAYANK

SCALE: NTS

DATE: 17.01.2025

DWG NUMBER

P1

REVISION

R0



SCALE: NTS



- GENERAL NOTES :**
1. ALL DIMENSIONS ARE MILLIMETER, UNLESS MENTIONED OTHERWISE.
 2. ALL DIMENSIONS TO BE CHECKED AND VERIFIED ON SITE BY CONTRACTORS PRIOR TO COMMENCEMENT OF WORK.
 3. ANY DISCREPANCIES TO BE CLARIFIED IMMEDIATELY, AND CHANGES REQUIRED SHALL BE CONFIRMED FROM THE ARCHITECT.
 4. WRITTEN DIMENSIONS SHOULD BE FOLLOWED.
 5. THIS DRAWING SHALL BE READ IN CONJUNCTION WITH OTHER PERTINENT.

PIGEON

PROJECT :

STORE NAME : ANAD NAGAR

STORE CODE :

DWG TITLE :

POWER LAYOUT

NOTES:

AREA STATEMENT

RETAIL AREA	: 632 SQFT
BOH	: 218 SQFT
TOTAL AREA	: 850 SQFT

TOTAL HIGHT : 3240 MM

CEILING TO FLOORING : 2950

FALSE TO BEAM BOTTOM - 290MM

DRAWN BY : POOJASHREE PS

CHECKED BY : Mr. PRASHANTH

APPROVED BY : Mr.MAYANK

SCALE: NTS

DATE: 17.01.2025

DWG NUMBER

REVISION

P3

R0

1 plug points with switch and socket, etc
@ 1500 mm from the FFL

3 plug points with switch and socket, etc
@ 2100mm from the FFL



All UPS - 5 plug points with switch and socket, for laptop, printer, charger, music etc.@ 00mm from the FFL

1 plug points with switch and socket, etc
@ 1800mm from the FFL for tv

1 plug points with switch and socket, etc
@ 1200 mm from the FFL

A-1.1 POWER LAYOUT

SCALE: NTS

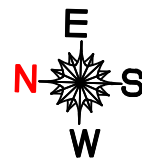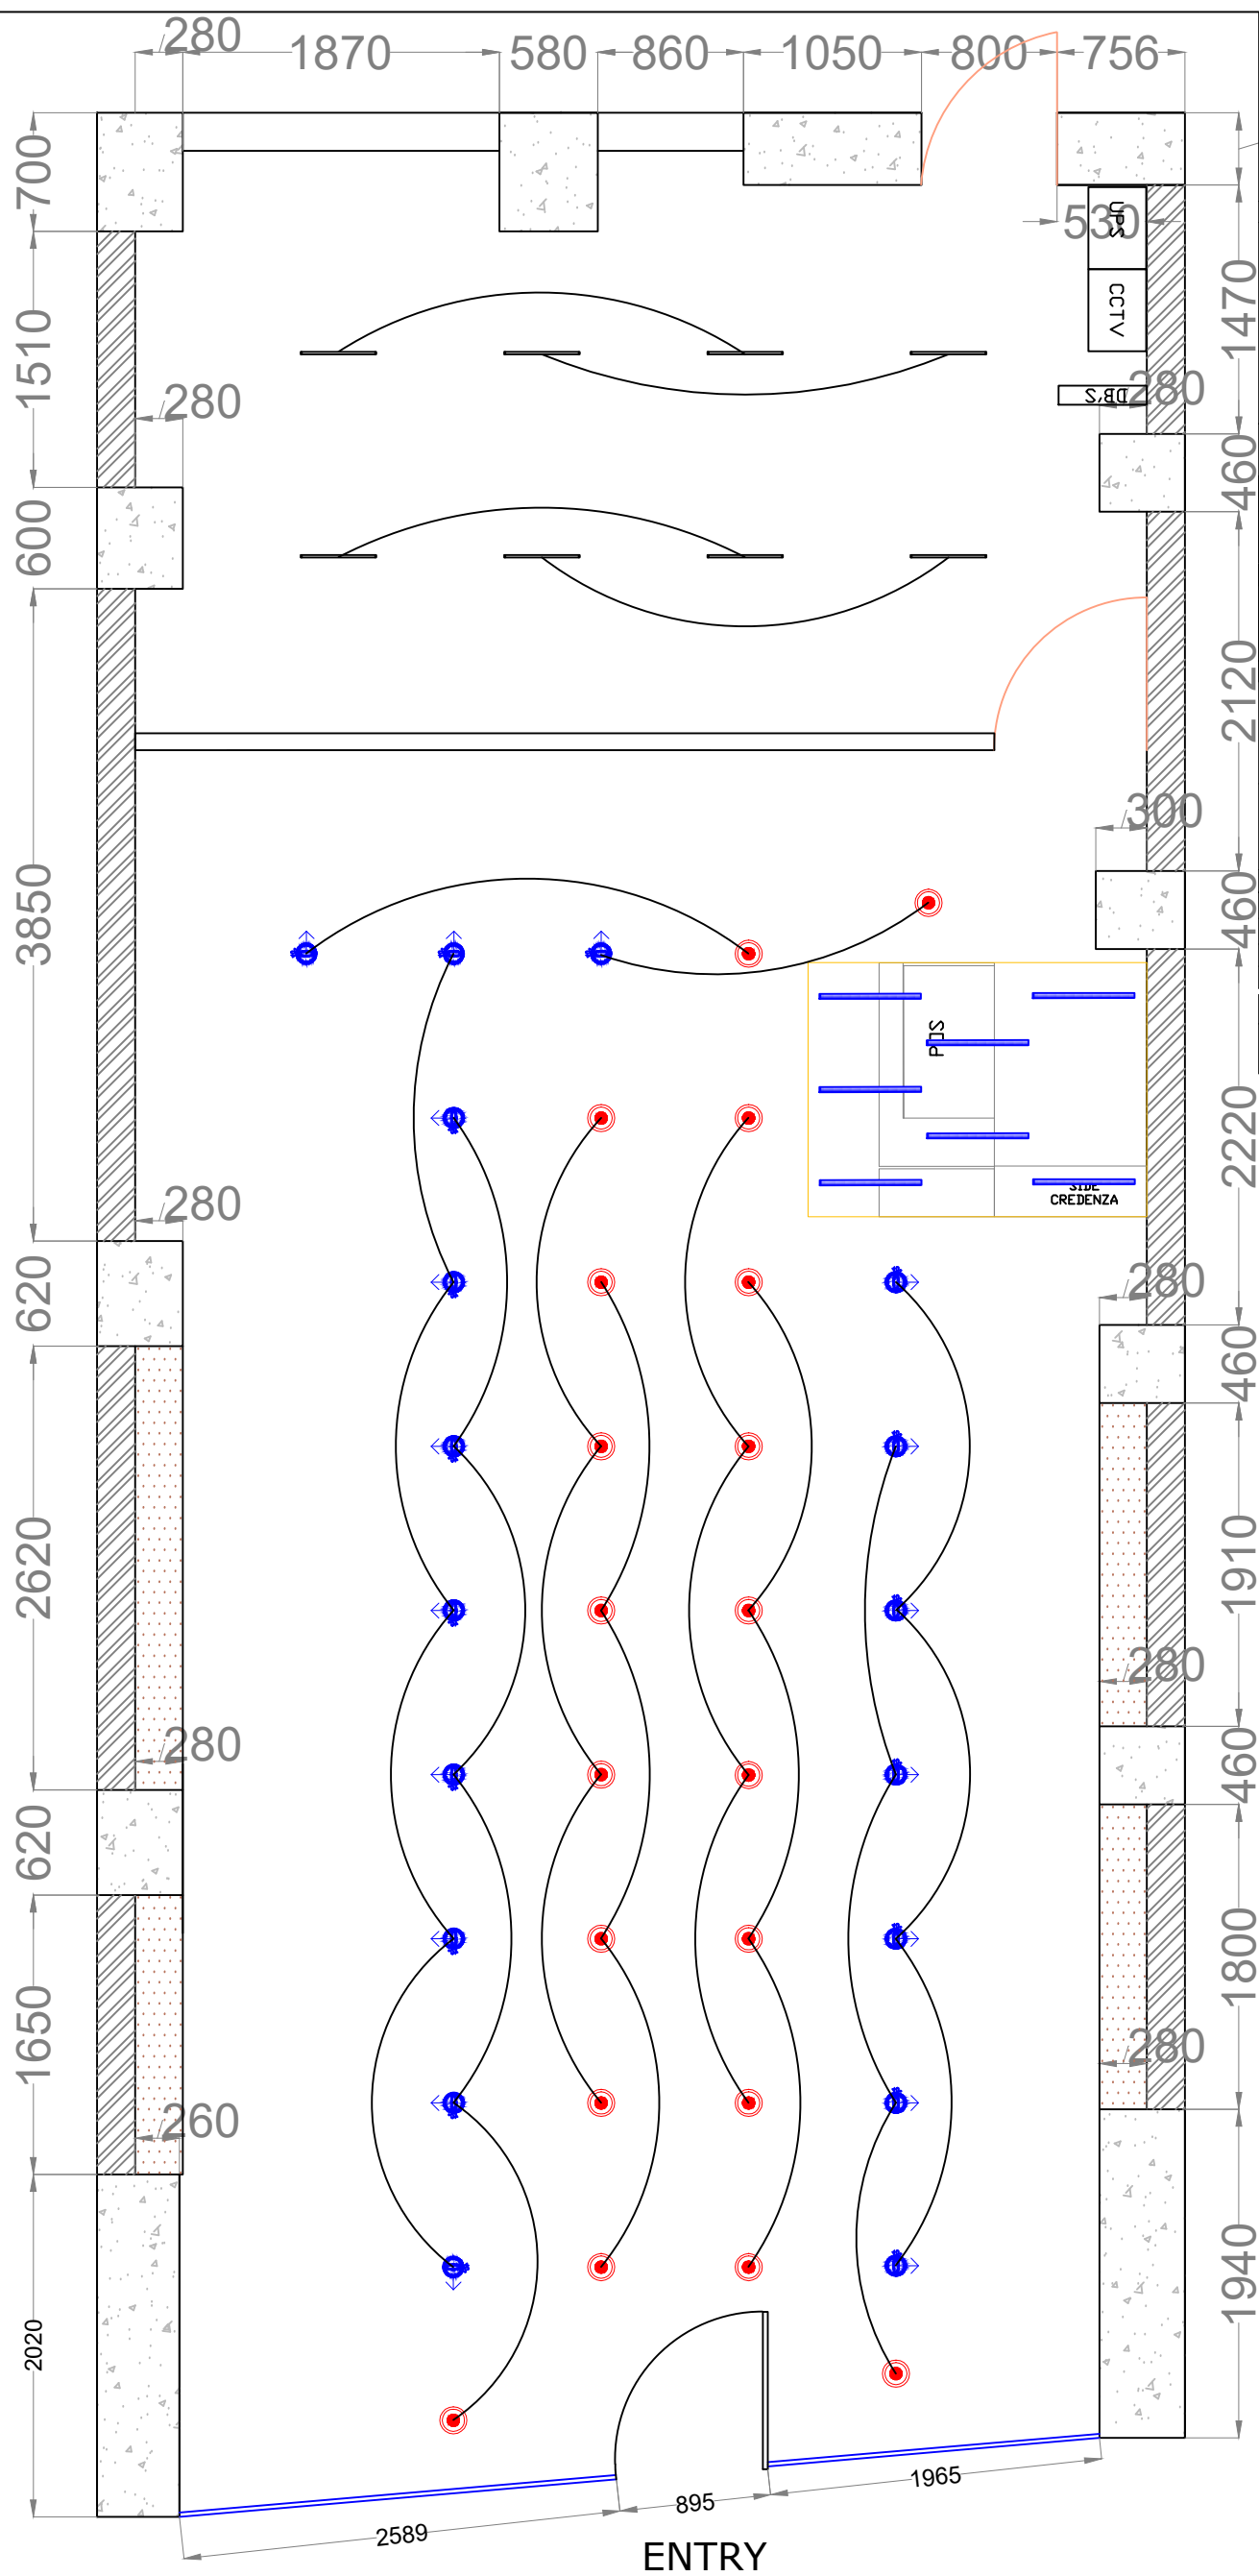

GENERAL NOTES :

1. ALL DIMENSIONS ARE MILLIMETER, UNLESS MENTIONED OTHERWISE.
2. ALL DIMENSIONS TO BE CHECKED AND VERIFIED ON SITE BY CONTRACTORS PRIOR TO COMMENCEMENT OF WORK.
3. ANY DISCREPANCIES TO BE CLARIFIED IMMEDIATELY, AND CHANGES REQUIRED SHALL BE CONFIRMED FROM THE ARCHITECT.
4. WRITTEN DIMENSIONS SHOULD BE FOLLOWED.
5. THIS DRAWING SHALL BE READ IN CONJUNCTION WITH OTHER PERTINENT.

PIGEON

PROJECT :
STORE NAME : ANAD NAGAR STORE CODE :

DWG TITLE :
LOOPING LAYOUT

NOTES:	
AREA STATEMENT	
RETAIL AREA	: 632 SQFT
BOH	: 218 SQFT
TOTAL AREA	: 850 SQFT

TOTAL HIGHT : 3240 MM
CEILING TO FLOORING : 2950
FALSE TO BEAM BOTTOM - 290MM
DRAWN BY : POOJASHREE PS
CHECKED BY : Mr: PRASHANTH
APPROVED BY : Mr: MAYANK
SCALE: NTS
DATE: 17.01.2025

DWG NUMBER
P6

SR NO	SYMBOL	DESCRIPTION
1		LED DOWNLIGHT RECESSED

1		DENVER 24W 60DE
2		LED DOWNLIGHT R DENVER 36W 24DE

3		LED WALLWASHER 24W 40DEG 4000K
---	---	-----------------------------------

4		LED WALLWASHER 36W 40DEG 4000K
5		LED LINEAR PROFILE

		LIGHTLINE 18W 2' 4"
6		LED LINEAR PROFILE LIGHTLINE 10W 1' 4"

7		18W LED Tube
8		CCTV CAMERA
