



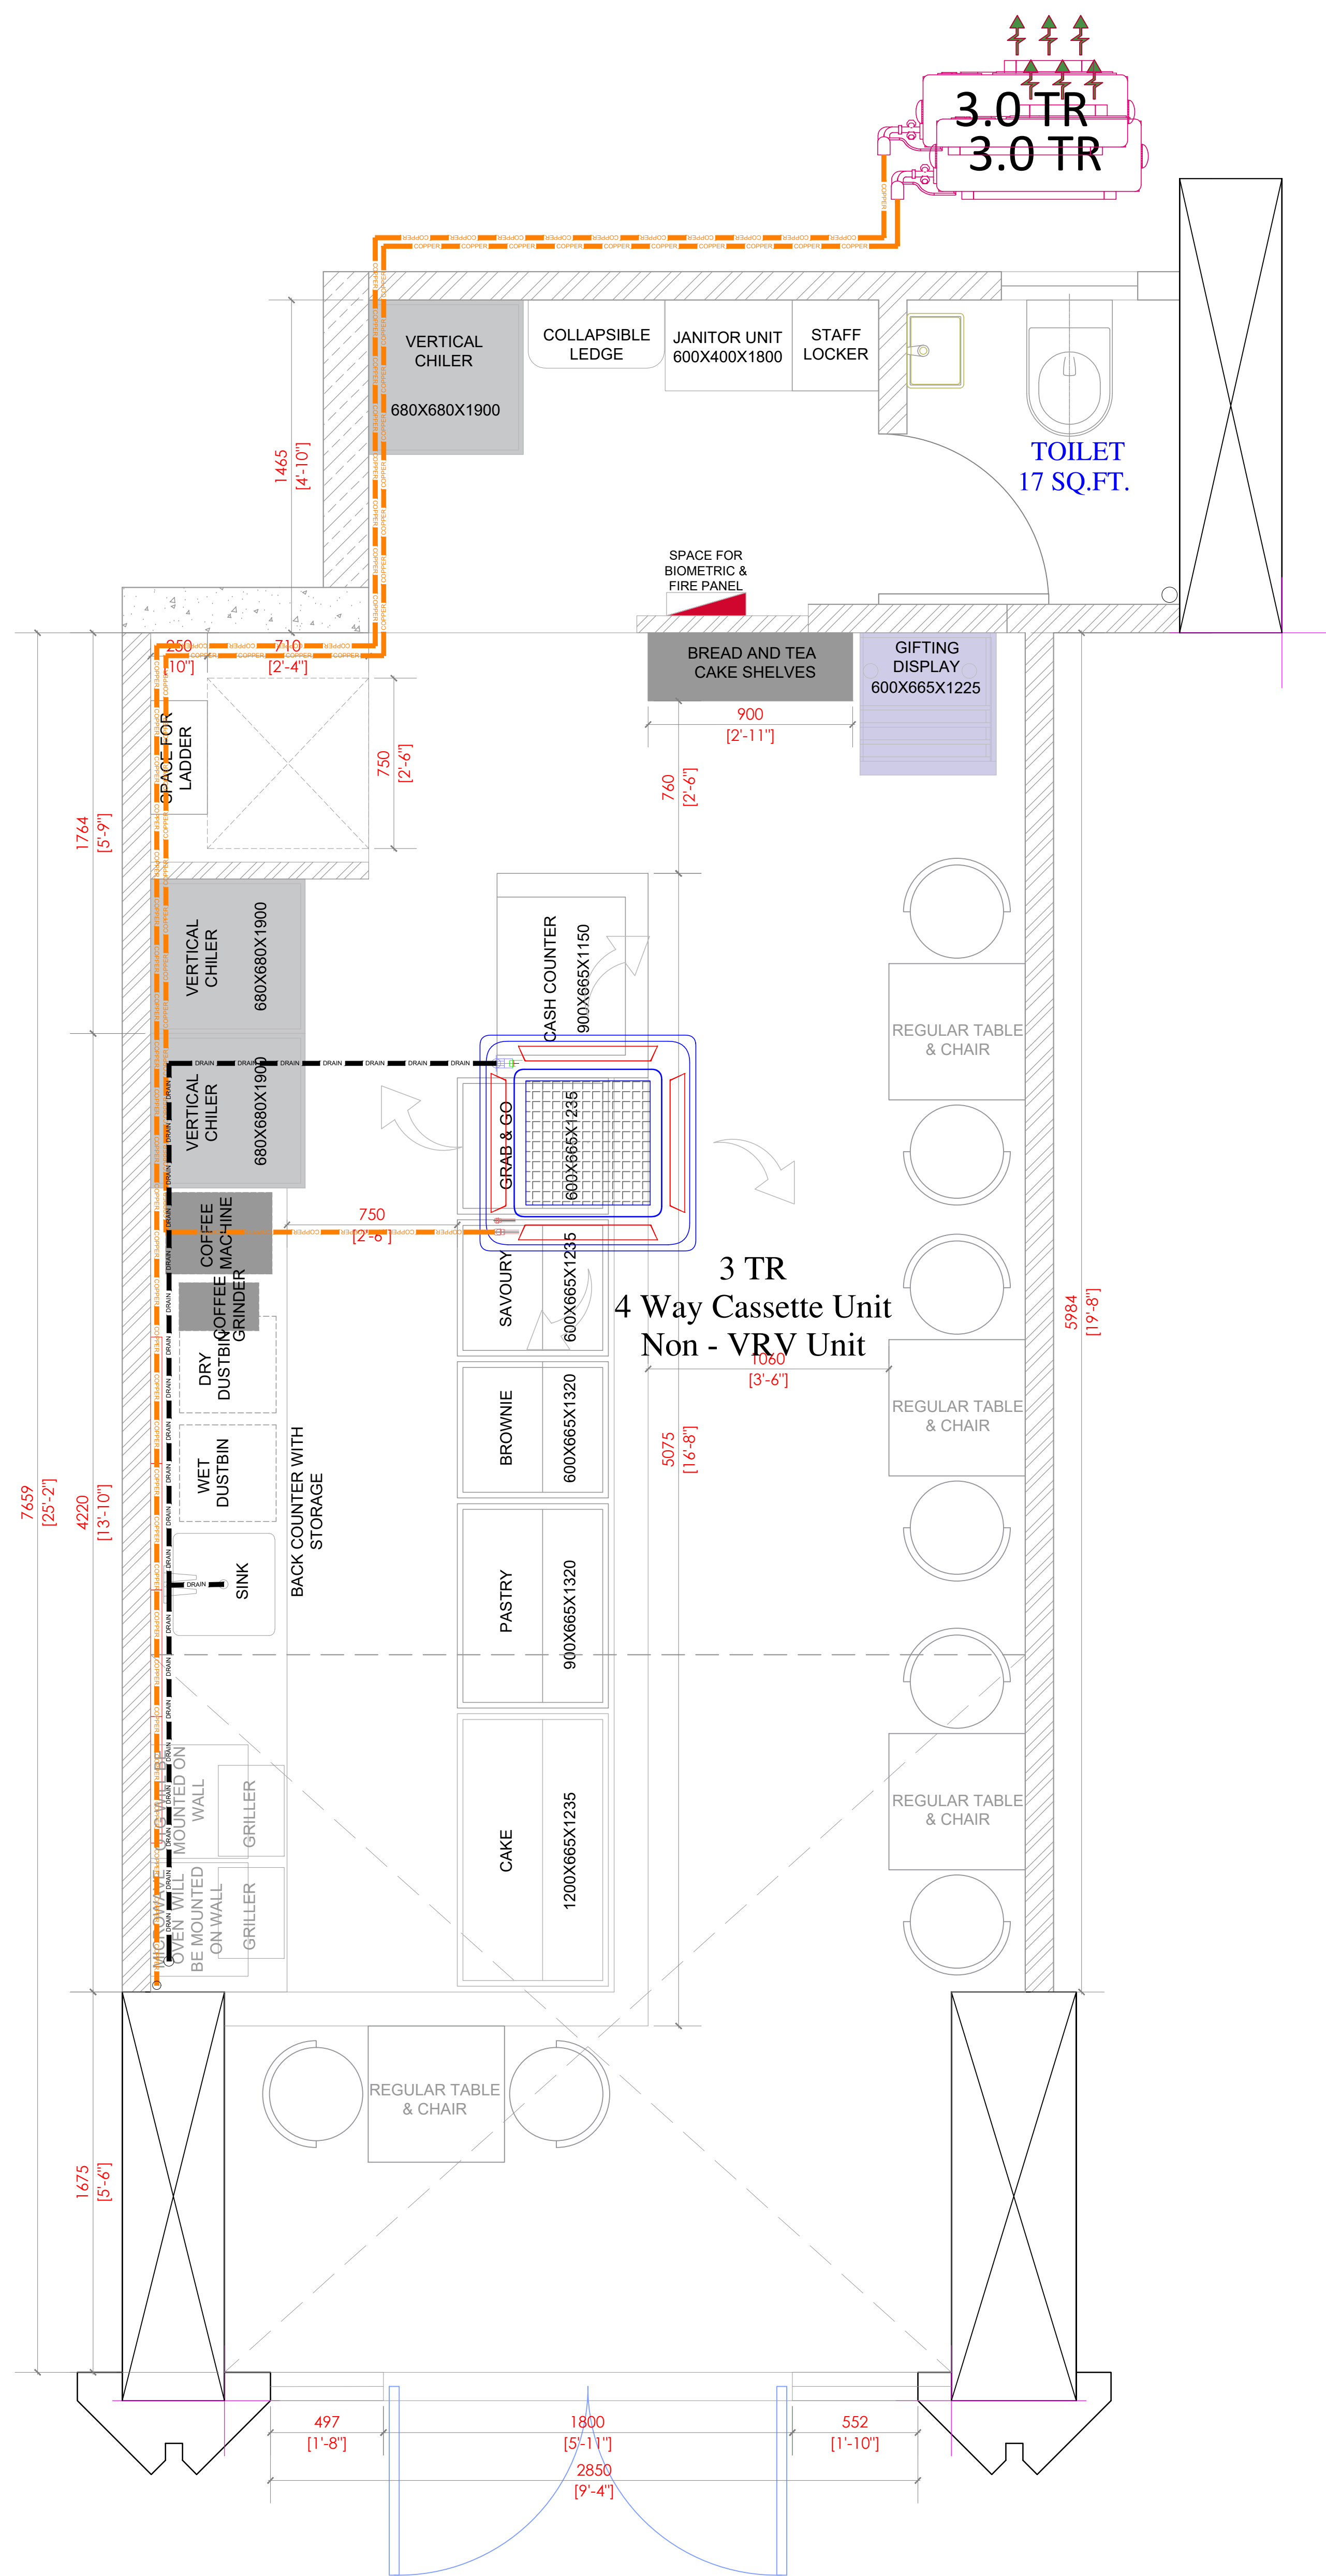

GROUND FLOOR PLAN
TOTAL AREA : 345 SQ.FT
NO OF SEATING : 6 NOS.

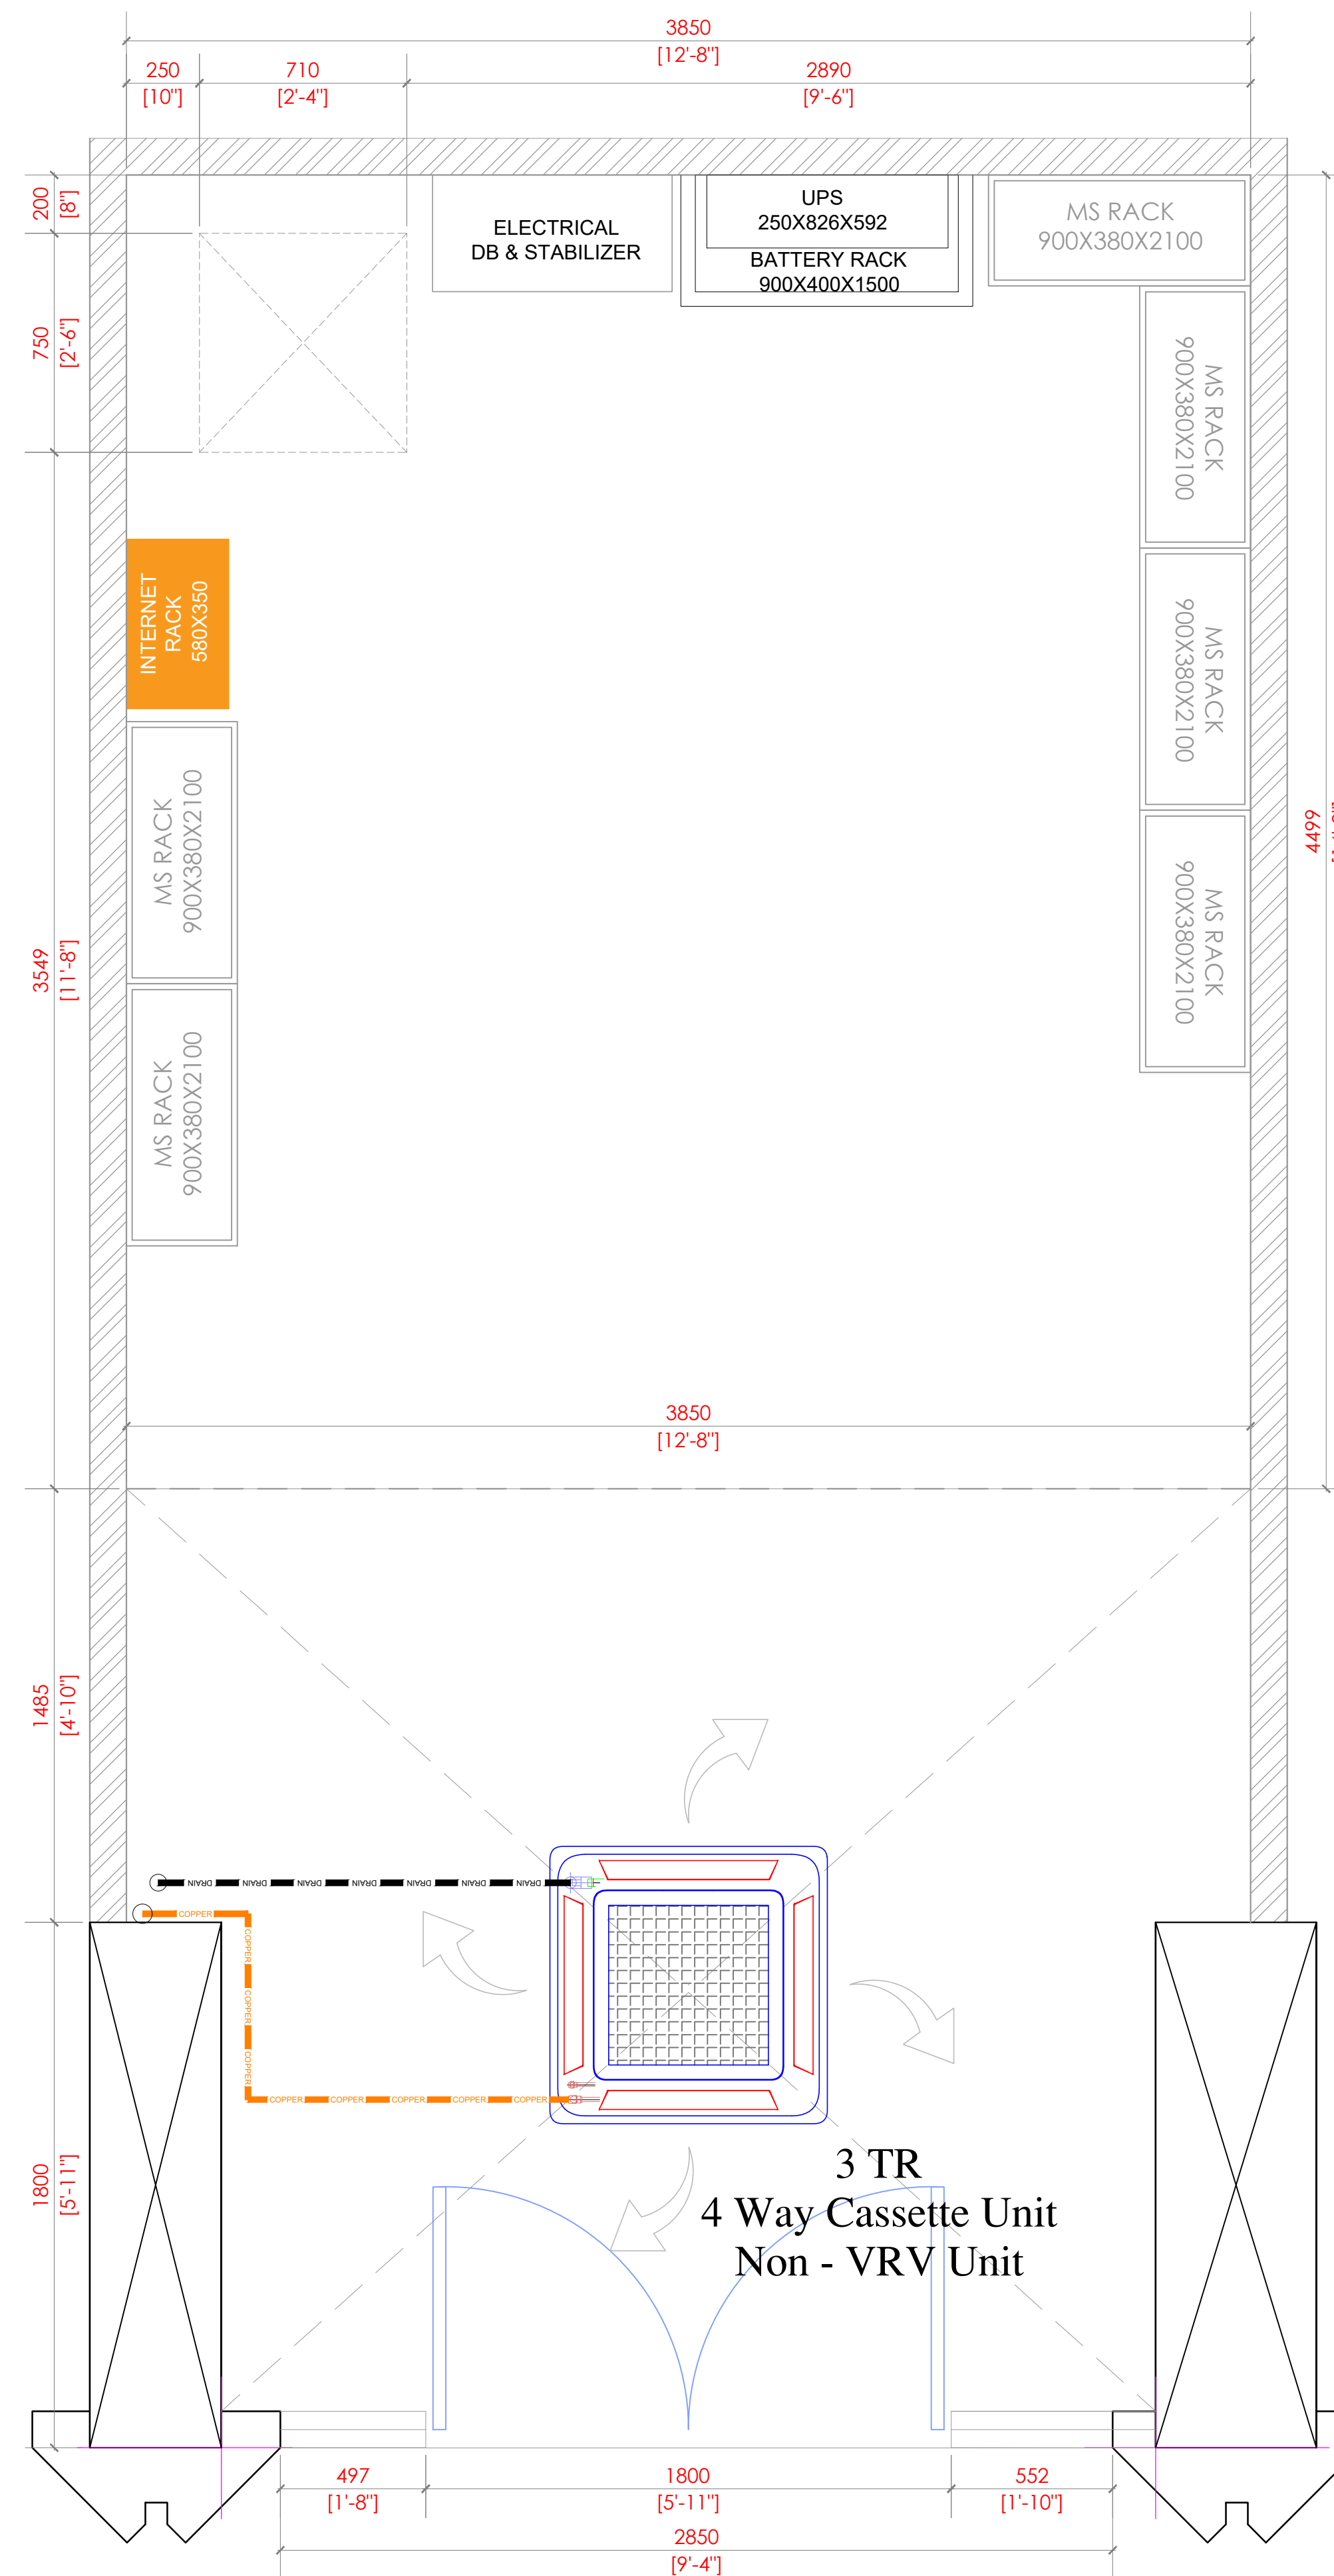

MEZZANINE FLOOR PLAN
TOTAL AREA : 181 SQ.FT
NO OF SEATING : 0 NOS.

REVISIONS

REV.	DATE	DESCRIPTION
R0	06.07.2026	Issued for Approval
R1	06.07.2026	Issued for Approval

CLIENT NAME :-

Theobroma Foods Pvt. Ltd.

SITE ADDRESS :-

Sr. No. 45, Hissa No. 1 & 2, Haveli, Bhugaon
Bavdhan, Pune, Maharashtra 411021



AEON Airconditioning Solutions.
Complete Airconditioning Solutions.
Office No. 108 & 109, Devashree Garden
Commercial Complex, R.W. Sawant Marg, Above
Sheetal Dairy, Rutu Park, Thane - 4000601,
Maharashtra.
E- asim.shaikh@aeonacsolutions.com
Phone - 9322334106 / 9322334108

TITLE:

HVAC Layout for Theobroma Foods Pvt. Ltd._Bhugaon_Pune

DRAWN	ZIYAN.M		
CHECKED			
SCALE	NTS		
DATE	06.07.2026		
PAPER SIZE	A3	DRAWING NO.	01