


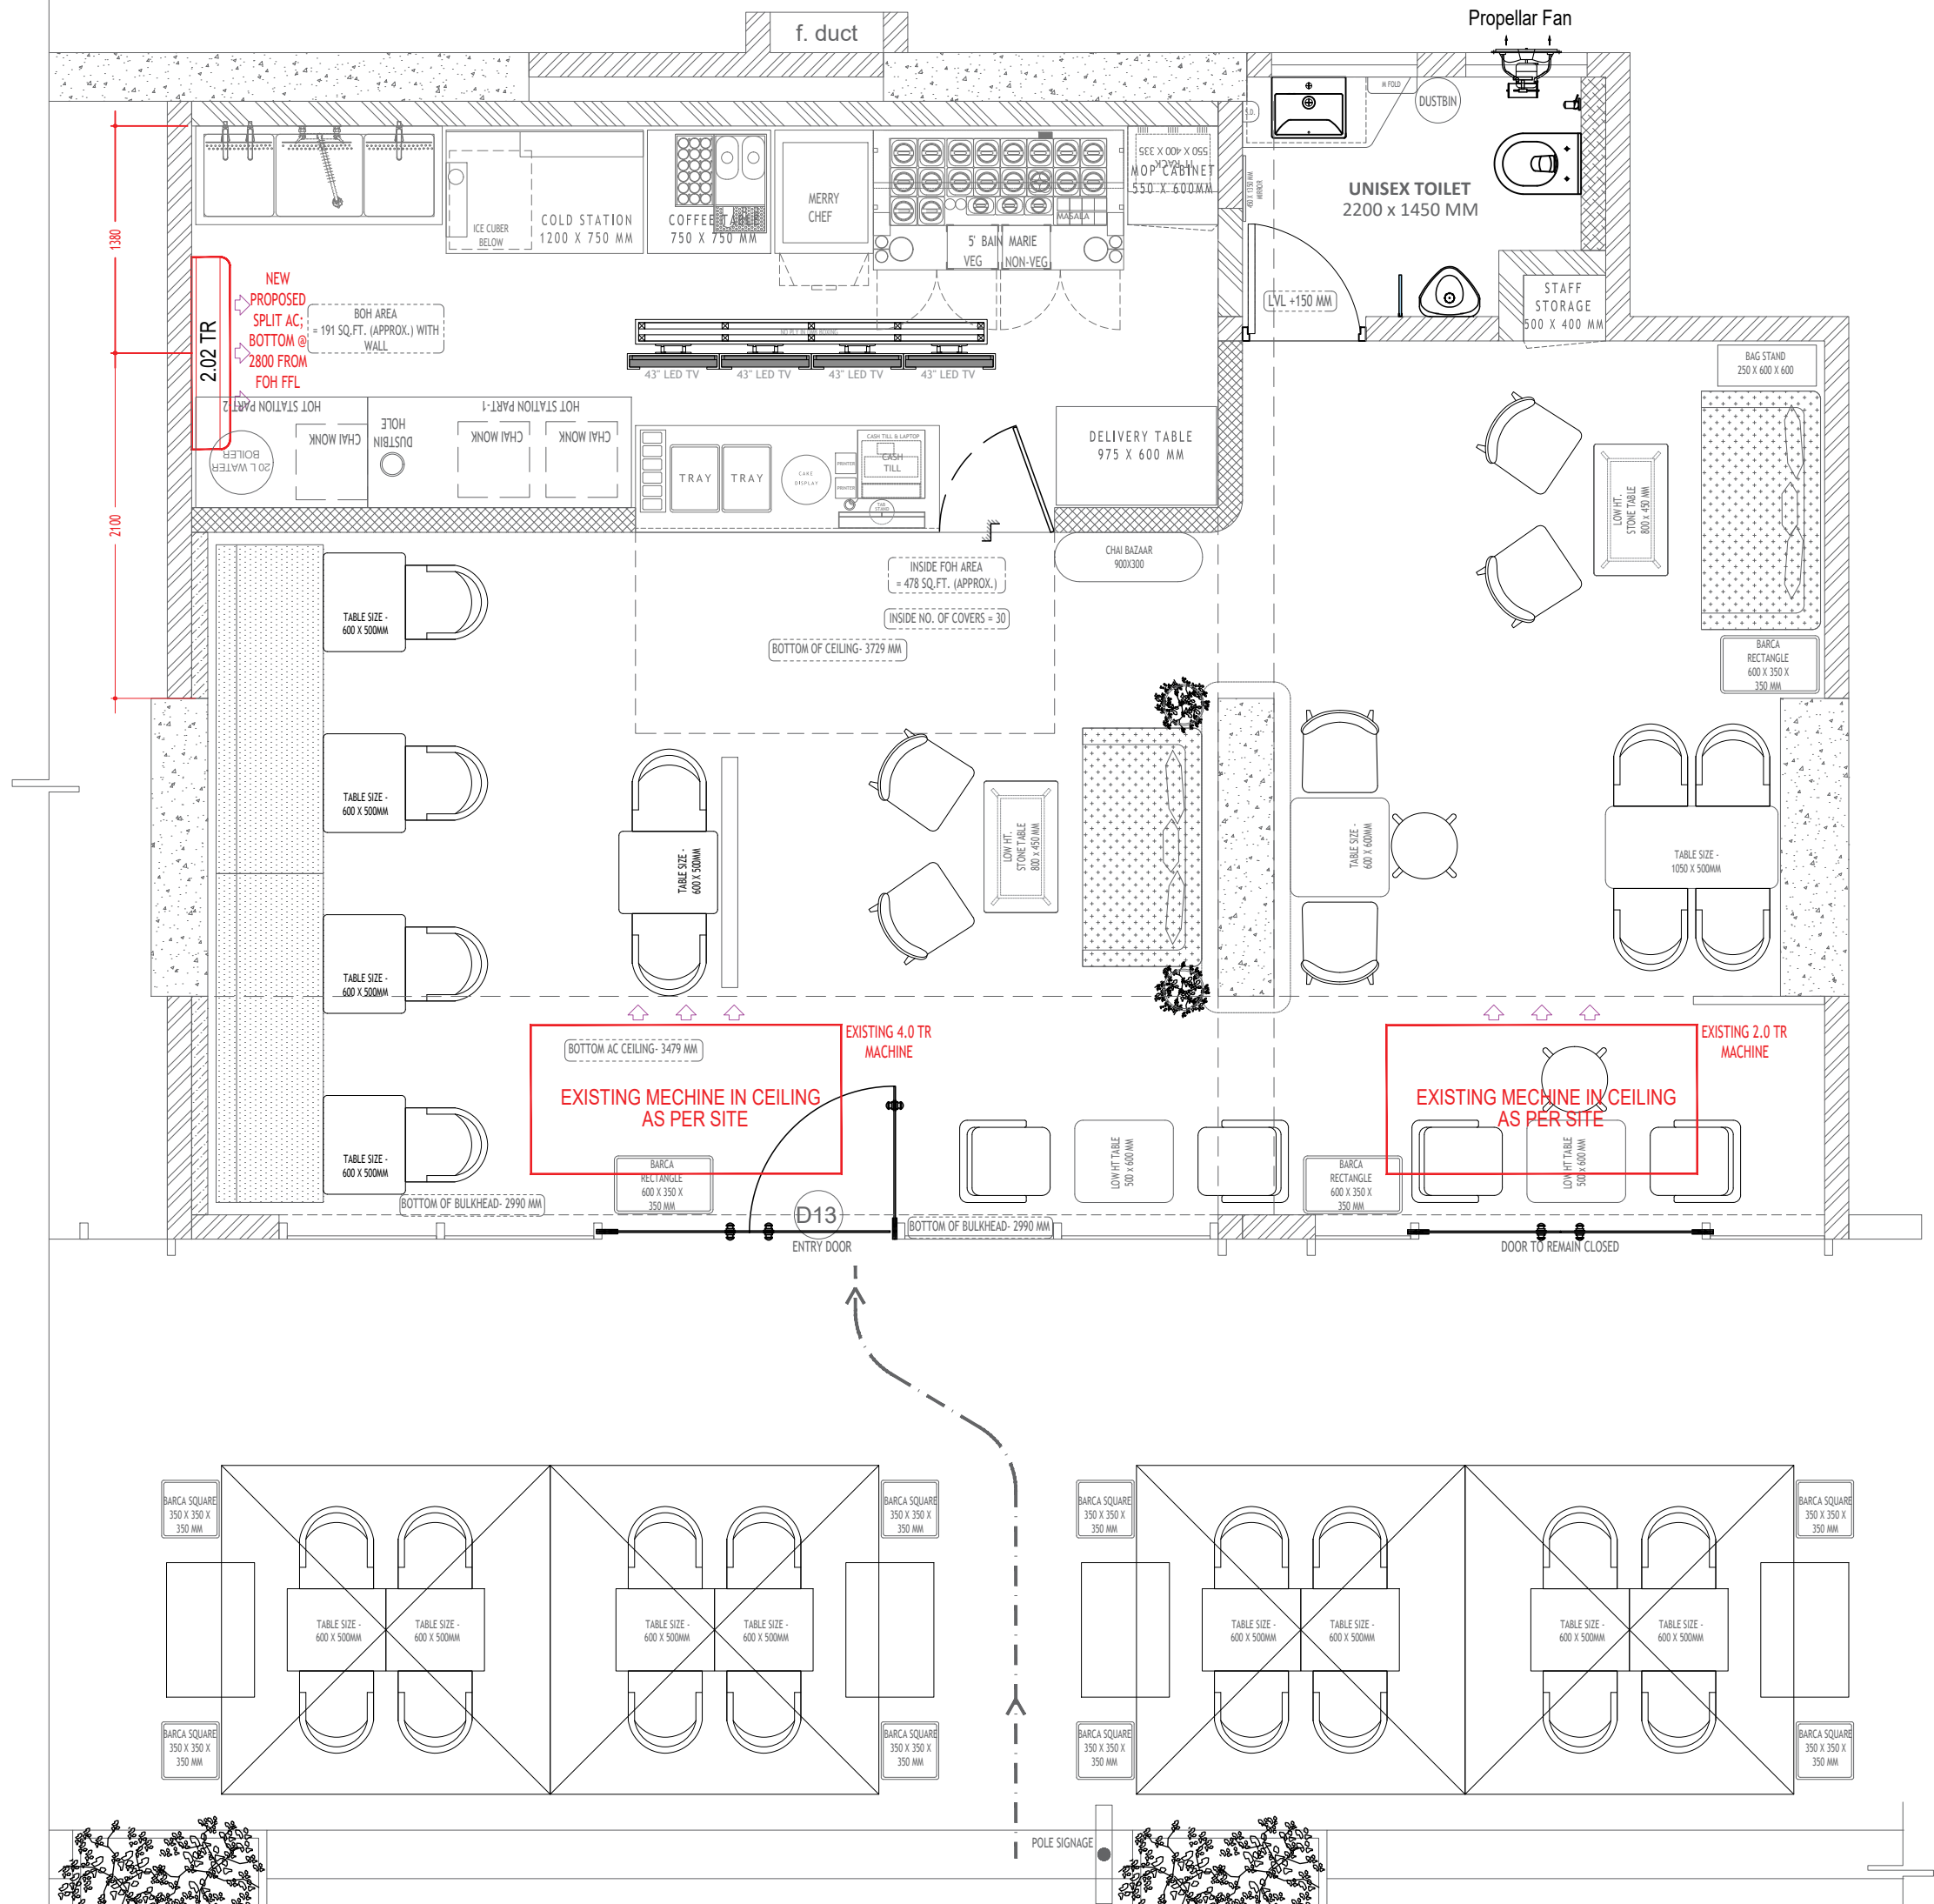

PROJECT

MIRA ROAD
MUMBAI
CHAAYOS ONLY

HVAC LAYOUT

THIS DRAWING & DESIGN IS COPYRIGHT OF THE DESIGNER. NO PORTION MAY BE REPRODUCED WITHOUT WRITTEN PERMISSION OF THE DESIGNERS

- NOTE
1. ALL DIMENSION INCLUDES FINISHES.
 2. DON NOT SCALE DRAWING. ONLY MENTIONED DIMENSIONS ARE TO BE CONSIDERED.
 3. ALL DIMENSION MUST BE CHECKED BEFORE COMMENCING WORK ON SITE.
 4. ANY DISCREPANCIES BE BROUGHT UNDER NOTICE OF ARCHITECTS PRIOR TO COMMENCEMENT OF WORK.

REVISION

S.NO	REMARKS	DATE
REV 1		

KEY PLAN

RELEASED FOR

INFORMATION	TENDER	CONSTRUCTION	AS BUILT
DATE	07.01.2025	N	
SCALE	1:40		
DRAWN BY	SUHAIL A. USMANI		
CHD. BY	MAYANK		

Chaayos

SUNSHINE TEA HOUSE LIMITED
382,100 FEET ROAD,GHITORNI, NEW DELHI