



**GROUND FLOOR BELOW MEZZANINE  
FLOOR PLAN 1374 SQFT**

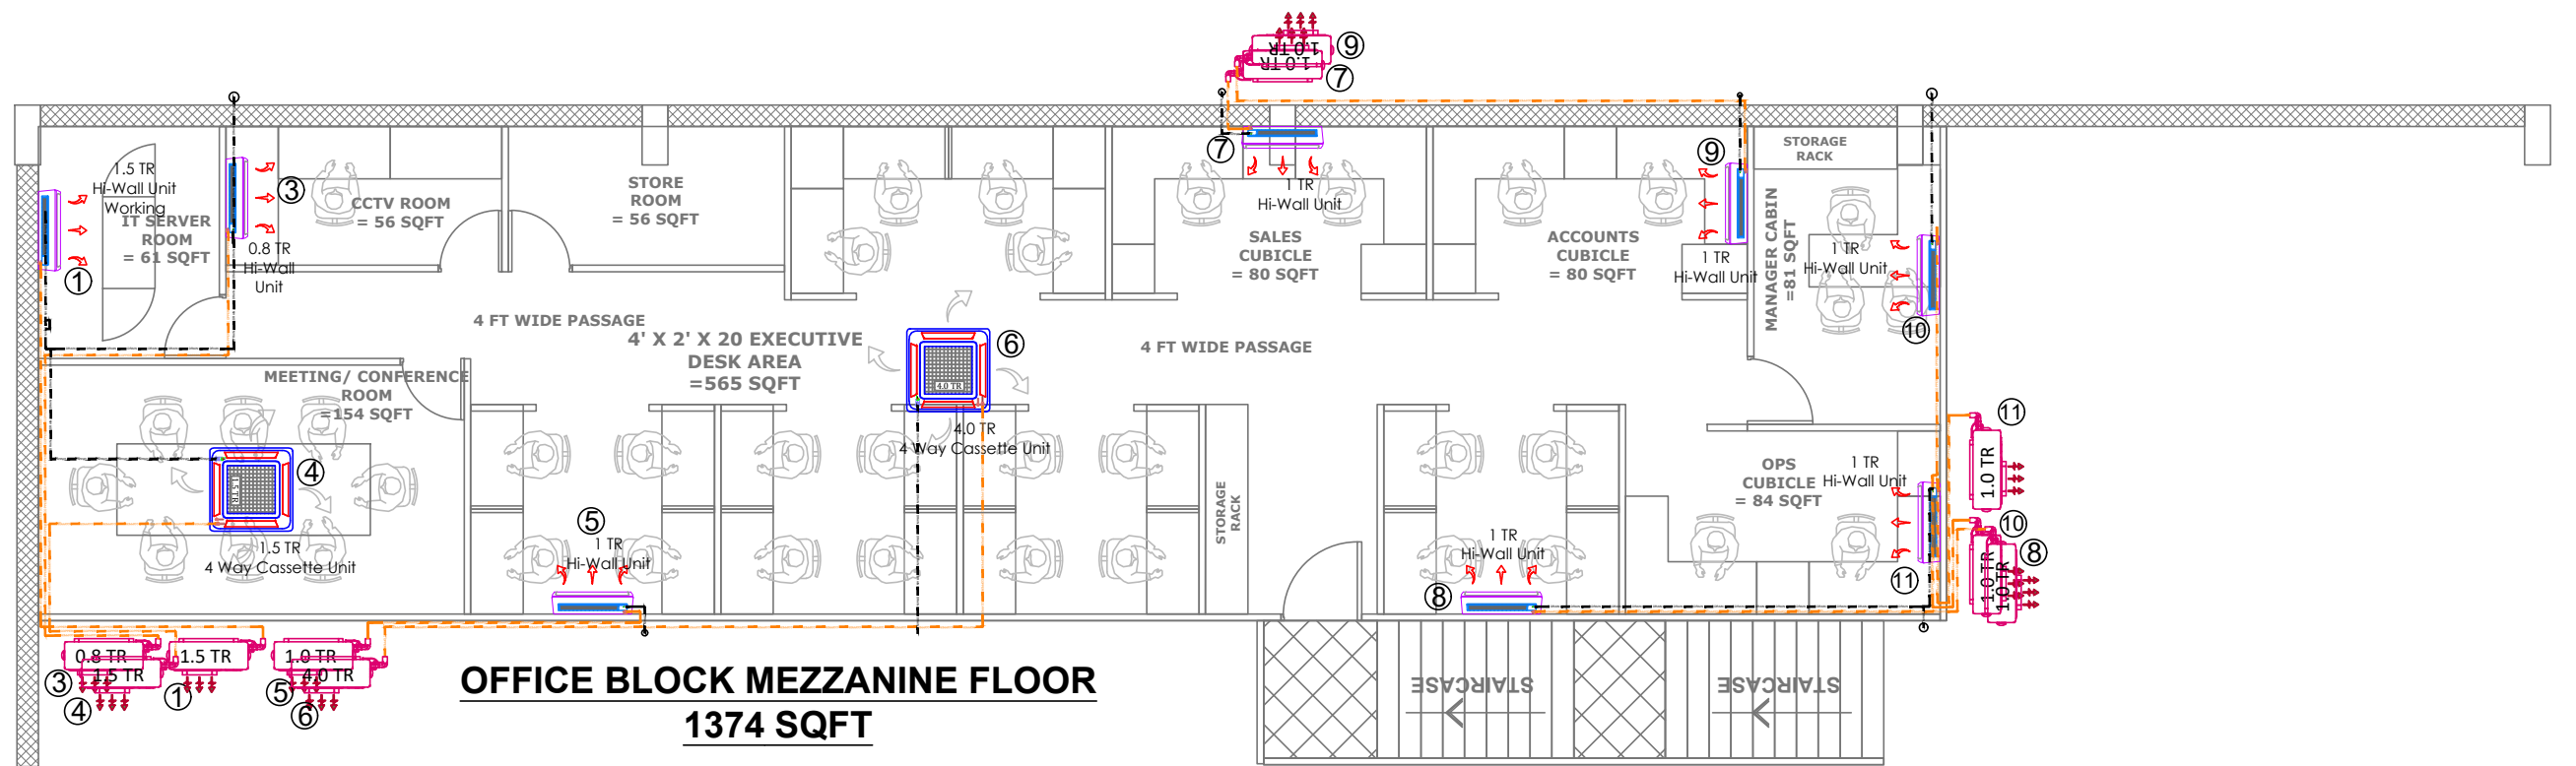

**OFFICE BLOCK MEZZANINE FLOOR  
1374 SQFT**

CLIENT NAME :-	Blue Dart Express Ltd
SITE ADDRESS :-	Siliguri, West Bengal

**AEON Airconditioning Solutions.**  
*Complete Airconditioning Solutions.*  
 Office No. 108 & 109, Devashree Garden Commercial Complex, R.W. Sawant Marg, Above Sheetal Dairy, Rutu Park, Thane - 4000601, Maharashtra.  
 E- asim.shaikh@aeonacsolutions.com  
 Phone - 9322334106 / 9322334108



TITLE: HVAC Layout for Blue Dart Express Ltd_Siliguri_East	
DRAWN	ZIYAN.M
CHECKED	
SCALE	NTS
DATE	27.03.2026
PAPER SIZE	A3
DRAWING NO. <b>01</b>	

REVISIONS		
REV.	DATE	DESCRIPTION
R0	27.03.2026	Issued for Approval